

NOTES:
 1. FOR OUTDOOR PANEL MOUNTING, CONCRETE PAD SHALL BE 6\"/>

CODE REQUIREMENTS

PERFORMANCE OF THE WORK OF THIS CONTRACT SHALL CONFORM TO THE REQUIREMENTS OF APPLICABLE GOVERNING CODES AND ORDINANCES INCLUDING THE FOLLOWING:


2007	BUILDING STANDARDS ADMINISTRATIVE CODE, PART 1, TITLE 24, C.C.R.
2007	CALIFORNIA BUILDING CODE, PART 2, TITLE 24 C.C.R. (2006 IBC, VOLUMES 1-3 WITH CALIFORNIA AMENDMENTS)
2007	CALIFORNIA ELECTRICAL CODE, PART 3, TITLE 24 C.C.R. (2005 N.E.C. WITH CALIFORNIA AMENDMENTS)
2007	CALIFORNIA MECHANICAL CODE, PART 4, TITLE 24 C.C.R. (2006 U.M.C. WITH CALIFORNIA AMENDMENTS)
2007	CALIFORNIA PLUMBING CODE, PART 5, TITLE 24 C.C.R. (2006 U.P.C. WITH CALIFORNIA AMENDMENTS)
2007	CALIFORNIA ENERGY CODE, PART 6, TITLE 24 C.C.R.
2007	CALIFORNIA FIRE CODE, PART 9, TITLE 24 C.C.R. (2006 I.F.C. WITH CALIFORNIA AMENDMENTS)
2007	CALIFORNIA REFERENCED STANDARDS, PART 12, TITLE 24 C.C.R. TITLE 19 C.C.R. PUBLIC SAFETY, STATE FIRE MARSHAL REGULATIONS.
NFPA 13	AUTOMATIC SPRINKLER SYSTEM -----2002 EDITION
NFPA 14	STANDPIPE SYSTEM -----2003 EDITION
NFPA 17A	WET CHEMICAL SYSTEM -----2002 EDITION
NFPA 24	PRIVATE SERVICE MAINS -----2002 EDITION
NFPA 72	NATIONAL FIRE ALARM CODE -----2002 EDITION (NOTE SEE UL STANDARDS 1971 FOR ("VISUAL DEVICES"))

GENERAL NOTES

- VISIT JOB SITE AND VERIFY EXISTING CONDITIONS PRIOR TO BID.
- THE ELECTRICAL WORK SHALL BE INSTALLED IN ACCORDANCE WITH THE NATIONAL ELECTRICAL CODE AND ALL APPLICABLE LOCAL ORDINANCES, WHERE PLANS CALL FOR A HIGHER STANDARD THAN APPLICABLE CODES, THE PLANS SHALL GOVERN.
- CONDUIT RUNS ARE SHOWN DIAGRAMMATICALLY. EXACT LOCATIONS SHALL BE DETERMINED IN THE FIELD TO SUIT FIELD CONDITIONS.
- ALL ELECTRICAL EQUIPMENT, APPLIANCES AND LIGHTING FIXTURES SHALL BE LISTED BY A RECOGNIZED TEST LAB AND BEAR THAT LABEL OF APPROVAL.
- CONTRACTOR SHALL FURNISH, INSTALL AND CONNECT ALL MATERIAL AND EQUIPMENT FOR THIS WORK UNLESS OTHERWISE NOTED.
- FURNISH DISCONNECT SWITCHES AT REMOTE MOTORS.
- ALL SPACES AS INDICATED ON PANELS OR SWITCHBOARD SHALL BE COMPLETE WITH HARDWARE AND BUSSING FOR FUTURE BREAKER OR SWITCH.
- CHECK ARCHITECTURAL PLANS FOR DOOR SWINGS BEFORE INSTALLING SWITCH OUTLETS.
- GROUNDING AND BONDING SHALL BE PER CODE PLUS ANY ADDITIONAL PROVISIONS SPECIFIED OR SHOWN ON DRAWINGS.
- ALL CONDUIT RUNS SHALL CONTAIN A CODE SIZED GROUND CONDUCTOR.
- THESE PLANS ARE NOT COMPLETE UNTIL APPROVED BY THE AUTHORITY HAVING JURISDICTION.
- ALL CONDUCTORS SHALL BE IN CONDUIT.
- ALL CONDUCTORS SHALL BE COPPER WITH TYPE THHN/THWN INSULATION.

SYMBOLS

- CONDUIT EXISTING
 - CONDUIT CONCEALED IN WALL OR CEILING
 - CONDUIT CONCEALED UNDER FLOOR OR BELOW GRADE
 - E CONDUIT STUBBED OUT AND CAPPED
 - CONDUIT TURNED UP
 - CONDUIT TURNED DOWN
 - ≡≡≡ HATCH MARKS INDICATE NO. OF #12 WIRES IN CODE SIZED CONDUIT (3) MAX. IN 1/2" C., (5) MAX. IN 3/4" C., (8) MAX. IN 1" C., NO MARKS = 2#12
 - A-3 HOME RUN: LETTER INDICATES PANEL, NUMBER(S) INDICATES CIRCUIT(S).
 - ≡≡≡ SAWCUT
 - ⊕ GROUND CONNECTION
 - ▨ DISTRIBUTION SWITCHBOARD OR PANEL
 - ▨ PANEL, BRANCH CIRCUIT TYPE, SURFACE AND FLUSH
 - ▨ SIGNAL TERMINAL CABINET, SURFACE & FLUSH
 - FLUORESCENT FIXTURE
 - OUTLET DATA: BAR INDICATES WALL MOUNT, LETTER INDICATES SWITCH CONTROL, NO. INDICATES CIRCUIT.
 - SURFACE FIXTURE ON FLUSH OUTLET.
 - RECESSED FIXTURE WITH JUNCTION BOX FOR THRU WIRING
 - EXIT LIGHT WITH ARROWS AS SHOWN ON PLANS, WALL AND CEILING MOUNT.
 - LOW LEVEL EXIT SIGN, +6" AFF, +4" FROM DOOR JAMB
 - LIGHT FIXTURE DESIGNATION, LETTER INDICATES TYPE, NO. INDICATES WATTAGE. SEE FIXTURE SCHEDULE.
 - MECHANICAL EQUIPMENT DESIGNATION. SEE MECHANICAL DRAWINGS.
 - SPECIAL RECEPTACLE - SEE PLAN
 - METER
 - FLUSH FLOOR RECEPTACLE
 - RECEPTACLE, DUPLEX, 15A, 125V, NEMA 5-15R +18" U.N.O.
 - DUPLEX RECEPTACLE MTD. ABOVE BACKSPLASH
 - DUPLEX RECEPTACLE W/LOWER HALF SWITCHED
 - GFI GROUND FAULT CIRCUIT INTERRUPTING RECEPTACLE
 - DOUBLE DUPLEX RECEPTACLE
 - CEILING RECEPTACLE
 - RECEPTACLE, DUPLEX, 20A, 125V, NEMA 5-20R +18" U.N.O.
 - JUNCTION BOX 4" SQUARE, 1-1/2" DEEP U.N.O.
 - THERMOSTAT F.B.O. +48"
 - MOTOR, NO. INDICATES HORSEPOWER
 - CLOCK OUTLET +7"-6" U.N.O.
 - DISCONNECT SWITCH, NON-FUSED
 - DISCONNECT SWITCH FUSED HORSEPOWER RATED OR SIZED AS NOTED
 - COMBINATION MAGNETIC STARTER WITH DISCONNECT SWITCH AND FUSES
 - MAGNETIC MOTOR STARTER W/OVERLOADS IN EACH PHASE
 - RECESSED SPEAKER
 - PUSHBUTTON
 - PHOTOCELL
 - SMOKE DETECTOR
 - TELEPHONE/COMPUTER/DATA OUTLET, TWO GANG BOX W/1 GANG COVERPLATE & GROMMETTED OPENING +18" U.N.O.
 - CABLE TV OUTLET +18" U.N.O.
 - MOTION SENSOR
 - EXISTING SWITCH
 - S SINGLE POLE SWITCH
 - S² DOUBLE POLE SWITCH
 - S³ THREE WAY SWITCH
 - S^P SWITCH W/PILOT LT.
 - S^M MANUAL MOTOR STARTER
 - FACP FIRE ALARM CONTROL PANEL
 - GFI GROUND FAULT CIRCUIT INTERRUPTING
 - LST LABOR SAVING TANDEM
 - MLO MAIN LUGS ONLY
 - W/ WITH
 - C.O. CONDUIT ONLY
 - W.P. WEATHERPROOF
 - F.B.O. FURNISHED BY OTHERS, INSTALL & CONNECT
 - U.N.O. UNLESS NOTED OTHERWISE
 - N.E.C. NATIONAL ELECTRICAL CODE
 - N.I.C. NOT IN CONTRACT
 - (E) EXISTING
 - (N) NEW
 - (R) REMOVE
 - (RL) RELOCATE
 - S/M SURFACE MOUNT
 - U/G UNDERGROUND
 - CWP COLD WATER PIPE
 - AFP ABOVE FINISHED FLOOR
 - HACR HEATING AND AIR CONDITIONING RATED CIRCUIT BREAKER
 - N.L. NIGHT LIGHT
- NOTE: NOT ALL SYMBOLS SHOWN ARE USED ON THIS PROJECT.

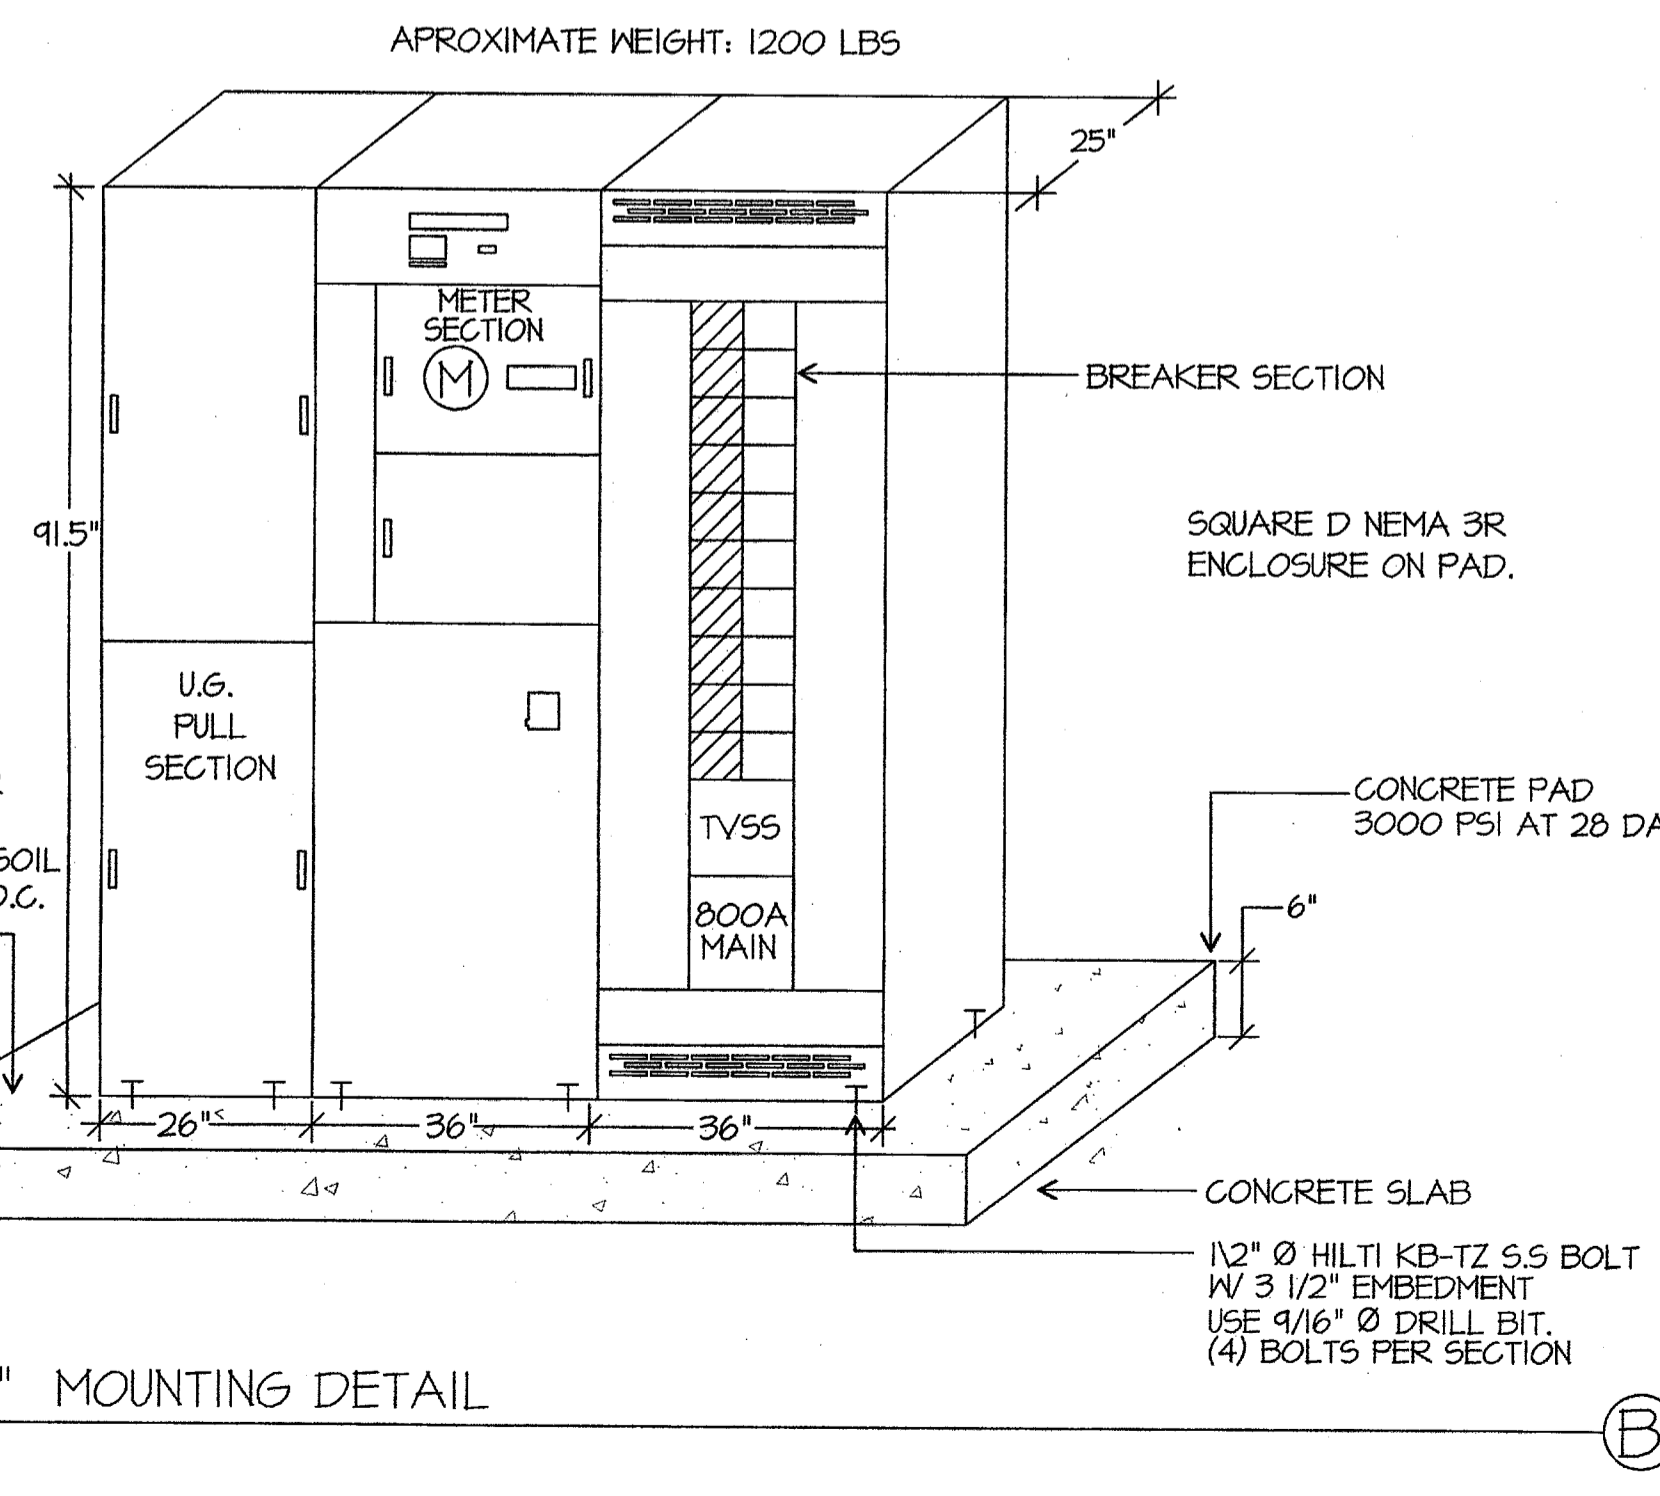

Ownership of Documents
 This document, the ideas and designs incorporated herein, as an instrument of Professional Service is the property of Integrated Designs by SOMAM, Inc. and is not to be used, in whole or in part for any other project without written authorization.
 © COPYRIGHT 2008

integrated designs by SOMAM, Inc.
 ARCHITECTURE • INTERIOR DESIGN • CONSTRUCTION MANAGEMENT
 6011 N. Fresno, Suite 130 - Fresno, California 93710
 Phone (559) 438-0881 Fax (559) 438-0887 E-Mail: design@somam.com
 www.integrateddesigns.com

Revision Description:
 10/15/09
 ADDENDUM 1

Issue Date: 05/02/06
 Date: 05/02/06
 Designer: DESIGNER
 DR: DRAFTER
 PC: CJM



DSA Identification Stamp:
 Stamp(s):

Stamp(s):

Job No.: 3832
 Sheet No.: E-0
 Release: APPENDUM 1
 CURTIS MCNALLY

JMPE
 REGISTERED PROFESSIONAL ENGINEER
 LICENSE NO. 51199
 STATE OF CALIFORNIA

JMPE
 REGISTERED PROFESSIONAL ENGINEER
 LICENSE NO. 51199
 STATE OF CALIFORNIA

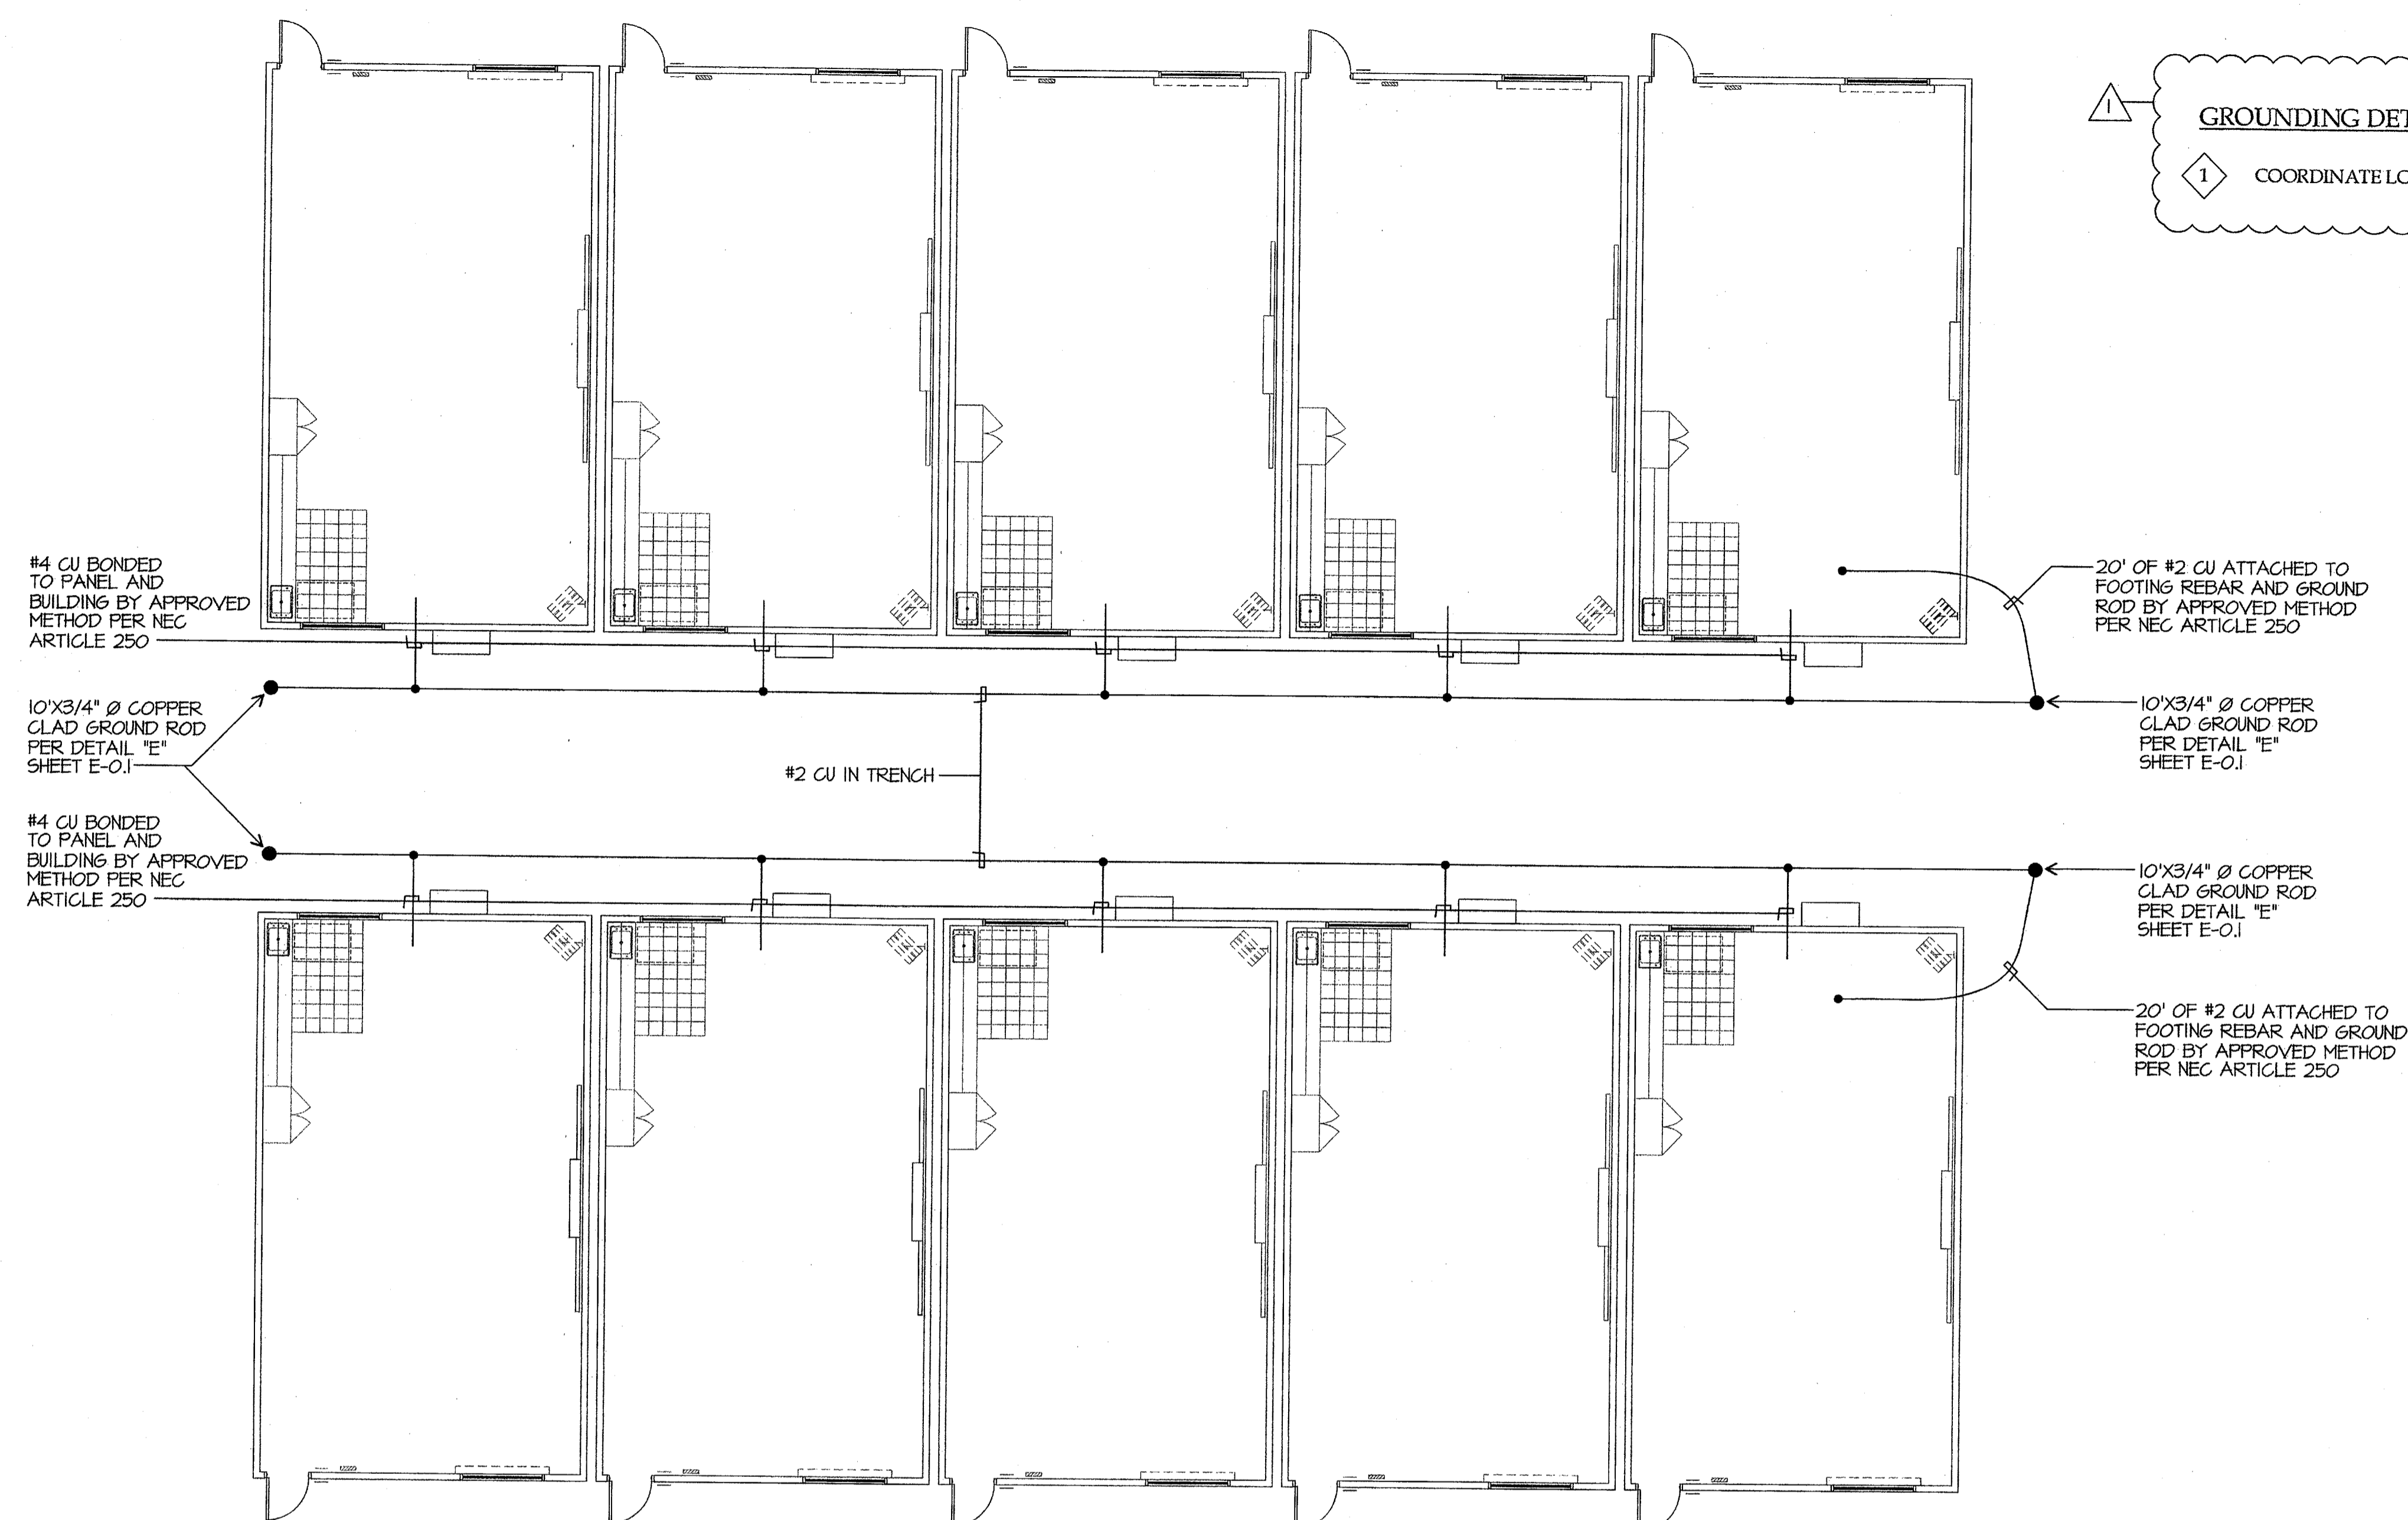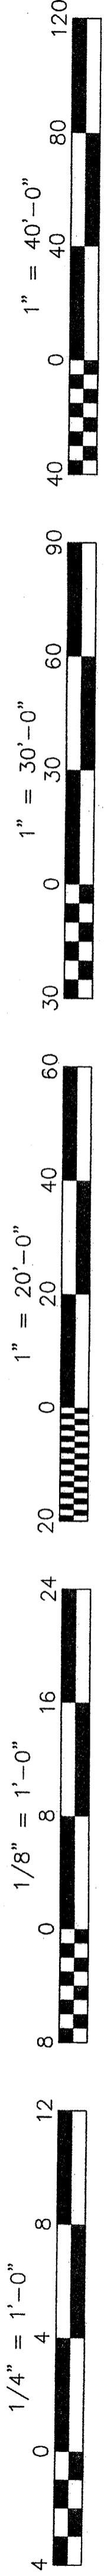


GROUNDING DETAIL NOTES


1 COORDINATE LOCATIONS OF WORK SHOWN WITH CIVIL DRAWINGS.

GROUNDING DETAIL


SCALE: 1/8"=1'-0"

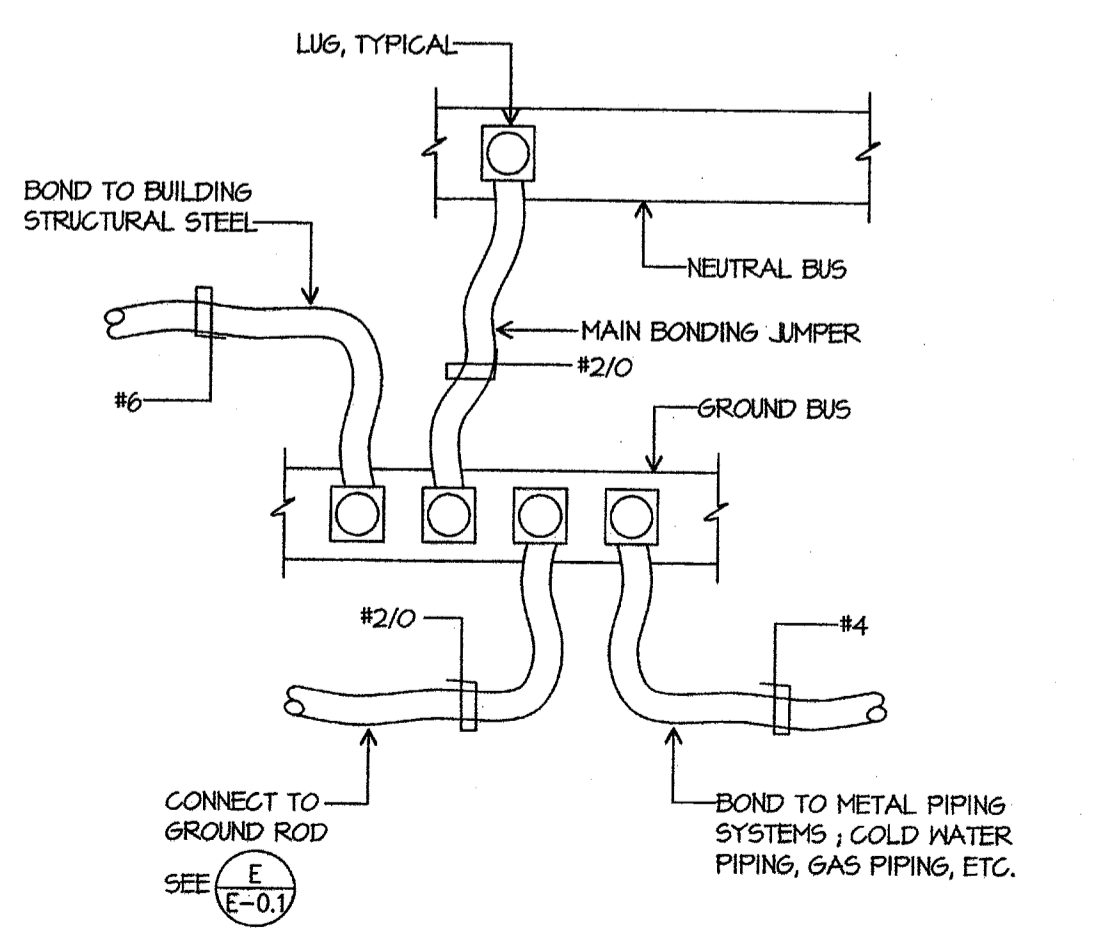

BONDING DIAGRAM "MSB"
SCALE: NONE

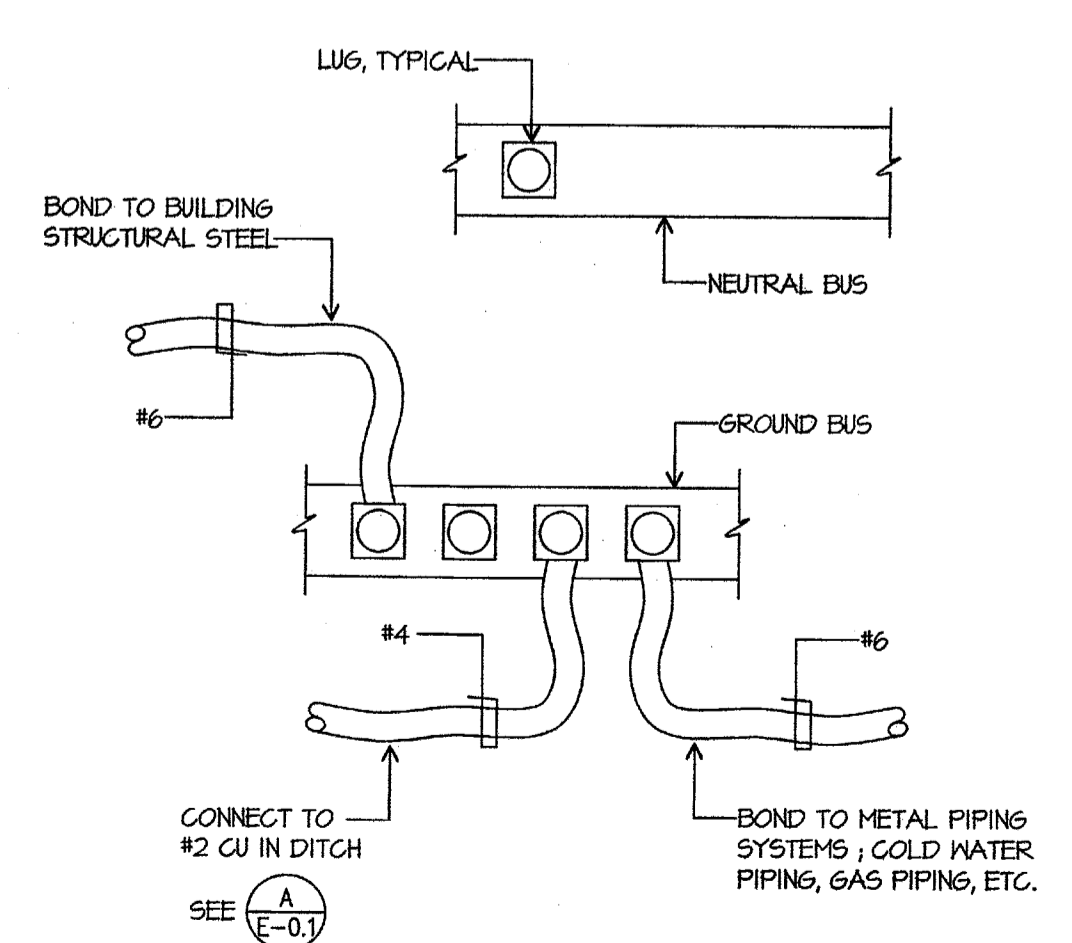


BONDING DIAGRAM PORTABLE PANEL
SCALE: NONE

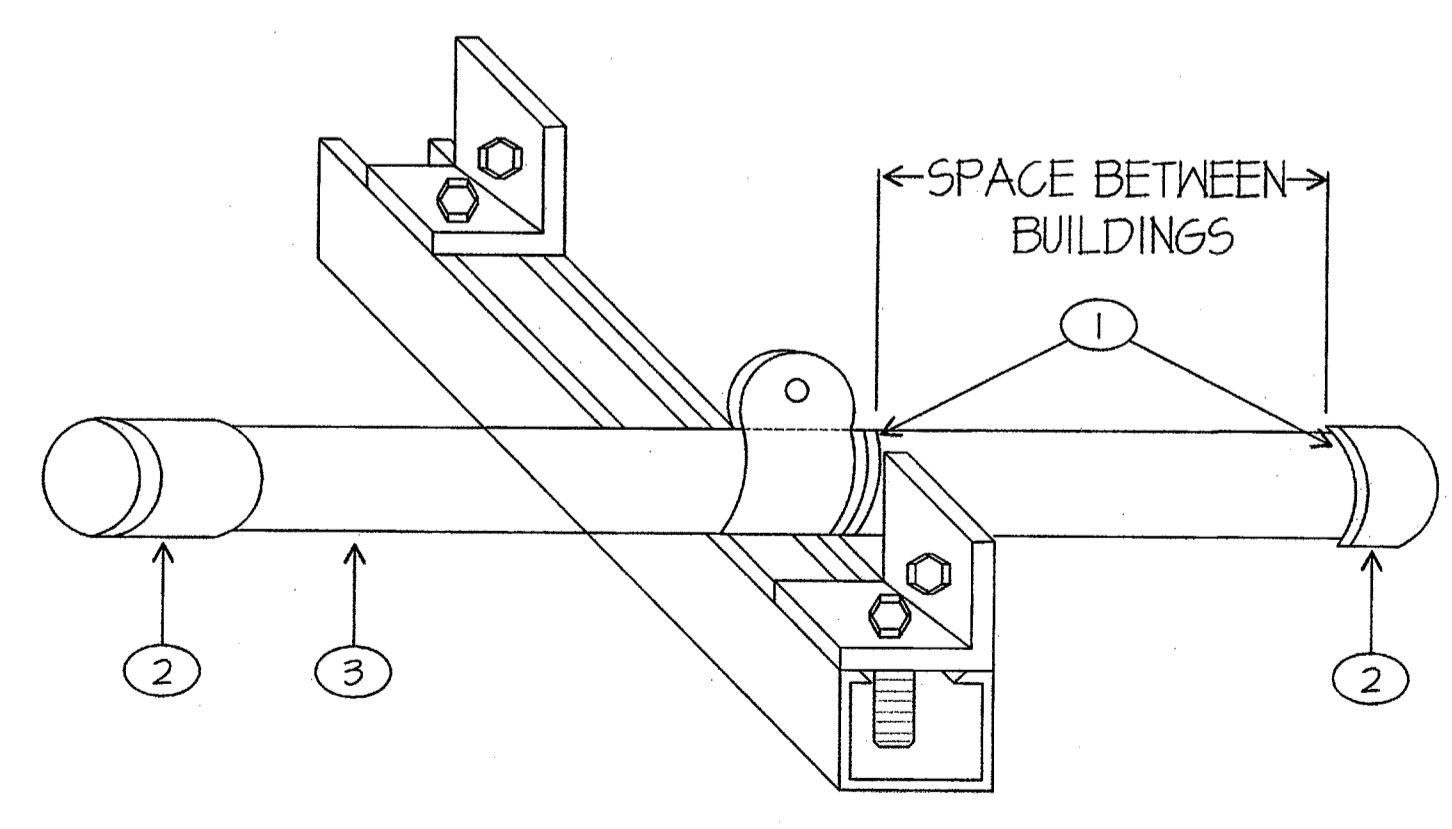

CONDUIT SLEEVE SUPPORT
WALL MOUNTED UNISTRUT BRACKETS
FOR ONE OR MORE CONDUITS
SCALE: NONE

- 1 FOAM FILL AND FIRE CAULK THE WALLS AFTER CONDUITS ARE INSTALLED.
- 2 INSULATED THROAT SET SCREW CONNECTOR
- 3 USE OF EMT IS ACCEPTABLE FOR SLEEVE INSTALLATION.

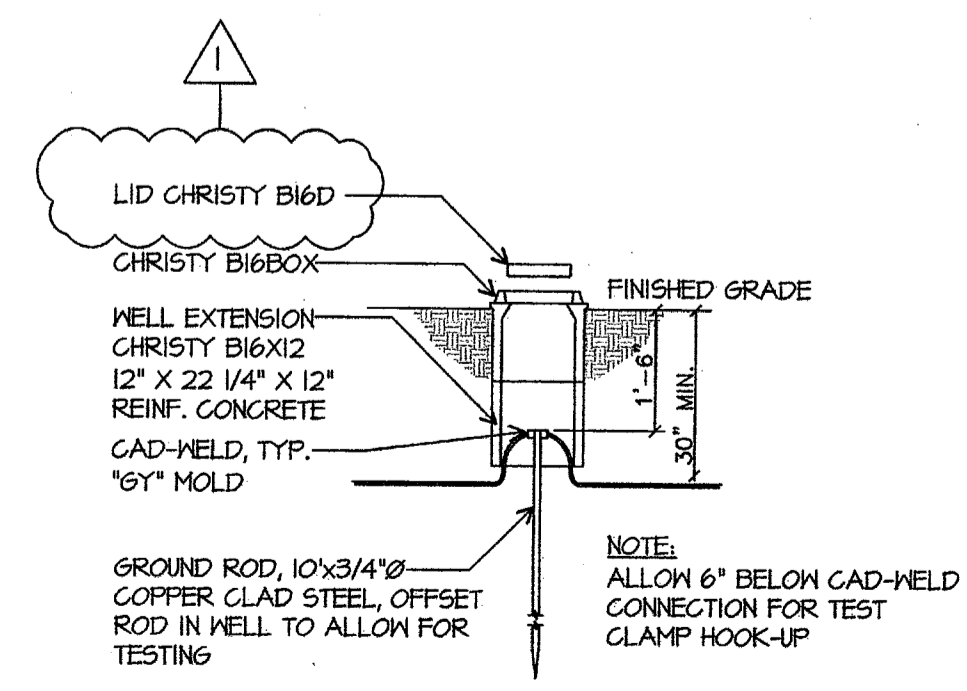

GROUND ACCESS BOX

JMPE
LICENSED PROFESSIONAL ENGINEER
ELECTRICAL ENGINEERING
LIGHTING DESIGN
CA REGISTRATION NO. 813003
5000 MIDWAY AVENUE, SUITE 202
BAKERSFIELD, CA 93309
(805) 835-7881
FAX (805) 835-7853
www.jmpe.com



Ownership of Documents
This document, the ideas and designs incorporated herein, as an instrument of Professional Service is the property of Integrated Designs by SOMAM, Inc. and is not to be used, in whole or in part for any other project without written authorization.
© COPYRIGHT 2009

integrated designs by SOMAM, Inc.
ARCHITECTURE • ENGINEERING • INTERIOR DESIGN • CONSTRUCTION MANAGEMENT
6011 N. Fresno, Suite 130 - Fresno, California 93710
Phone (559) 436-0881 Fax (559) 436-0887 E-Mail: design@somam.com
www.integrateddesigns.com

Revision:	ADDENDUM 1	Rev. Date:	10/15/09
Revision Description:		Rev. Date:	
Revision:		Rev. Date:	
Revision Description:		Rev. Date:	

Sheet Title:
**SINGLE LINE DIAGRAM SYMBOLS
DETAILS, GENERAL NOTES**

Project Name & Address:
**MUNSEY ELEMENTARY SCHOOL
10 NEW PORTABLE CLASSROOMS**
BAKERSFIELD CITY SCHOOL DISTRICT
3801 BRAVE AVE. BAKERSFIELD, CA 93309



Issue Date: 05/02/06
Date: 05/02/06
Designer: DR
Drafter: FC
C.M.

Stamp(s):


Job No.: **3832**

Sheet No.: **E-0.1**


Release: **APPENDUM #1**
CURTIS MCNALLY

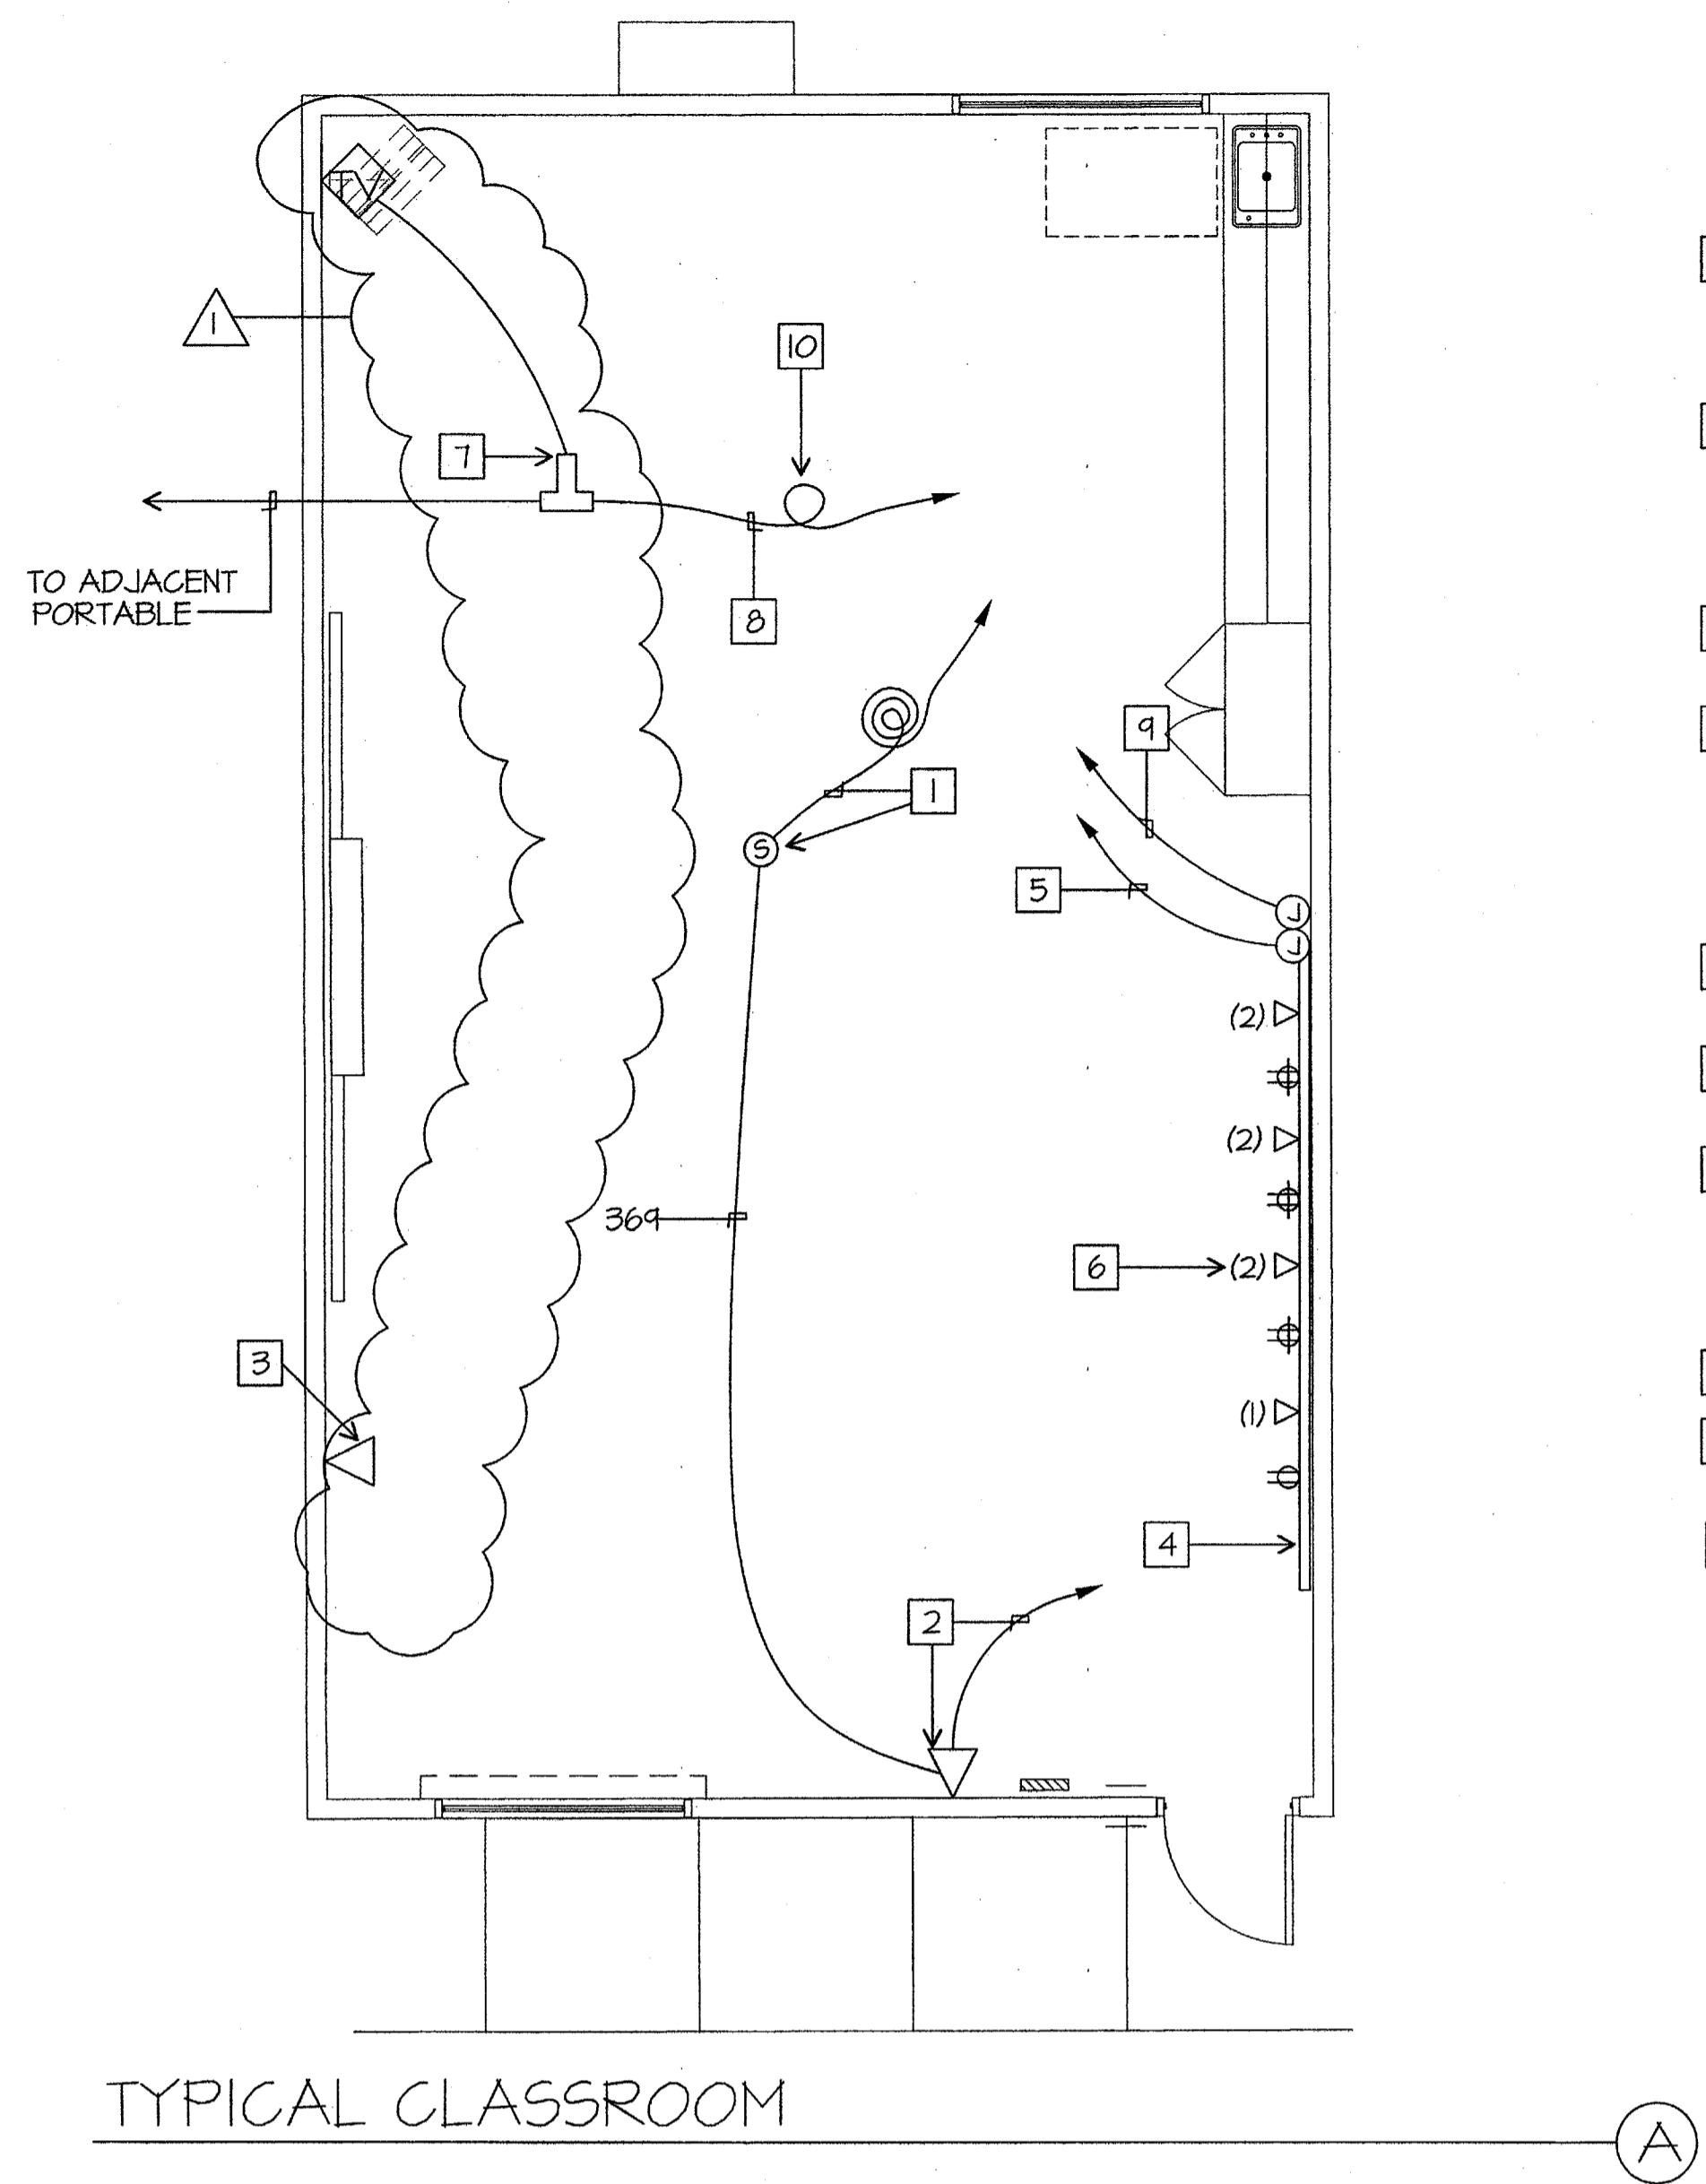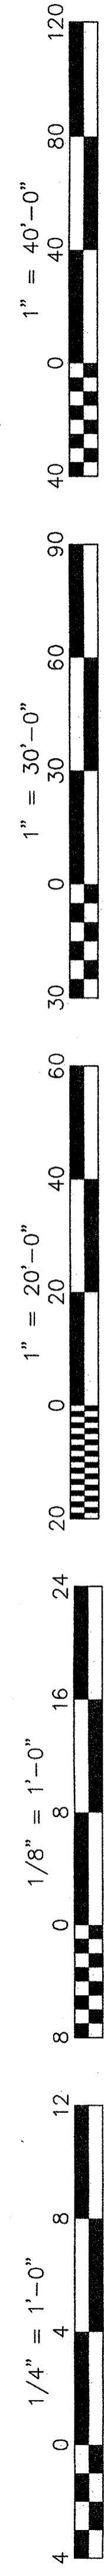


- TYPICAL CLASSROOM NOTES**
- 1 PROVIDE (ATLAS MODEL #SD72-W 25W/70W OR EQUAL) CEILING MOUNTED SPEAKER. PROVIDE A DEDICATED WESTPENN 369 CABLE BACK TO THE TERMINAL CABINET. TERMINATE ON 66 BLOCK. TERMINATE SHIELDED CABLE ON SPEAKER. PROVIDE 3 SERVICE LOOPS OF CABLE AT EACH SPEAKER LOCATION.
 - 2 PROVIDE (CORTELCO EASYTOUCH MODEL #240085-VOE-21F, COLOR SANDSTONE) TELEPHONE WITH RJ11 JACK AT EXISTING OUTLET. EXTEND 369 CABLE FROM SPEAKER, USE ONE OF TWO PAIR LEFT FOR TELEPHONE CONNECTION. PROVIDE ONE DEDICATED CAT 5 CABLE, (GENERAL CABLE #5500) TO IDF CABINET (FUTURE SPARE).
 - 3 PROVIDE RJ45 DATA JACK AT (E) OUTLET. ROUTE (1) CAT5 CABLE (GENERAL CABLE #5500) BACK TO NEAREST IDF CABINET AND TERMINATE ON PATCH PANEL.
 - 4 SURFACE MOUNT WIREMOLD BRAND, TWO COMPARTMENT 5400 SERIES RACEWAY WITH SPLIT COVER. CONTRACTOR SHALL PROVIDE ALL ACCESSORIES, FITTINGS, FACEPLATES AND DEVICES FOR A COMPLETE SYSTEM. COORDINATE EXACT LOCATION WITH ROBERT VAN TASSLE, SUPERVISOR, PLANNING AND CONSTRUCTION BAKERSFIELD CITY SCHOOL DISTRICT, 661-631-5884. MOUNT AT 18" A.F.F.
 - 5 PROVIDE (7) CAT5 CABLES BACK TO CLOSEST IDF AND TERMINATE ON PATCH PANEL.
 - 6 NUMBER SIGNIFIES THE QUANTITY OF RJ45 JACKS AT DATA LOCATION. CONTRACTOR SHALL PROVIDE AND INSTALL CABLE, JACKS AND TERMINATIONS.
 - 7 PROVIDE BLONDER TONGUE T-TAPS WITH QUAD SHIELD COMPRESSION TERMINATIONS. CABLE CONTINUES TO ADJACENT PORTABLE CLASSROOM. INTERIOR TV CABLE SHALL BE RG6 QUAD SHIELD CABLE. PROVIDE 12' OF EXTRA CABLE PER CLASSROOM. COORDINATE WITH GARY TAYLOR, NETWORK SYSTEMS ENGINEER FOR BAKERSFIELD CITY SCHOOL DISTRICT, 661-631-4745.
 - 8 FROM COMMUNICATION TERMINAL CABINET.
 - 9 TO SPARE 120V CIRCUIT IN CLASSROOM PANEL. PROVIDE 20/1 CIRCUIT BREAKER AS NEEDED.
 - 10 PROVIDE 2' SERVICE LOOP, TYPICAL.

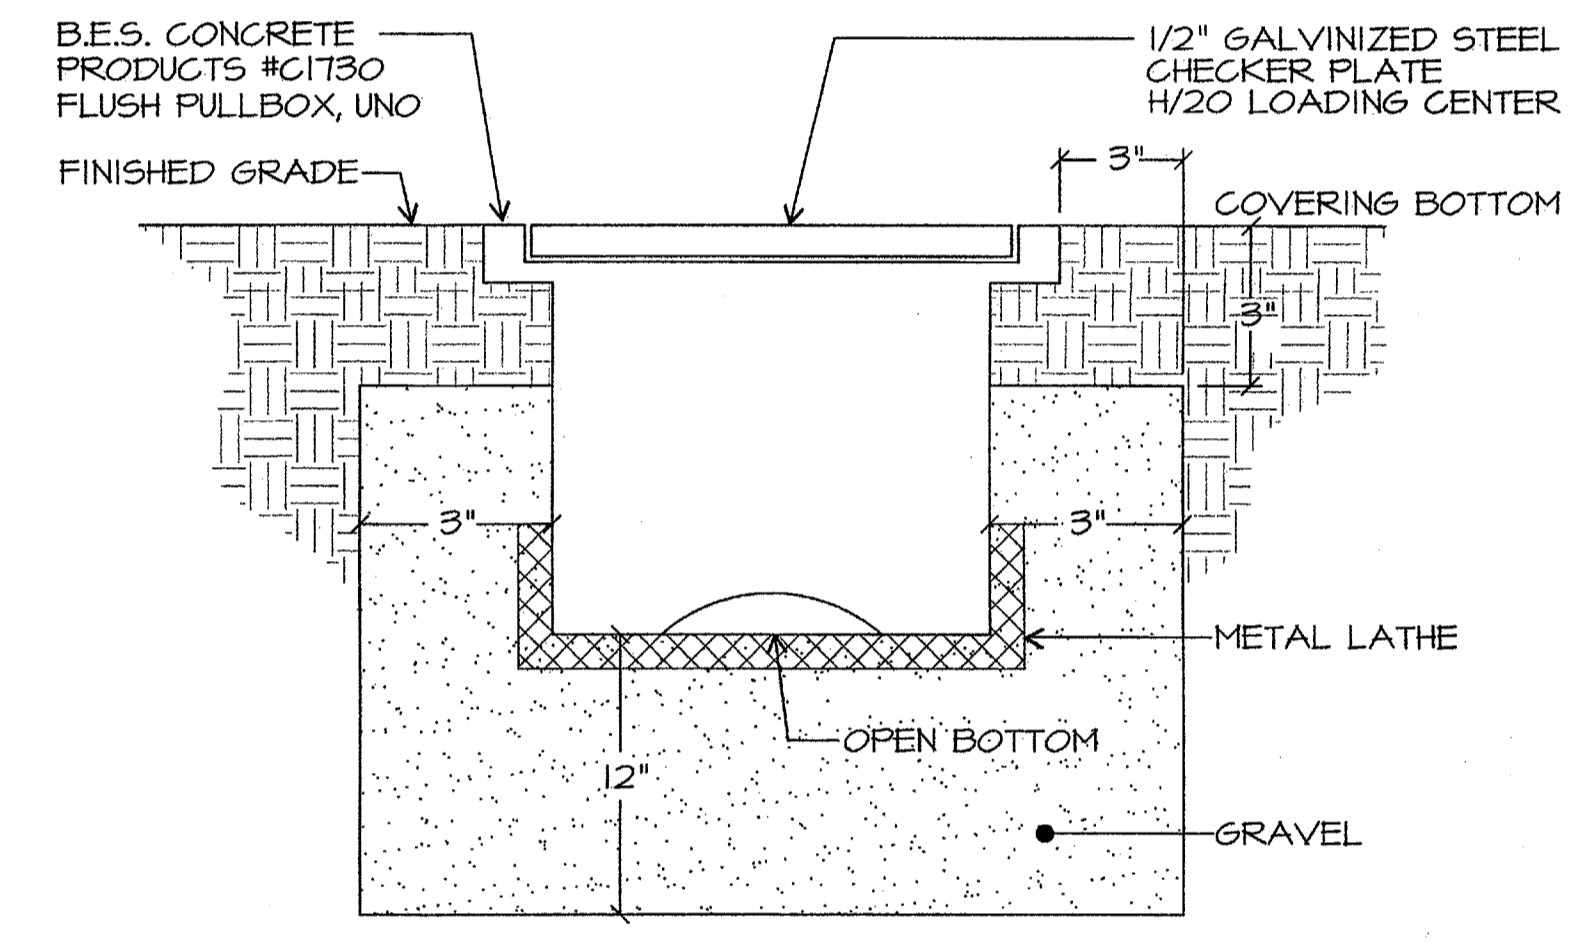


FLUSH PULLBOX DETAIL SCALE: NONE (C)

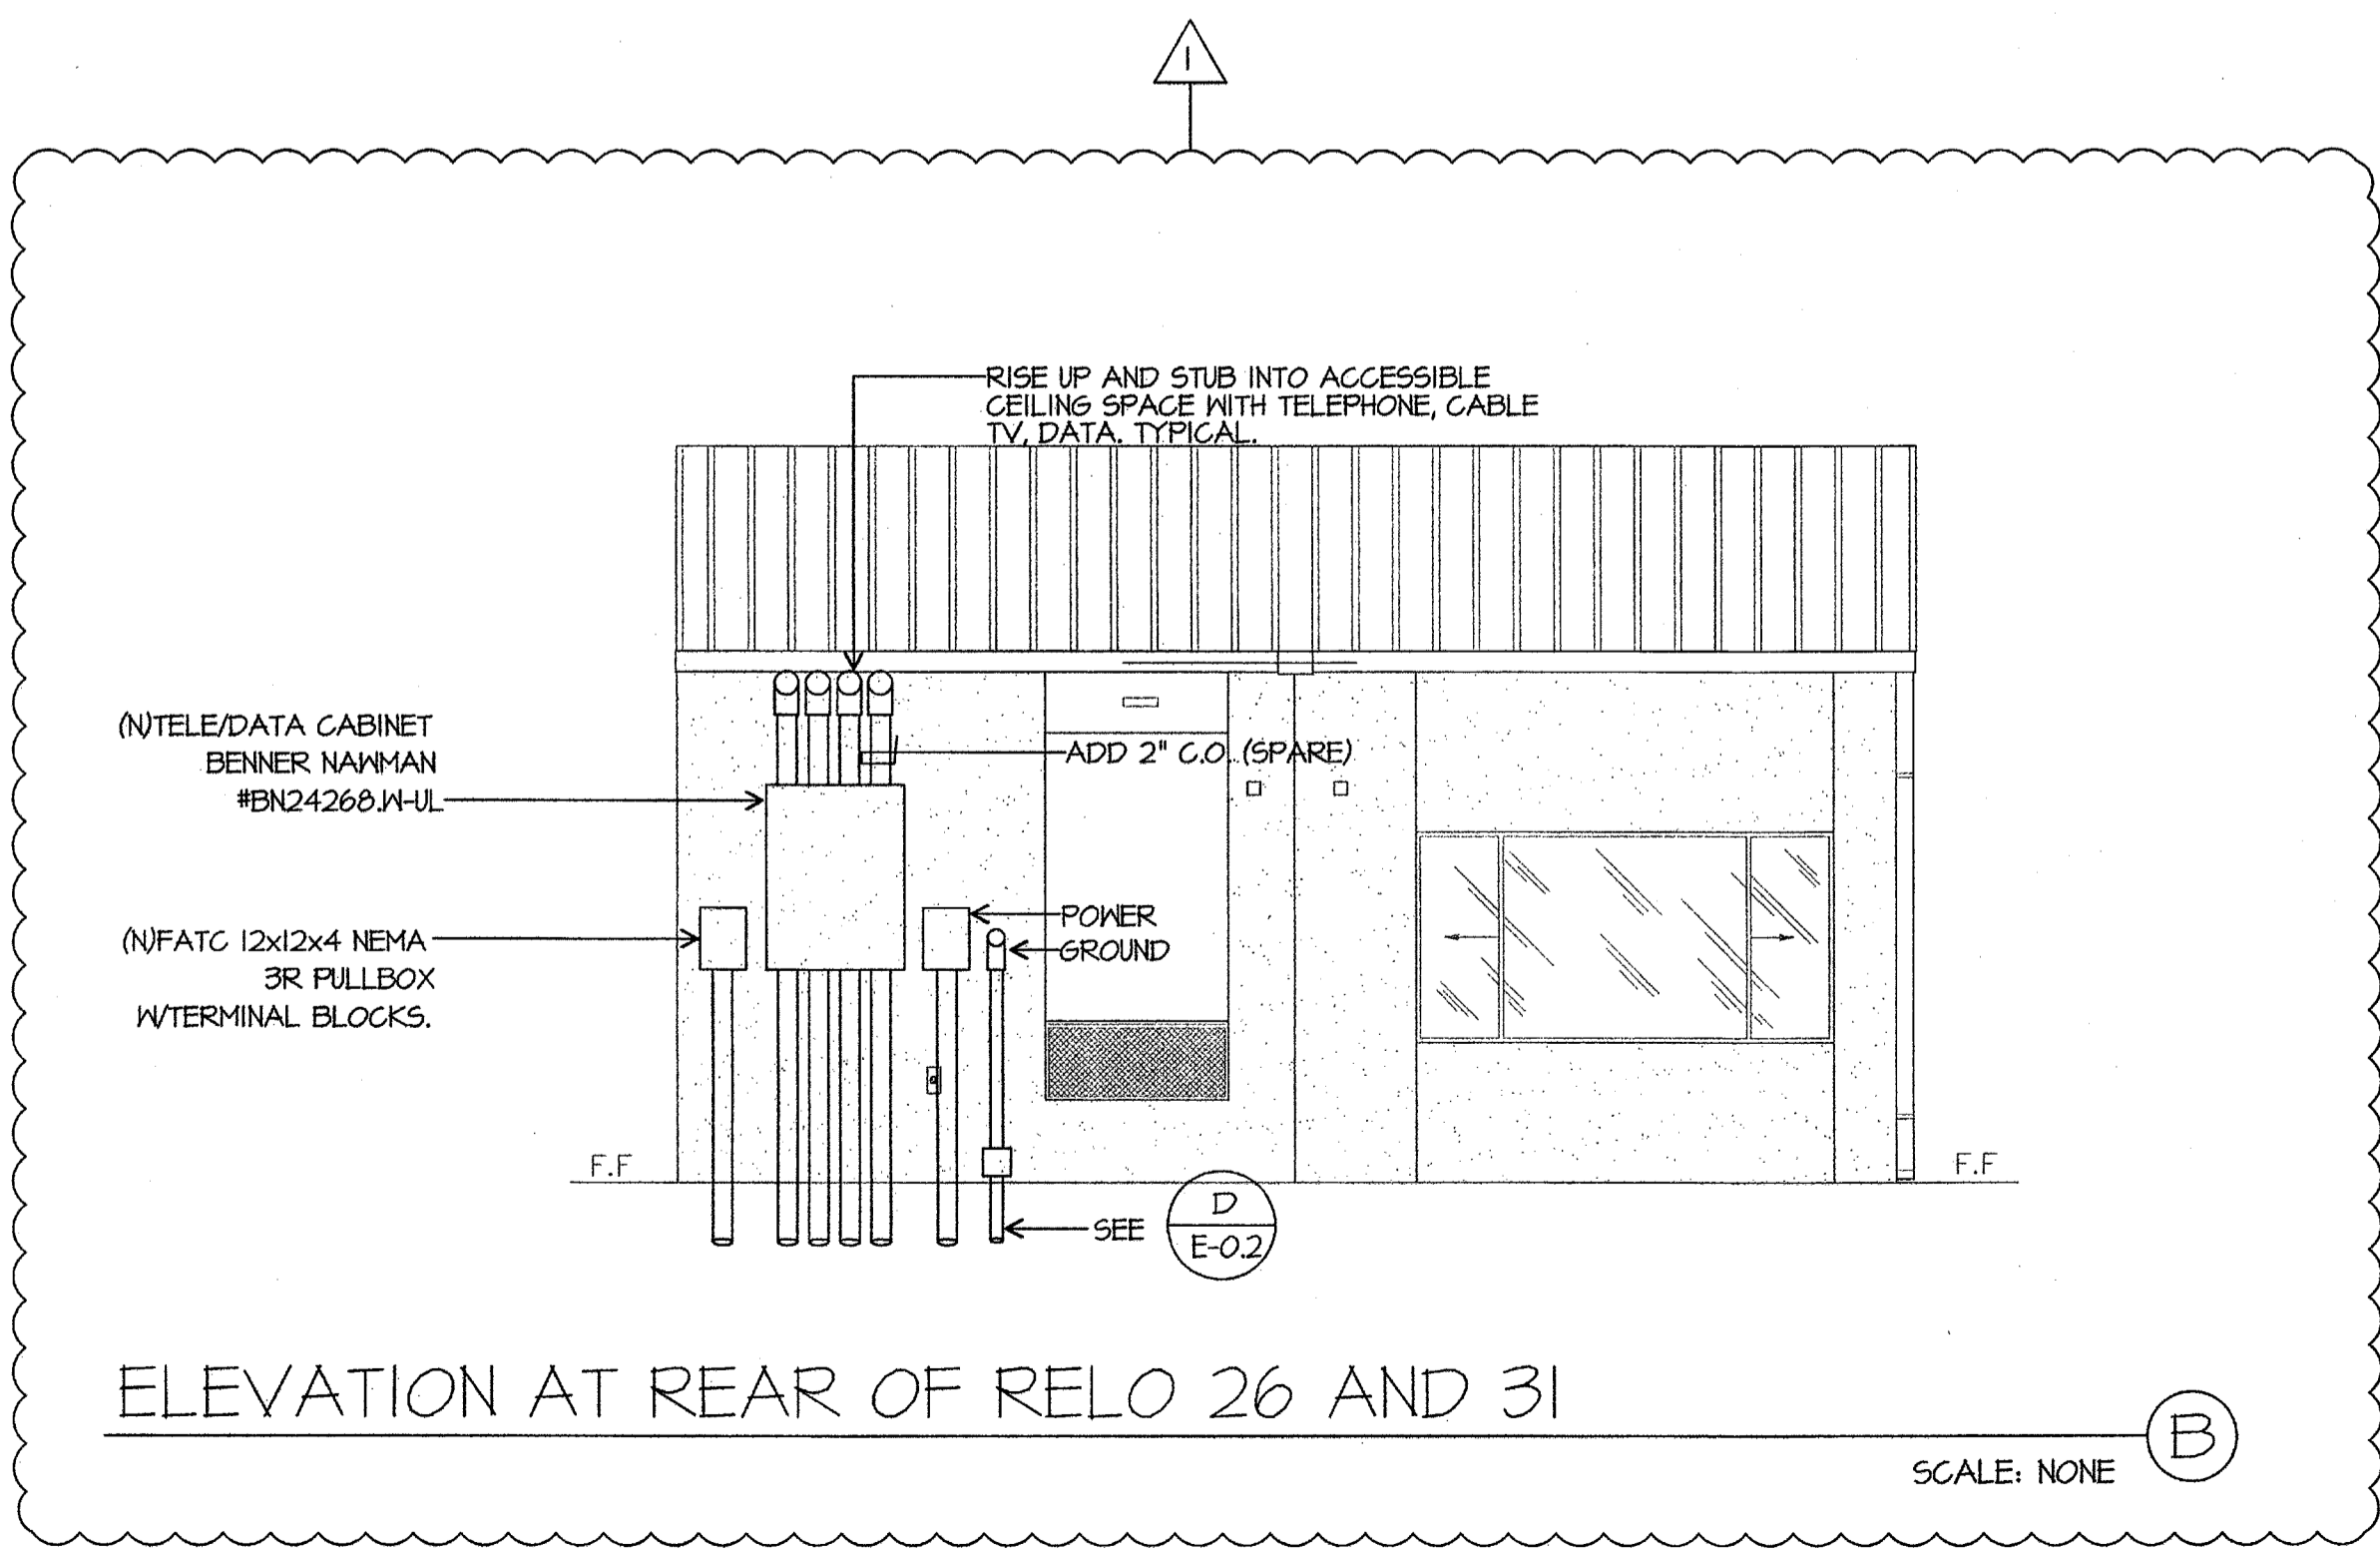

ELEVATION AT REAR OF RELO 26 AND 31 SCALE: NONE (B)

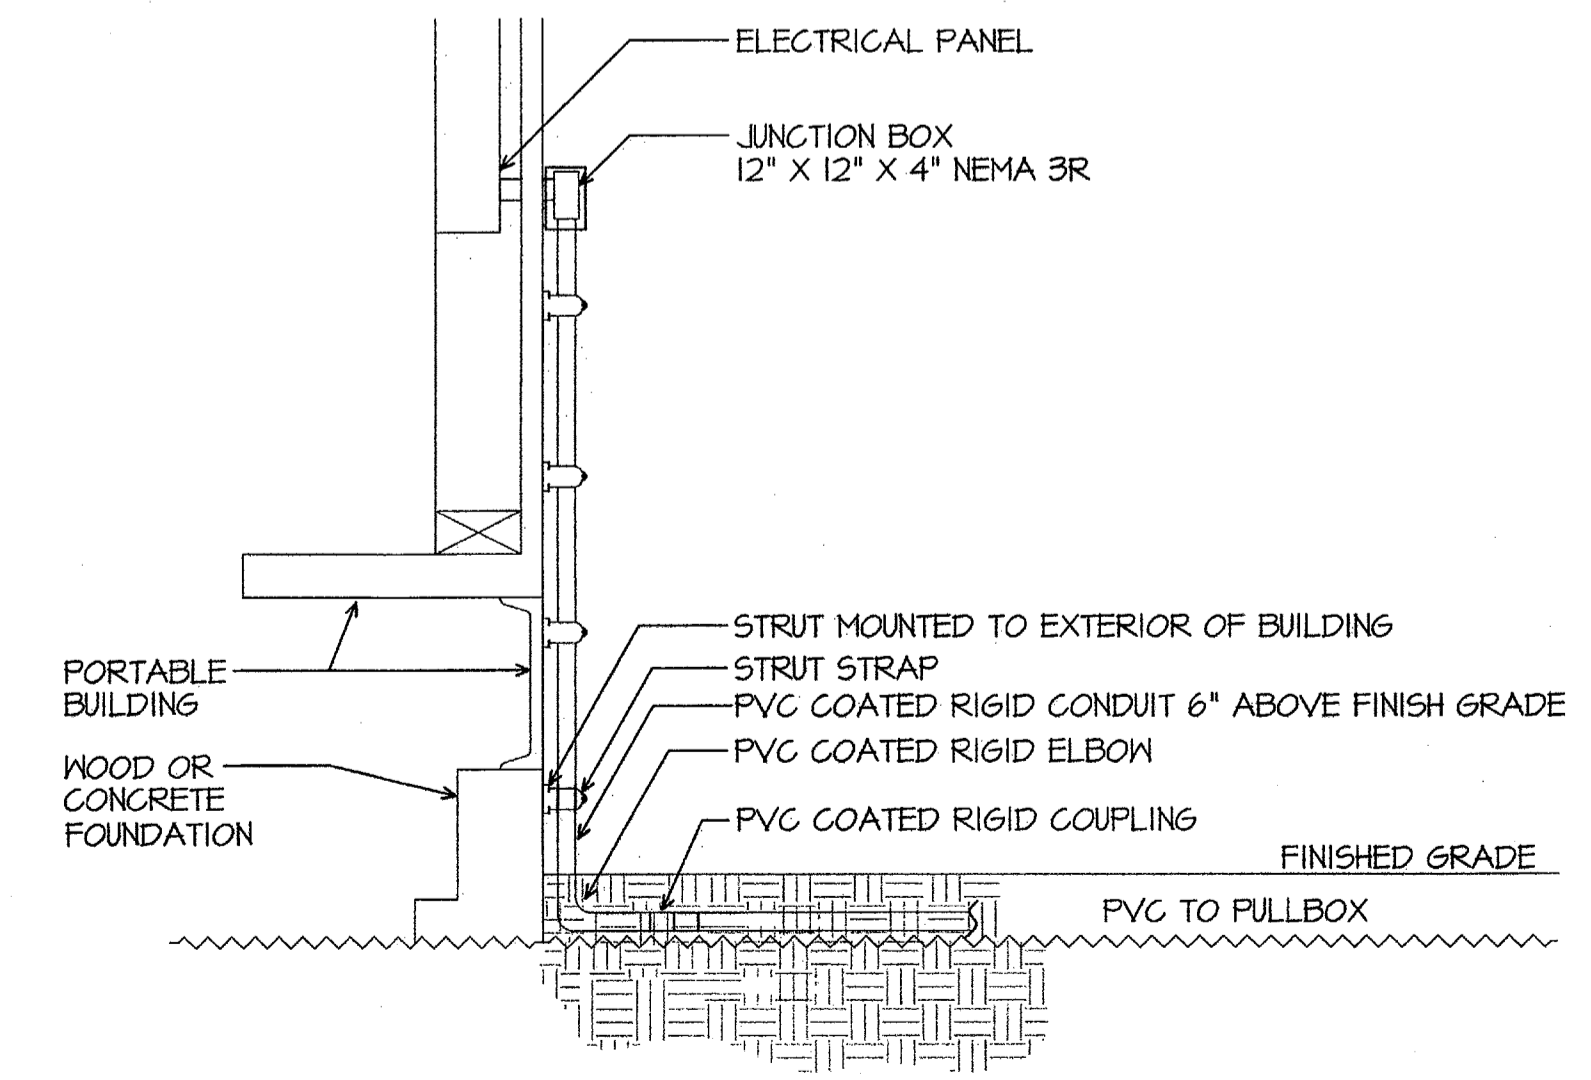

TYPICAL PORTABLE CONNECTION SCALE: NONE (D)

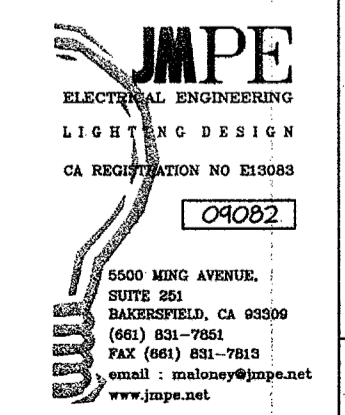

Ownership of Documents
This document, the ideas and designs incorporated herein, as an instrument of Professional Service is the property of Integrated Designs by SOMAM Inc. and is not to be used, in whole or in part for any other project without written authorization. © COPYRIGHT 2009

integrated designs by SOMAM, Inc.
ARCHITECTURE • INTERIOR DESIGN • CONSTRUCTION MANAGEMENT
8011 N. Fresno, Suite 130 - Fresno, California 93710
Phone (559) 438-0881 Fax (559) 438-0887 E-Mail: design@somam.com
www.integrateddesigns.com

Revision	Description	Rev. Date	Rev. Date
1	ADDENDUM 1	10/16/09	



Sheet Title: SINGLE LINE DIAGRAM, SYMBOLS, DETAILS, GENERAL NOTES
Project Name & Address: MUNSEY ELEMENTARY SCHOOL 10 NEW PORTABLE CLASSROOMS BAKERSFIELD CITY SCHOOL DISTRICT 3801 BRAVE AVE, BAKERSFIELD, CA 93309

Issue Date:	Date:	Designer:	DR:	PC:	CJM
	05/02/06				

DSA Identification Stamp:


Stamp(s):

Job No.: 3832
Sheet No.: E-0.2
Release: ADDENDUM #1
CURTIS MCNALLY

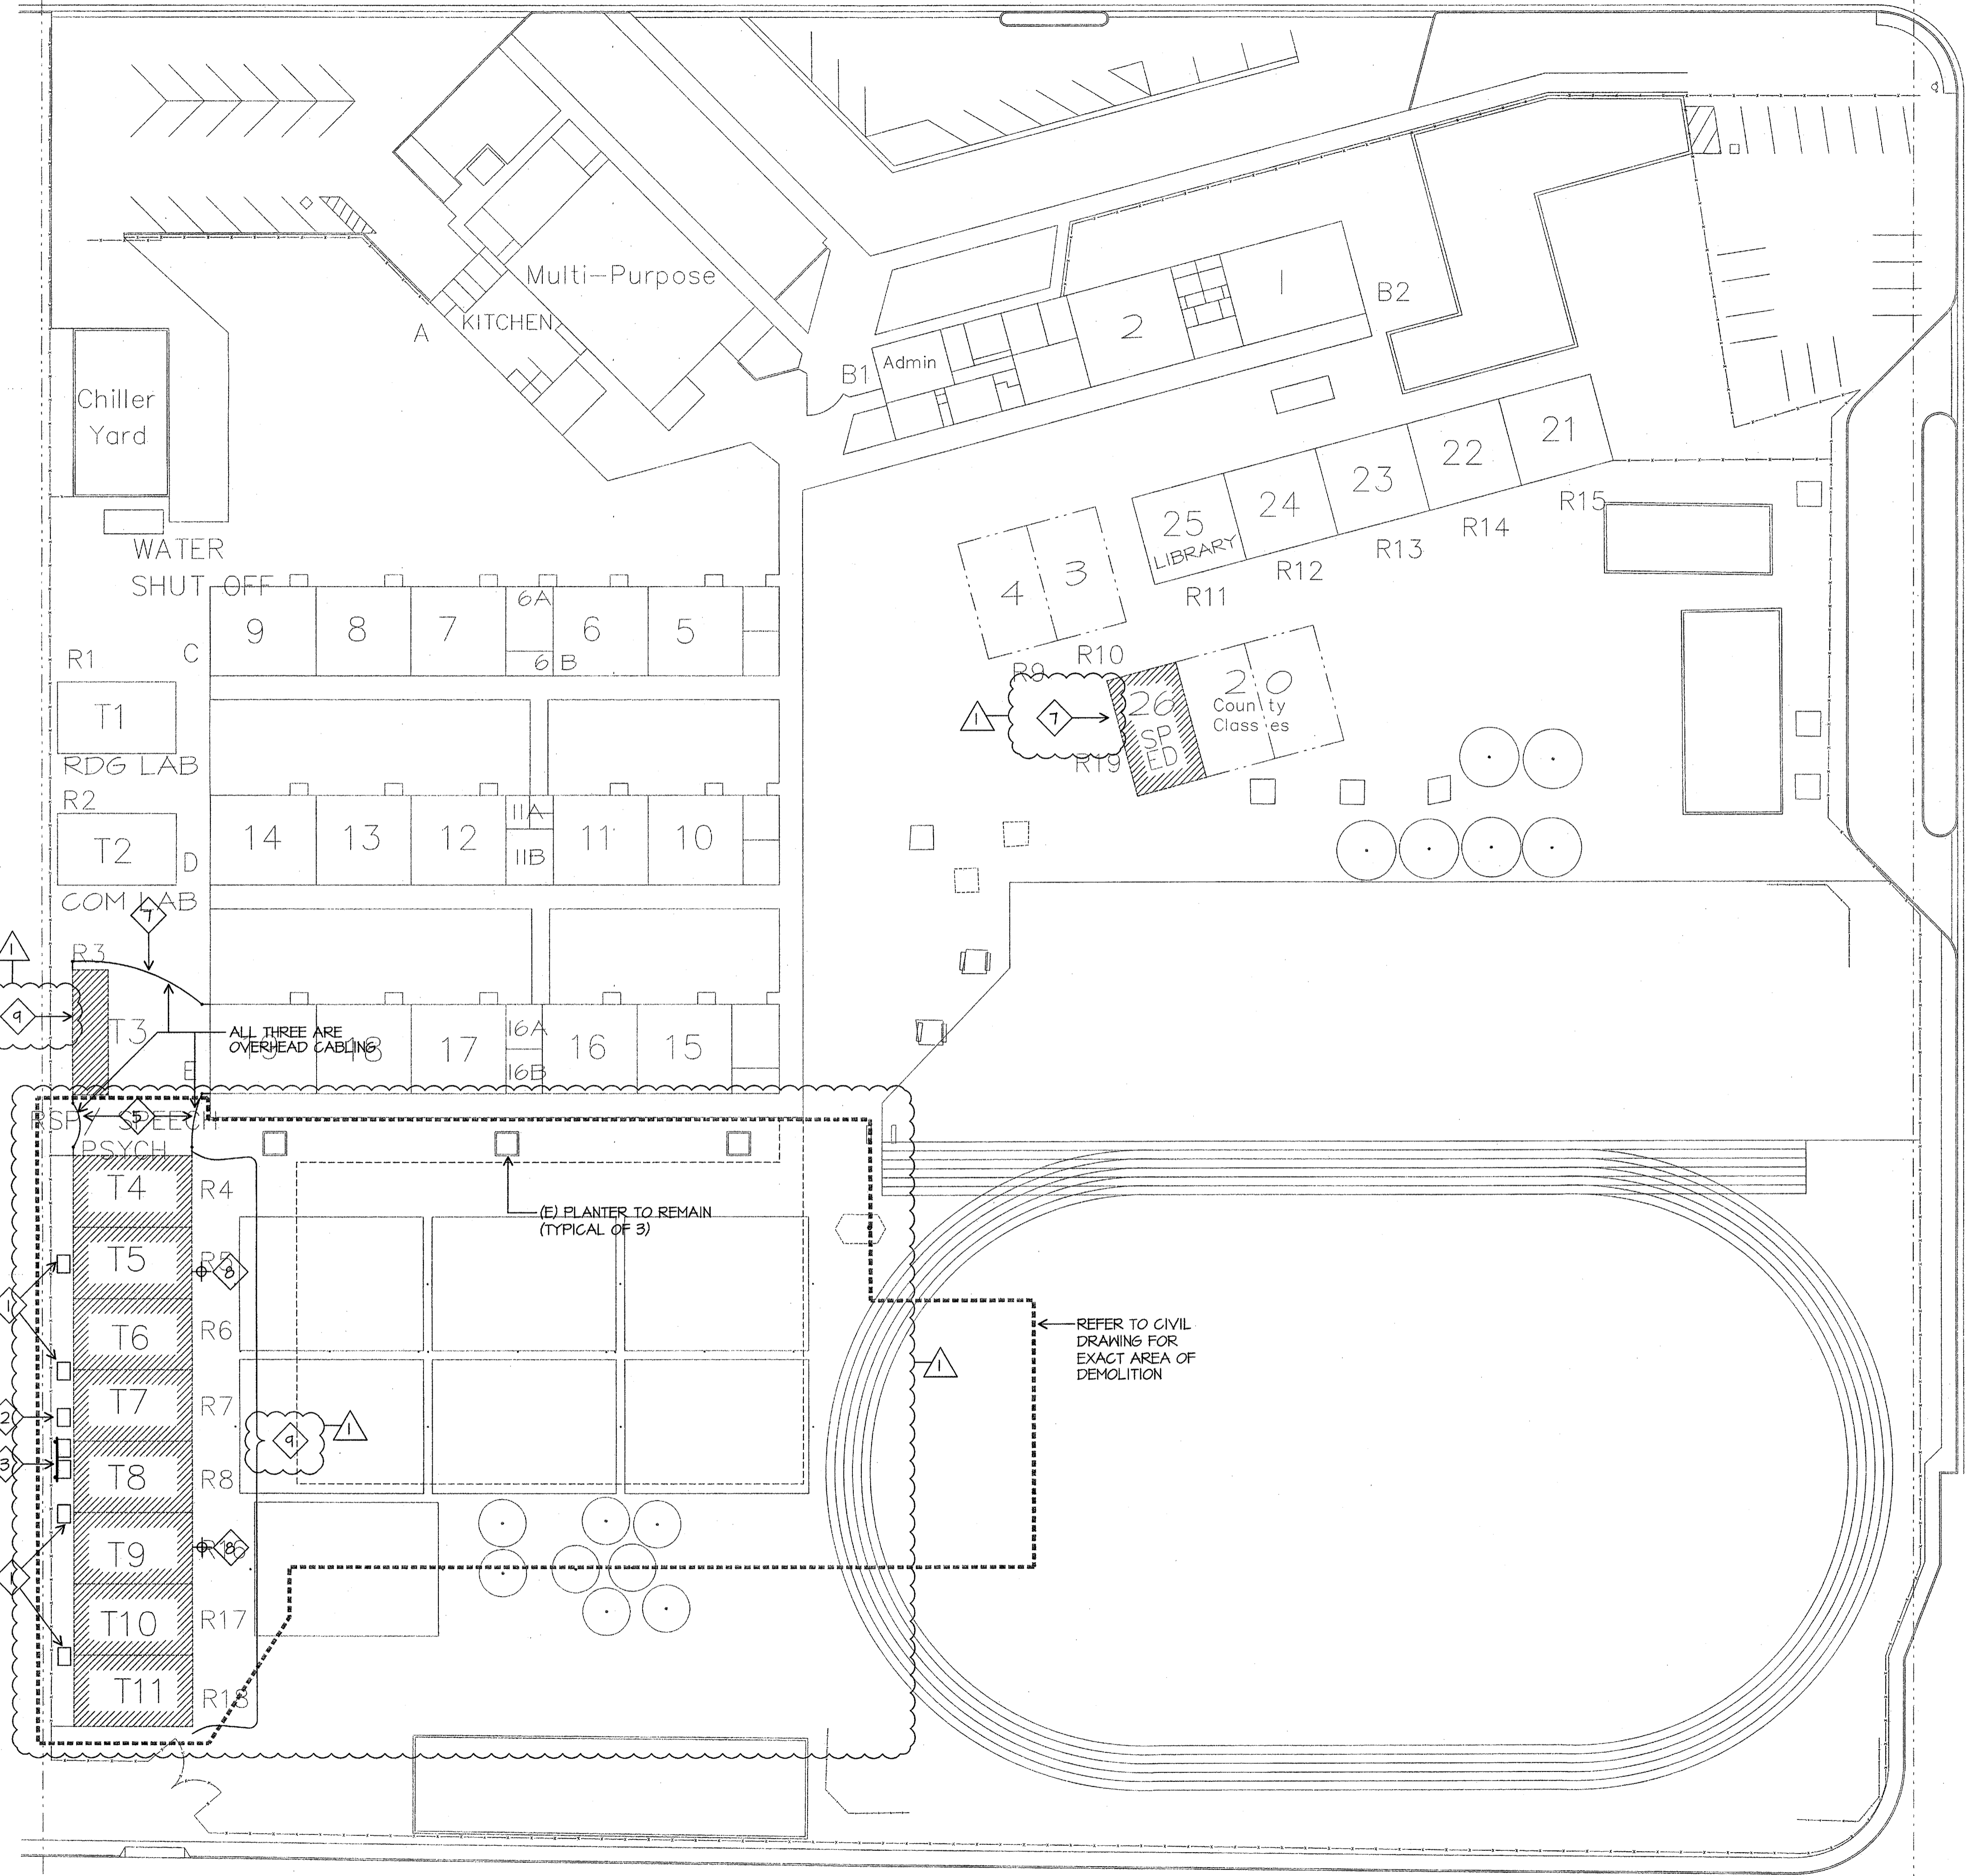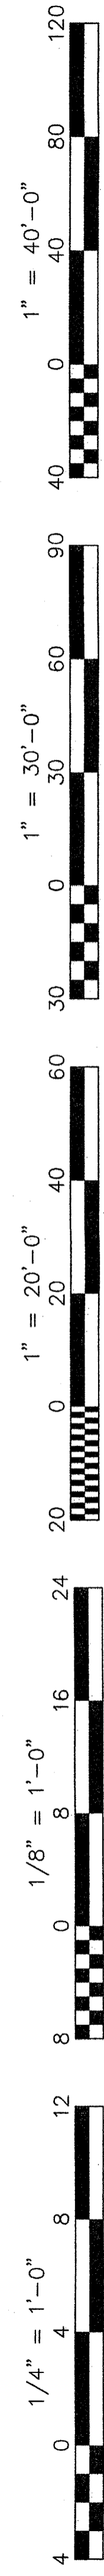

- DEMOLITION SITE ELECTRICAL PLAN NOTES**
- 1 REMOVE EXISTING CONDUCTORS FROM RELOCATED BUILDING PANELS AND CONDUITS BACK TO EXISTING CONCRETE PULL BOX.
 - 2 EXISTING CONCRETE PULL BOX TO REMAIN (N-36 PULL BOX.)
 - 3 DISCONNECT EXISTING FEEDER CONDUCTORS AND REMOVE FROM PANEL TO EXISTING CONCRETE PULL BOX. BACKBOARD AND PANELS TO REMAIN.
 - 4 AFTER PG&E HAS DISCONNECTED SERVICE AND REMOVED EXISTING METER, PROVIDE A BLANK METER SOCKET COVER.
 - 5 REMOVE EXISTING OVERHEAD CABLING FROM T4 TO T3 AND T4 TO ROOM 19. CUT CABLES AT T4 AND T3 AND REMOVE ANY RISER. CUT CABLES AT ROOM 19 AND WEATHER PROOF THE CABLE ENDS.
 - 6 REMOVE EXISTING ABOVE GROUND 12 X 12 X 4 NEMA 3R J-BOXES AND UNISTRUT SUPPORTS COMPLETELY. INSTALL (N) N-9 CONCRETE PULL BOXES OVER (E) CONDUITS. SET BOXES FLUSH TO EXISTING GRADE (TYPICAL).
 - 7 REMOVE EXISTING OVERHEAD SERVICE CONDUCTORS FROM T-3 BACK TO ROOM 19. REMOVE AT RISER ON ROOM 19 AND WEATHER PROOF THE CONDUCTOR ENDS. REMOVE RISER FROM PANEL ON T-3.
 - 8 REMOVE EXISTING RISER SUPPORTS AND EXTERIOR FLOOD LIGHTS.
 - 9 EXISTING BUILDING TO REMAIN UNTIL NEW BUILDINGS ARE COMPLETED.

DEMOLITION SITE ELECTRICAL PLAN

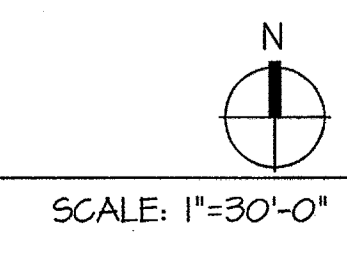

JMPE
 ELECTRICAL ENGINEERING
 LIGHTING DESIGN
 CA REGISTRATION NO. 813093
 5000 MENO AVENUE, SUITE 202, BAKERSFIELD, CA 93309
 TEL: (805) 833-7000 FAX: (805) 833-7915
 WWW: www.jmpe.net

Professional Engineer
 CURTIS MCNALLY
 LICENSED PROFESSIONAL ENGINEER
 ELECTRICAL
 STATE OF CALIFORNIA

Ownership of Documents
 This document, the ideas and designs incorporated herein, as an instrument of Professional Service is the property of Integrated Designs by SOMAM Inc. and is not to be used, in whole or in part for any other project without written authorization.
 © COPYRIGHT 2009

integrated designs by SOMAM, Inc.
 ARCHITECTURE • INTERIOR DESIGN • CONSTRUCTION MANAGEMENT
 6011 N. Fresno, Suite 130 - Fresno, California 93710
 Phone (509) 436-0881 Fax (509) 436-0887 E-mail: design@somam.com
 www.integrateddesigns.com

Revision:	ADDENDUM 1	Rev. Date:	10/15/09
Revision Description:		Revision:	
Revision:		Revision Description:	

DEMOLITION SITE ELECTRICAL PLAN

Issue Date: 05/02/06
 Date: 05/02/06
 Designer: DESIGNER
 DR: DRAFTER
 PC: C.J.M.

Project Name & Address:
MUNSEY ELEMENTARY SCHOOL
10 NEW PORTABLE CLASSROOMS
 BAKERSFIELD CITY SCHOOL DISTRICT
 3801 BRAVE AVE. BAKERSFIELD, CA 93309

DSA Identification Stamp:



Stamp(s):

Job No.: **3832**

Sheet No.: **E-1**

Release: **ADDENDUM #1**
 CURTIS MCNALLY

JMPE/JOB#:04082/DATE:10-15-09 AC

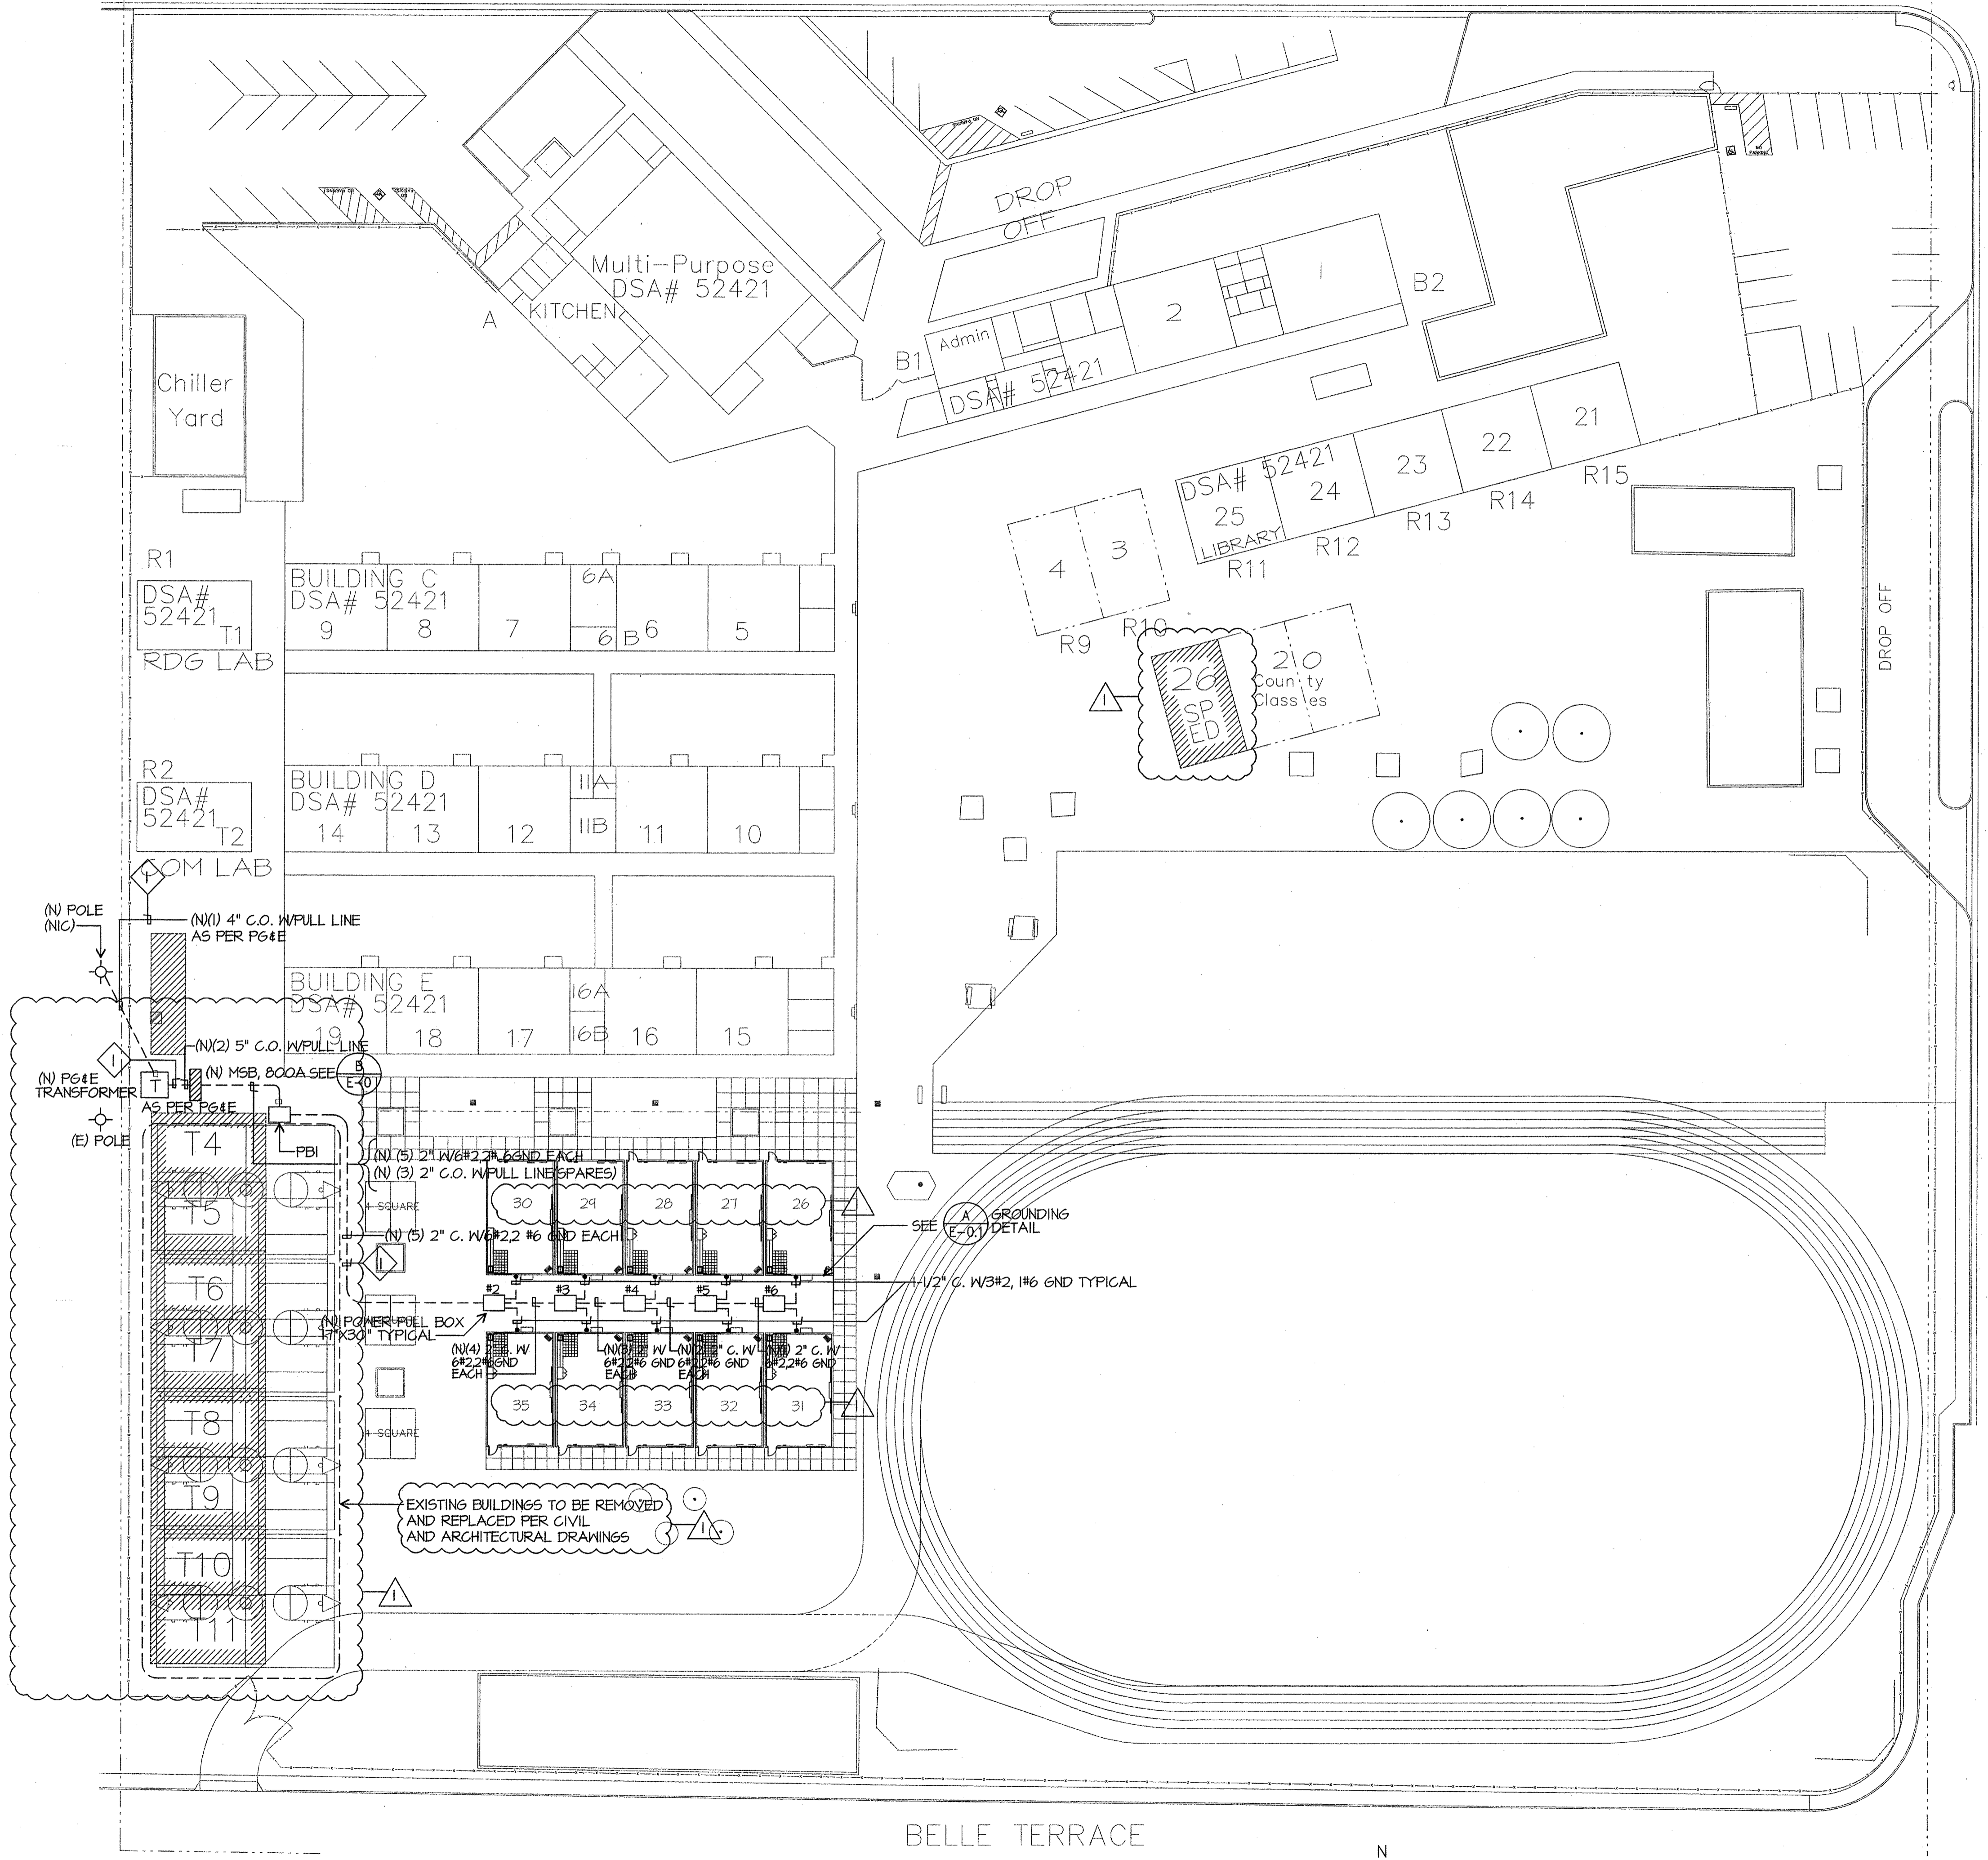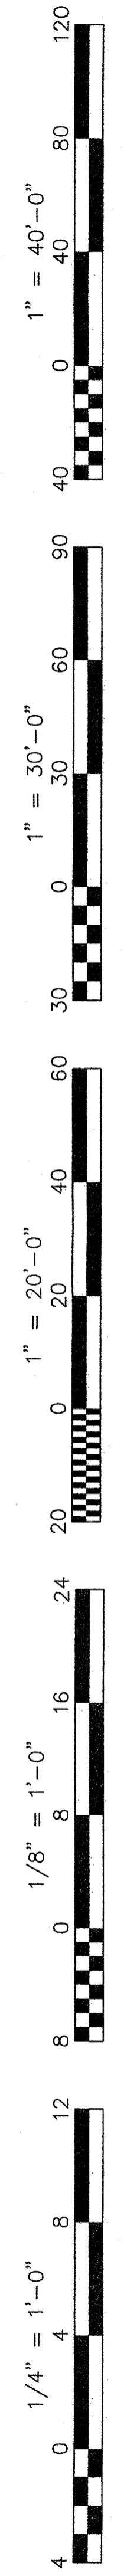


ELECTRICAL SITE PLAN NOTES

1 SAWCUT AND REPAIR TO MATCH EXISTING. BORING IS AN ACCEPTABLE METHOD OF CONDUIT INSTALLATION. PROVIDE METHOD OF PROCEDURE FOR BORING TO ENGINEER FOR REVIEW AND APPROVAL. DETAIL BORING PROCEDURE. IDENTIFY TYPE OF CONDUIT TO BE USED IN BORE.

SITE ELECTRICAL PLAN

SCALE: 1"=30'-0"

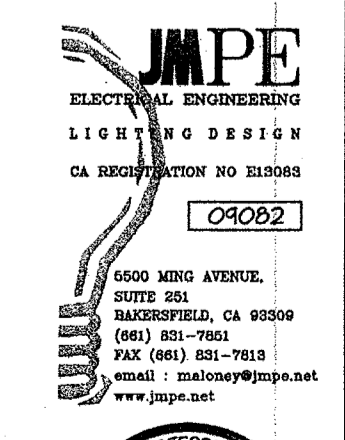

Ownership of Documents
This document, the ideas and designs incorporated herein, as an instrument of Professional Service is the property of Integrated Designs by SOMAM Inc. and is not to be used, in whole or in part for any other project without written authorization.
© COPYRIGHT 2009

integrated designs by SOMAM, Inc.
ARCHITECTURE • ENGINEERING • INTERIOR DESIGN • CONSTRUCTION MANAGEMENT
6011 N. Fresno, Suite 130 - Fresno, California 93710
Phone (559) 436-0881 Fax (559) 436-0881 E-Mail: design@somam.com
www.integrateddesigns.com



Sheet Title: **SITE ELECTRICAL PLAN**
Project Name & Address: **MUNSEY ELEMENTARY SCHOOLS**
10 NEW PORTABLE CLASSROOMS
BAKERSFIELD CITY SCHOOL DISTRICT
3801 BRAVE AVE. BAKERSFIELD, CA 93309

Issue Date:	Date:	05/02/06
Designer:	DR:	CJM
Drafter:	PC:	

DSA Identification Stamp:


Stamp(s):

Job No.: **3832**
Sheet No.: **E-1.1**
Release: **APPENDUM 1**
Curtis McNally

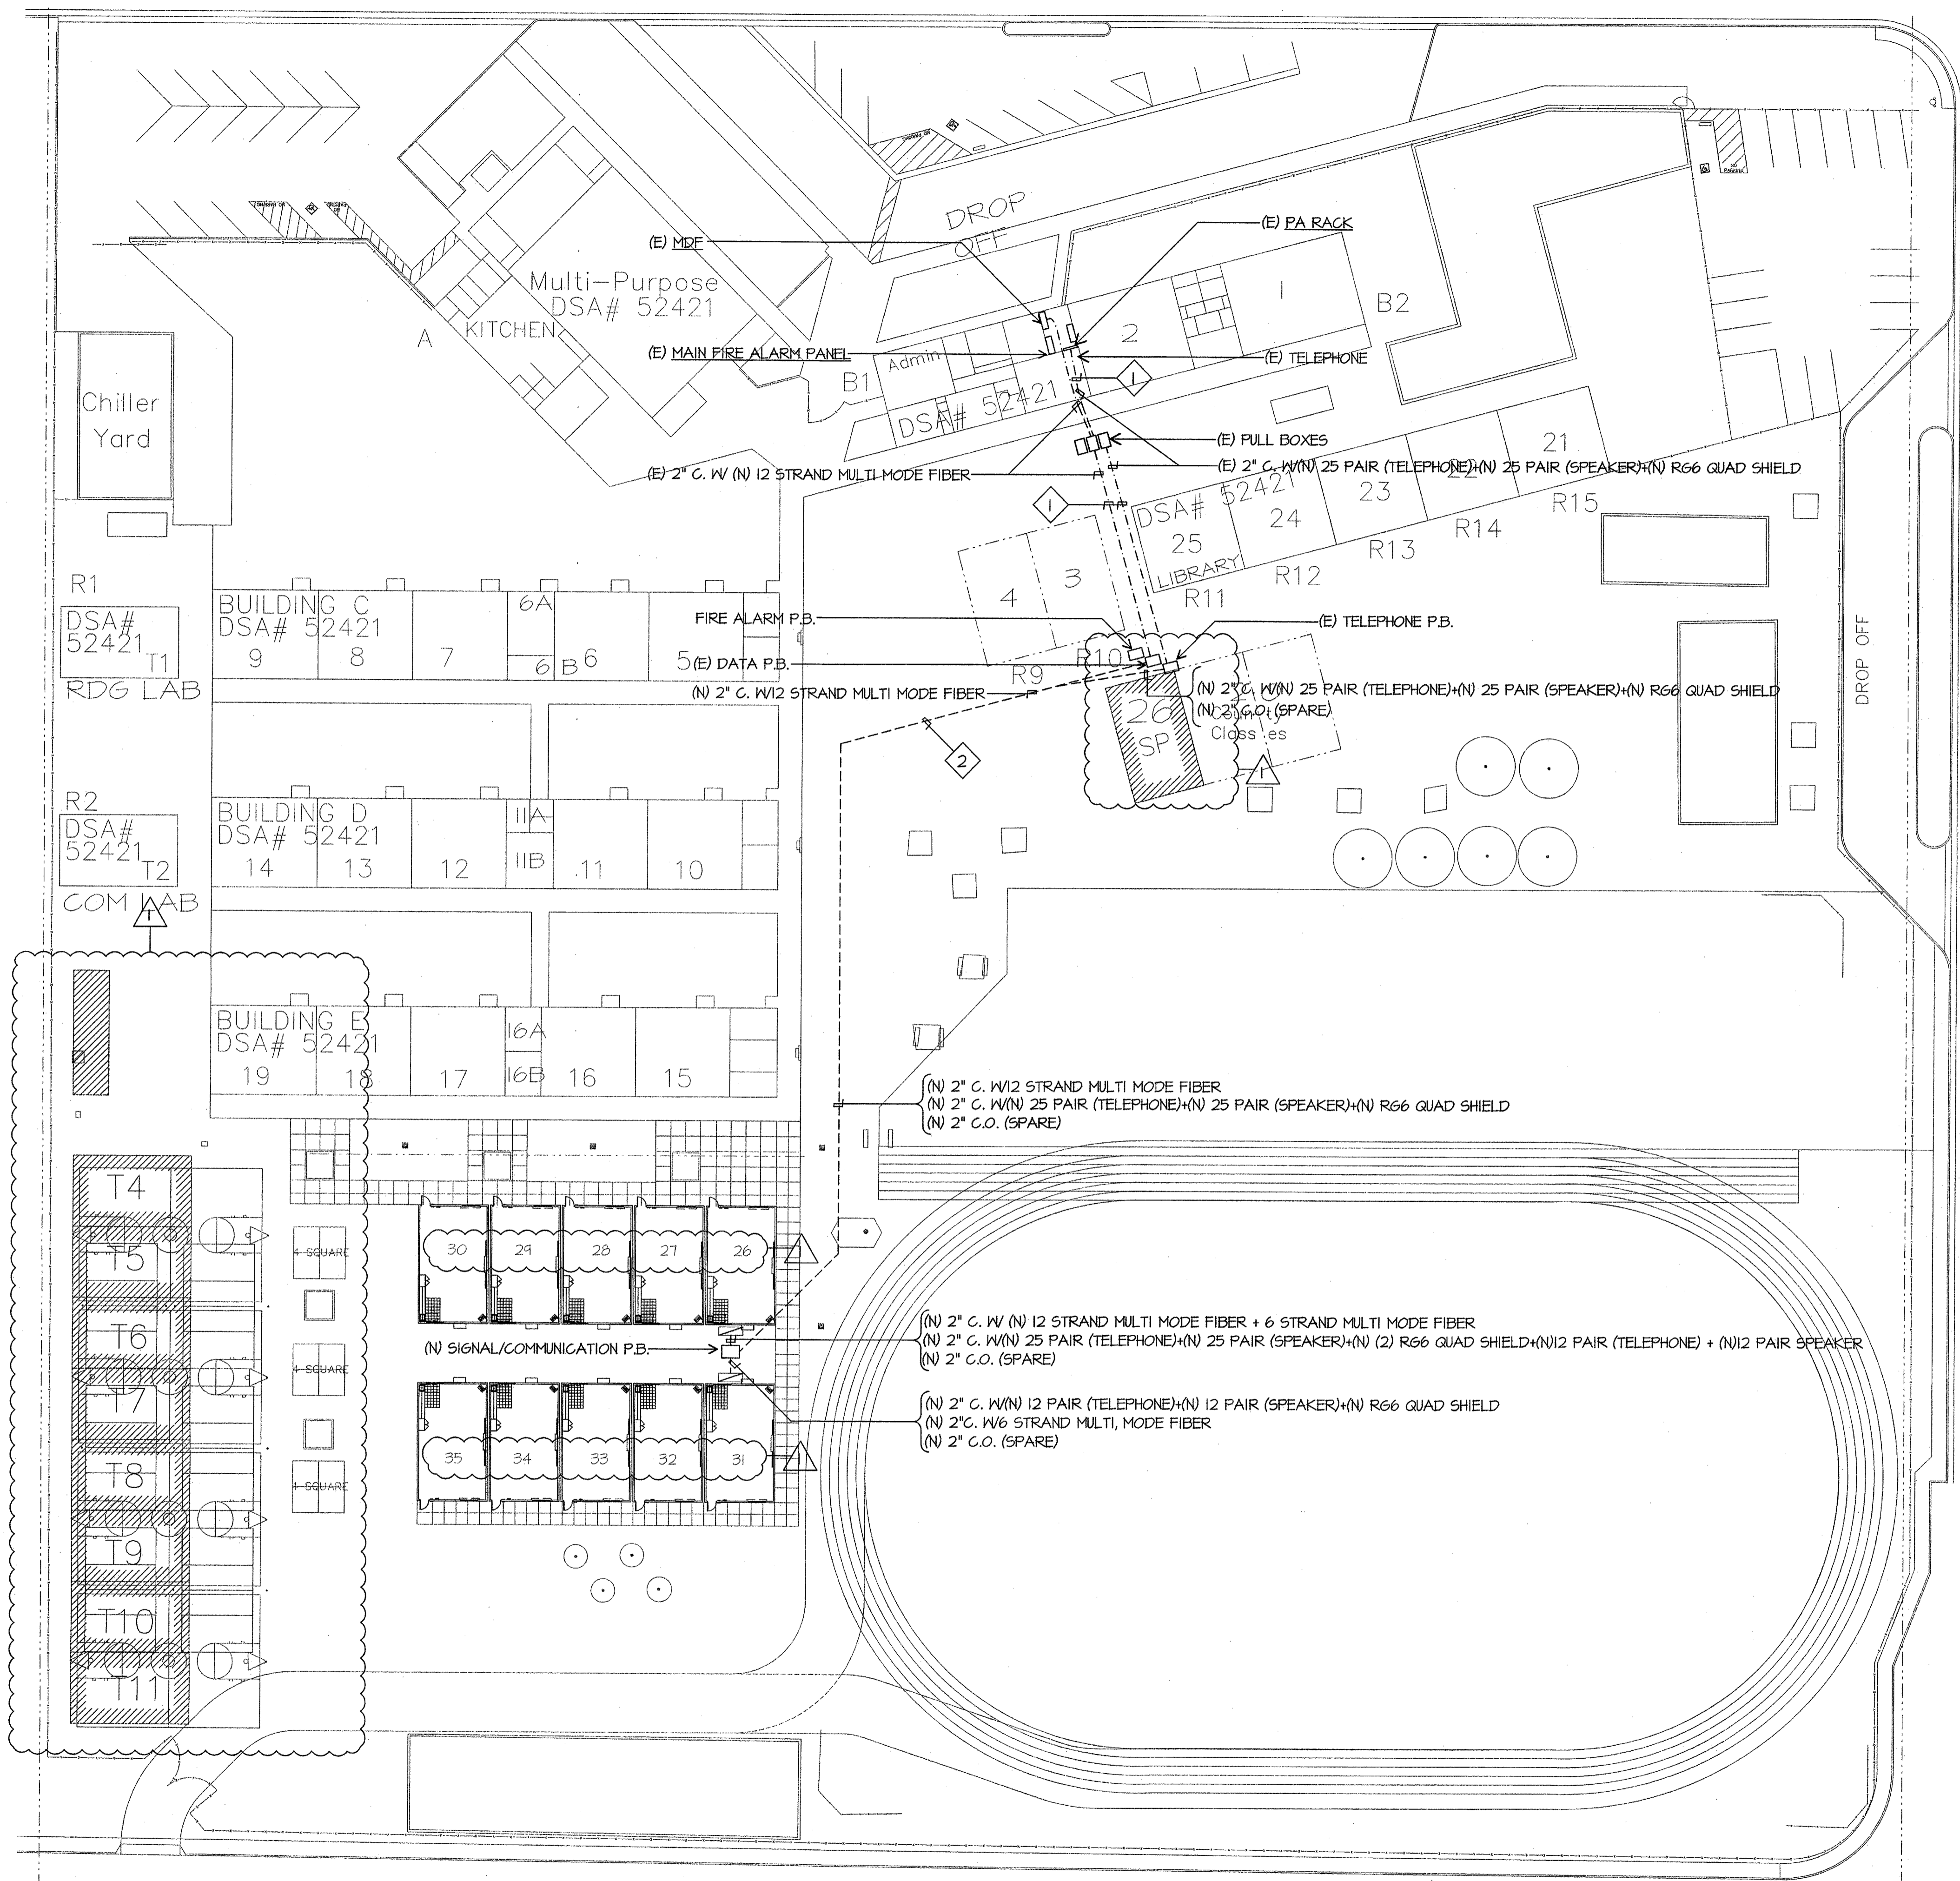
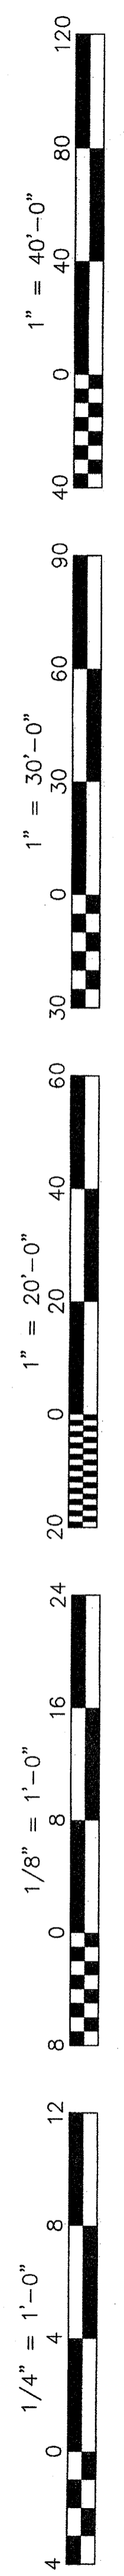


- SITE COMMUNICATION PLAN NOTES**
- 1 PULL NEW CABLES IN EXISTING CONDUIT. PULL PAST EXISTING CABLES.
 - 2 SAWCUT AND REPAIR TO MATCH EXISTING. BORING IS AN ACCEPTABLE METHOD OF CONDUIT INSTALLATION. PROVIDE METHOD OF PROCEDURE FOR BORING TO ENGINEER FOR REVIEW AND APPROVAL. DETAIL BORING PROCEDURE. IDENTIFY TYPE OF CONDUIT TO BE USED IN BORE.

SITE COMMUNICATION PLAN

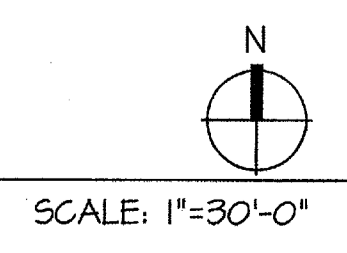

JMPE
 ELECTRICAL ENGINEERING
 LIGHTING DESIGN
 CA REGISTRATION NO. E12085
 04082
 3400 MING AVENUE
 SUITE 200
 BAKERSFIELD, CA 93309
 (805) 835-7165
 FAX (805) 835-7163
 email: info@jmpe.net
 www.jmpe.net

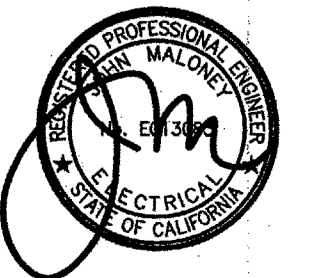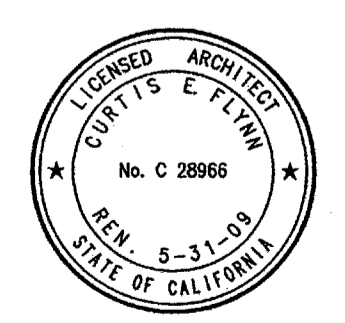

Job No.: **3832**

Sheet No.: **E-2**

Release: **APPENDUM 1**

Ownership of Documents
 This document, the ideas and designs incorporated herein, as an instrument of Professional Service is the property of Integrated Designs by SOMAM Inc. and is not to be used, in whole or in part for any other project without written authorization.
 © COPYRIGHT 2009

integrated designs by SOMAM, Inc.
 ARCHITECTURE - ENGINEERING - INTERIOR DESIGN - CONSTRUCTION MANAGEMENT
 6011 N. Fresno, Suite 130 - Fresno, California 93710
 Phone: (509) 438-0881 Fax: (509) 438-0887 E-Mail: design@somam.com
 www.integrateddesigns.com

Rev. No.	Date	Description
1	10/15/09	ADDENDUM 1

SITE COMMUNICATION PLAN

Project Name & Address:
MUNSEY ELEMENTARY SCHOOL
10 NEW PORTABLE CLASSROOMS
 BAKERSFIELD CITY SCHOOL DISTRICT
 3801 BRAVE AVE. BAKERSFIELD, CA 93309

Issue Date: 05/02/06
 Designer: DESIGNER
 DR: DRAFTER
 PC: CJM

DSA Identification Stamp: