


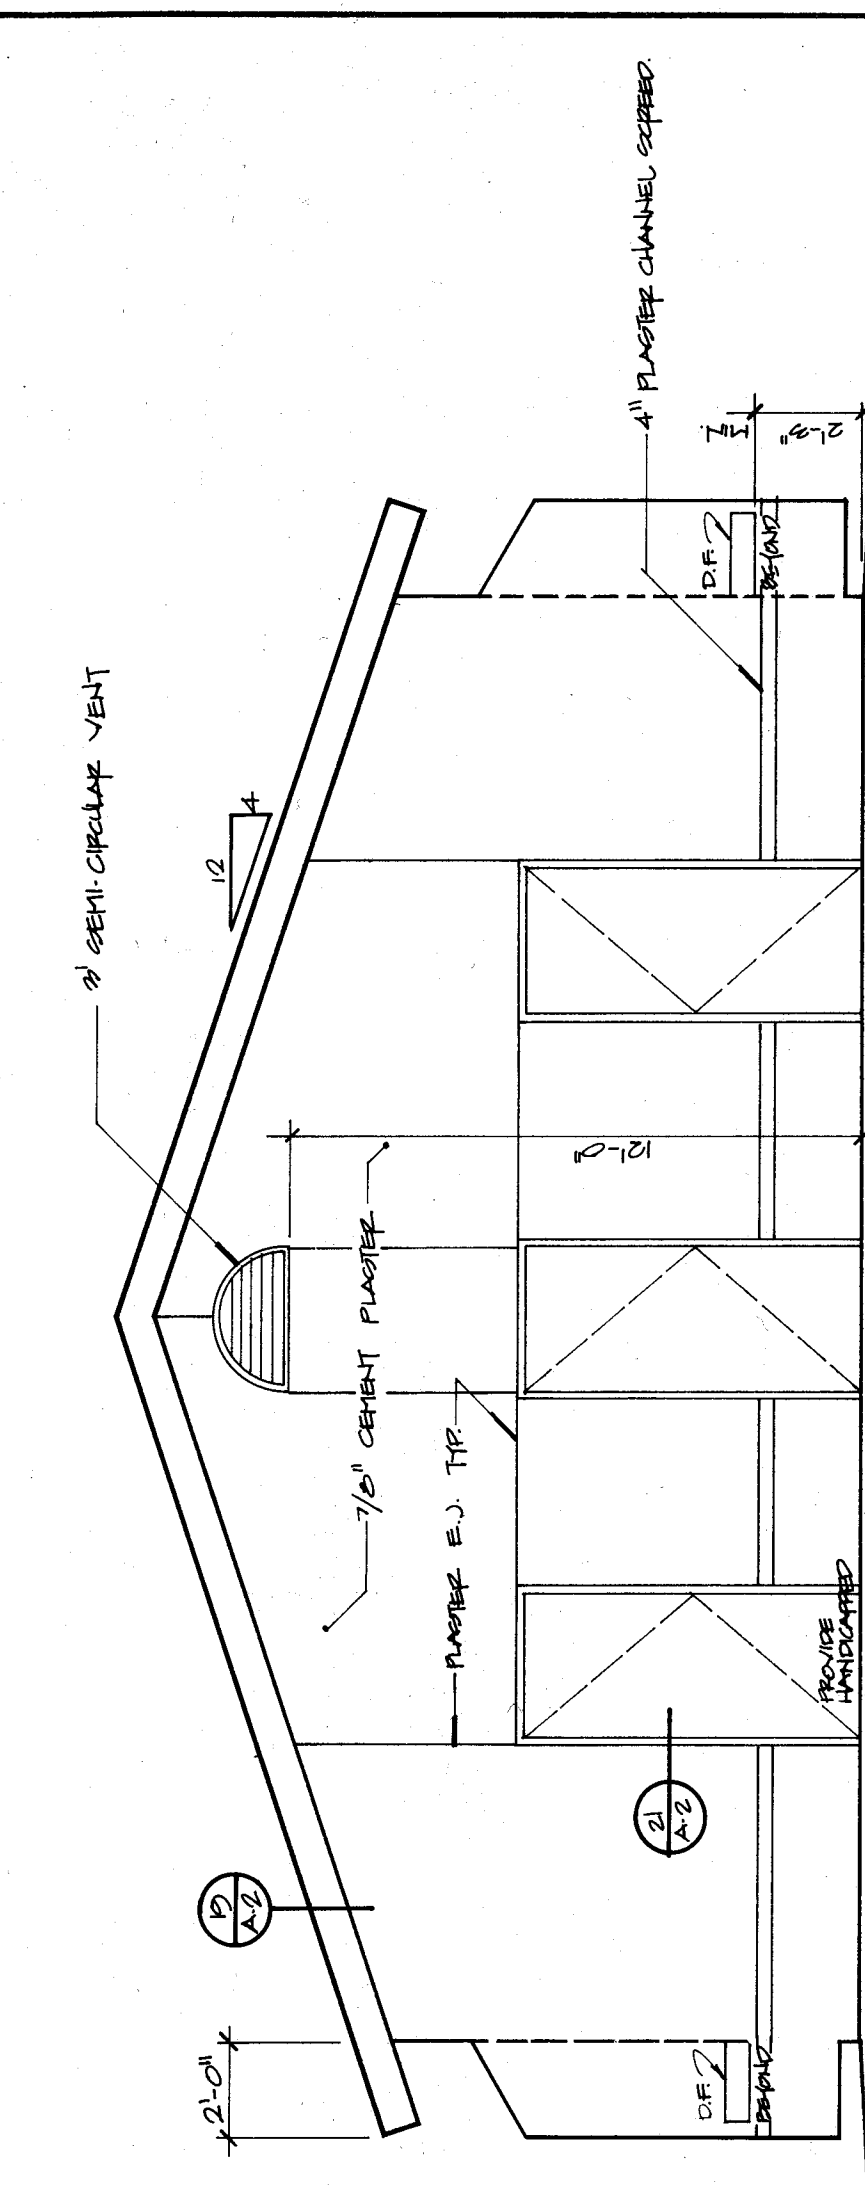


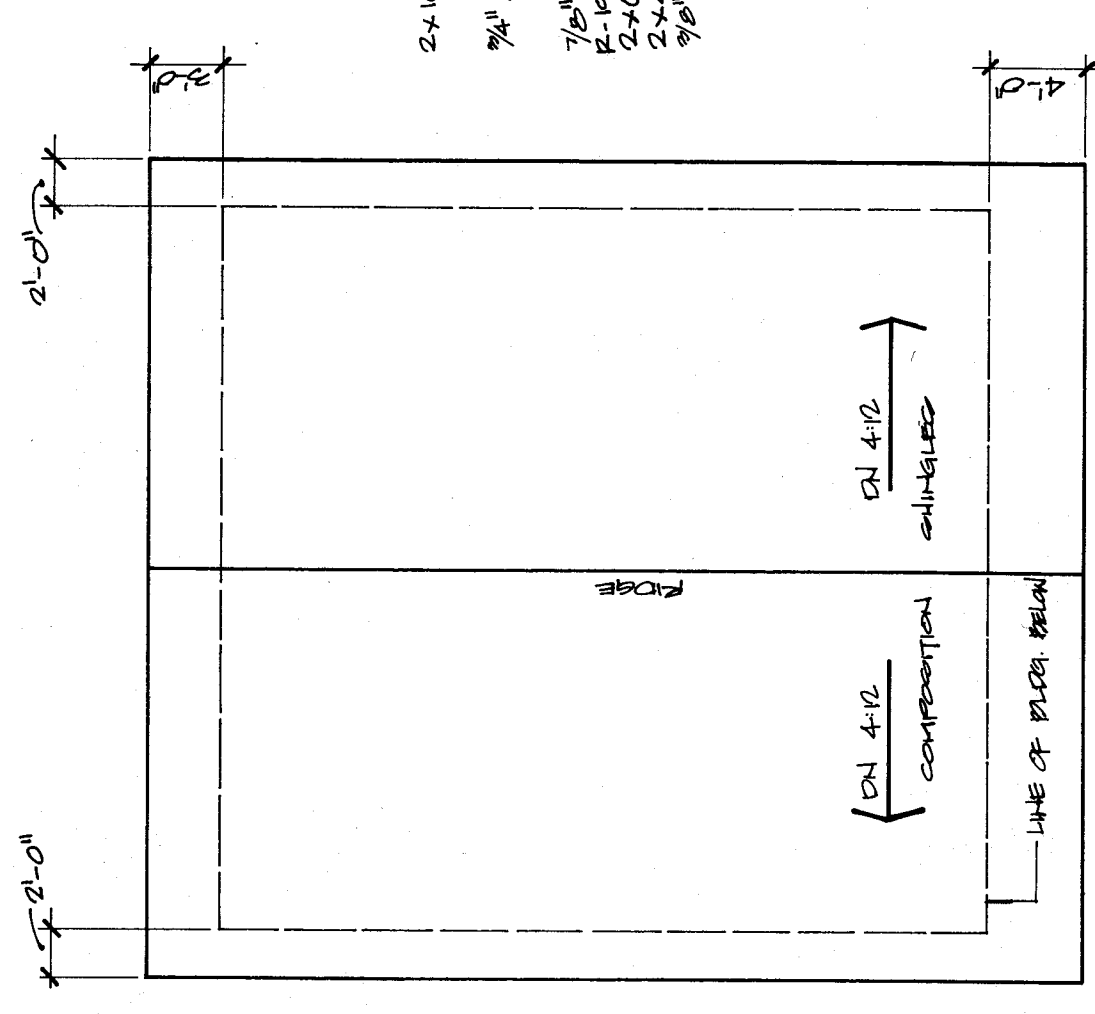

scale: 1/4" = 1'-0"

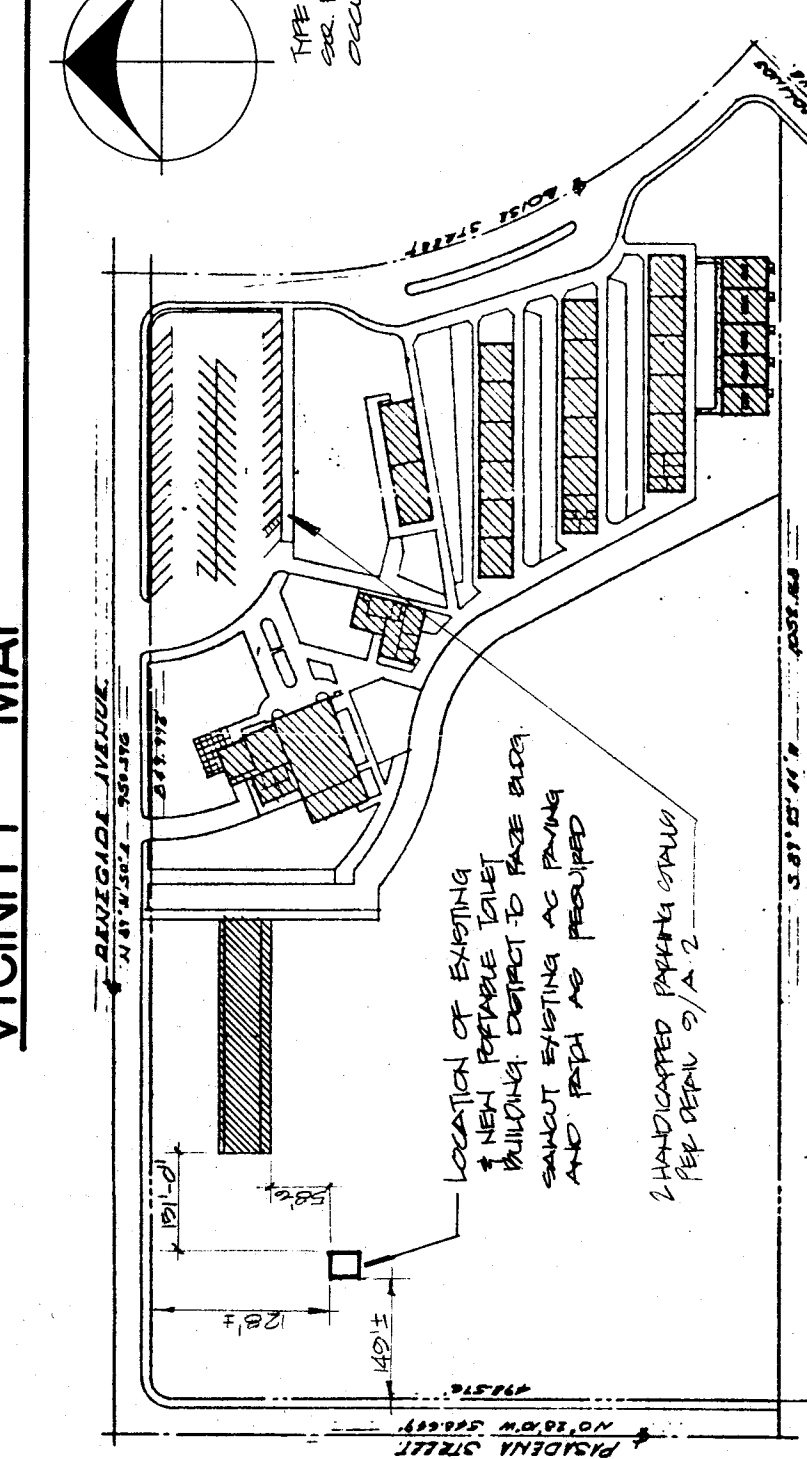

Technical drawing of a staircase section showing four steps. The drawing includes dimensions: a total width of 1000, a tread width of 250, and a riser height of 150. The steps are labeled "STAIRCASE" and "CORNER".

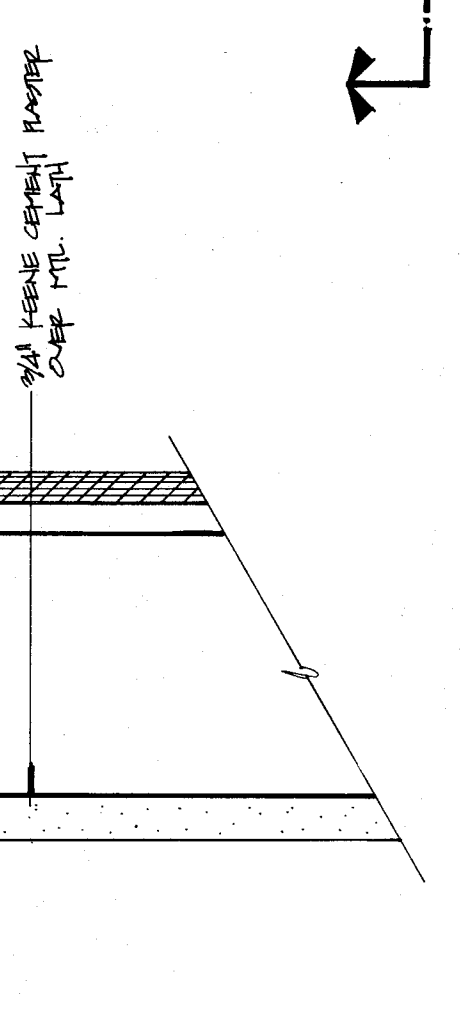


100


SITE PLAN scale: 1" = 200'

SHEET INDEX	
A-1	FIRST FLOOR PLAN, ROOF PLAN, SECTION, ELEVATION + INTERIOR ELEVATIONS, VENITY PLAN
A-2	EXTERIOR/INTERIOR SCENARIOS, DETAILS
B-1	FOUNDATION PLAN, SECTIONS, DETAILS, ROOF RAINWATER PLAN ETC.
ME-1	MECHANICAL + ELECTRICAL PLAN, ROOF RAIN

FLOOR PLAN scale: 1/4" = 1'-0"

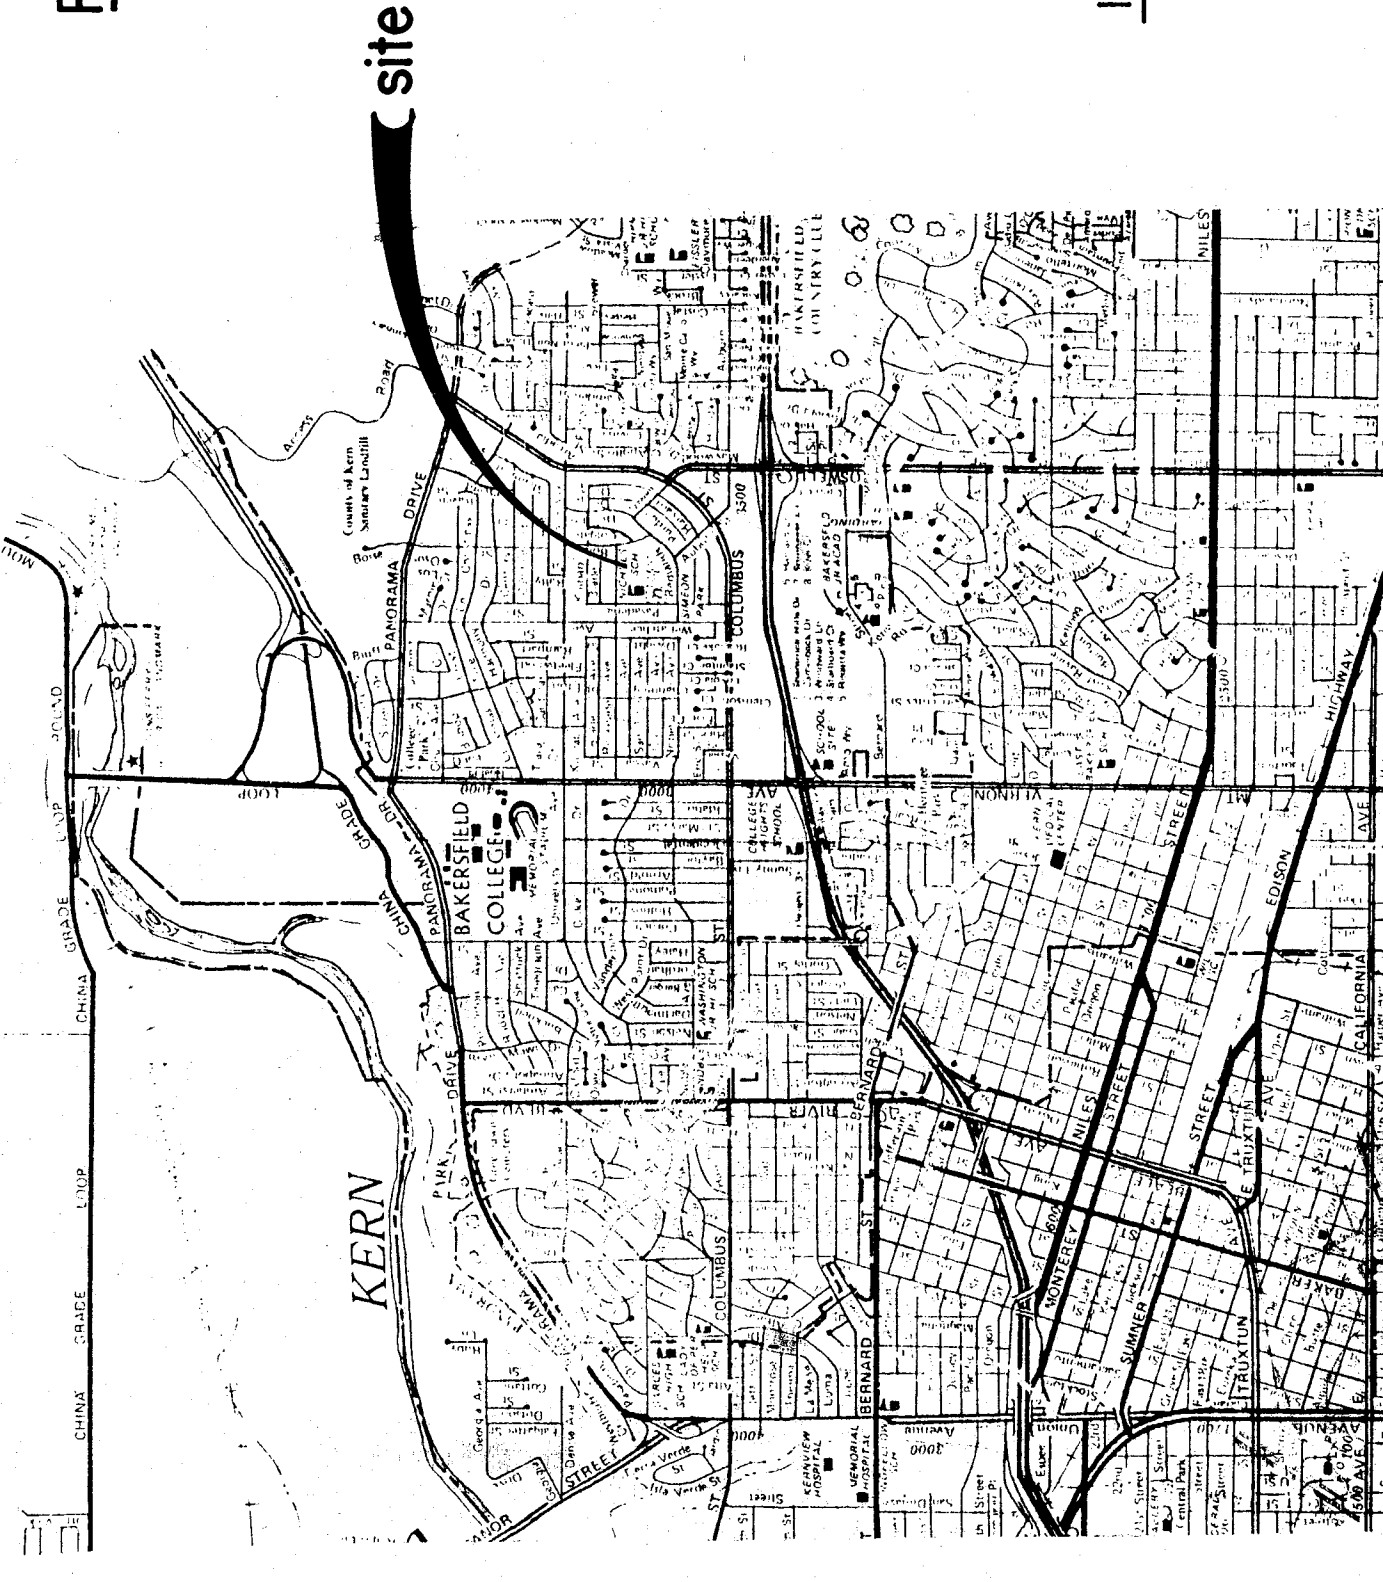

VICINITY MAP

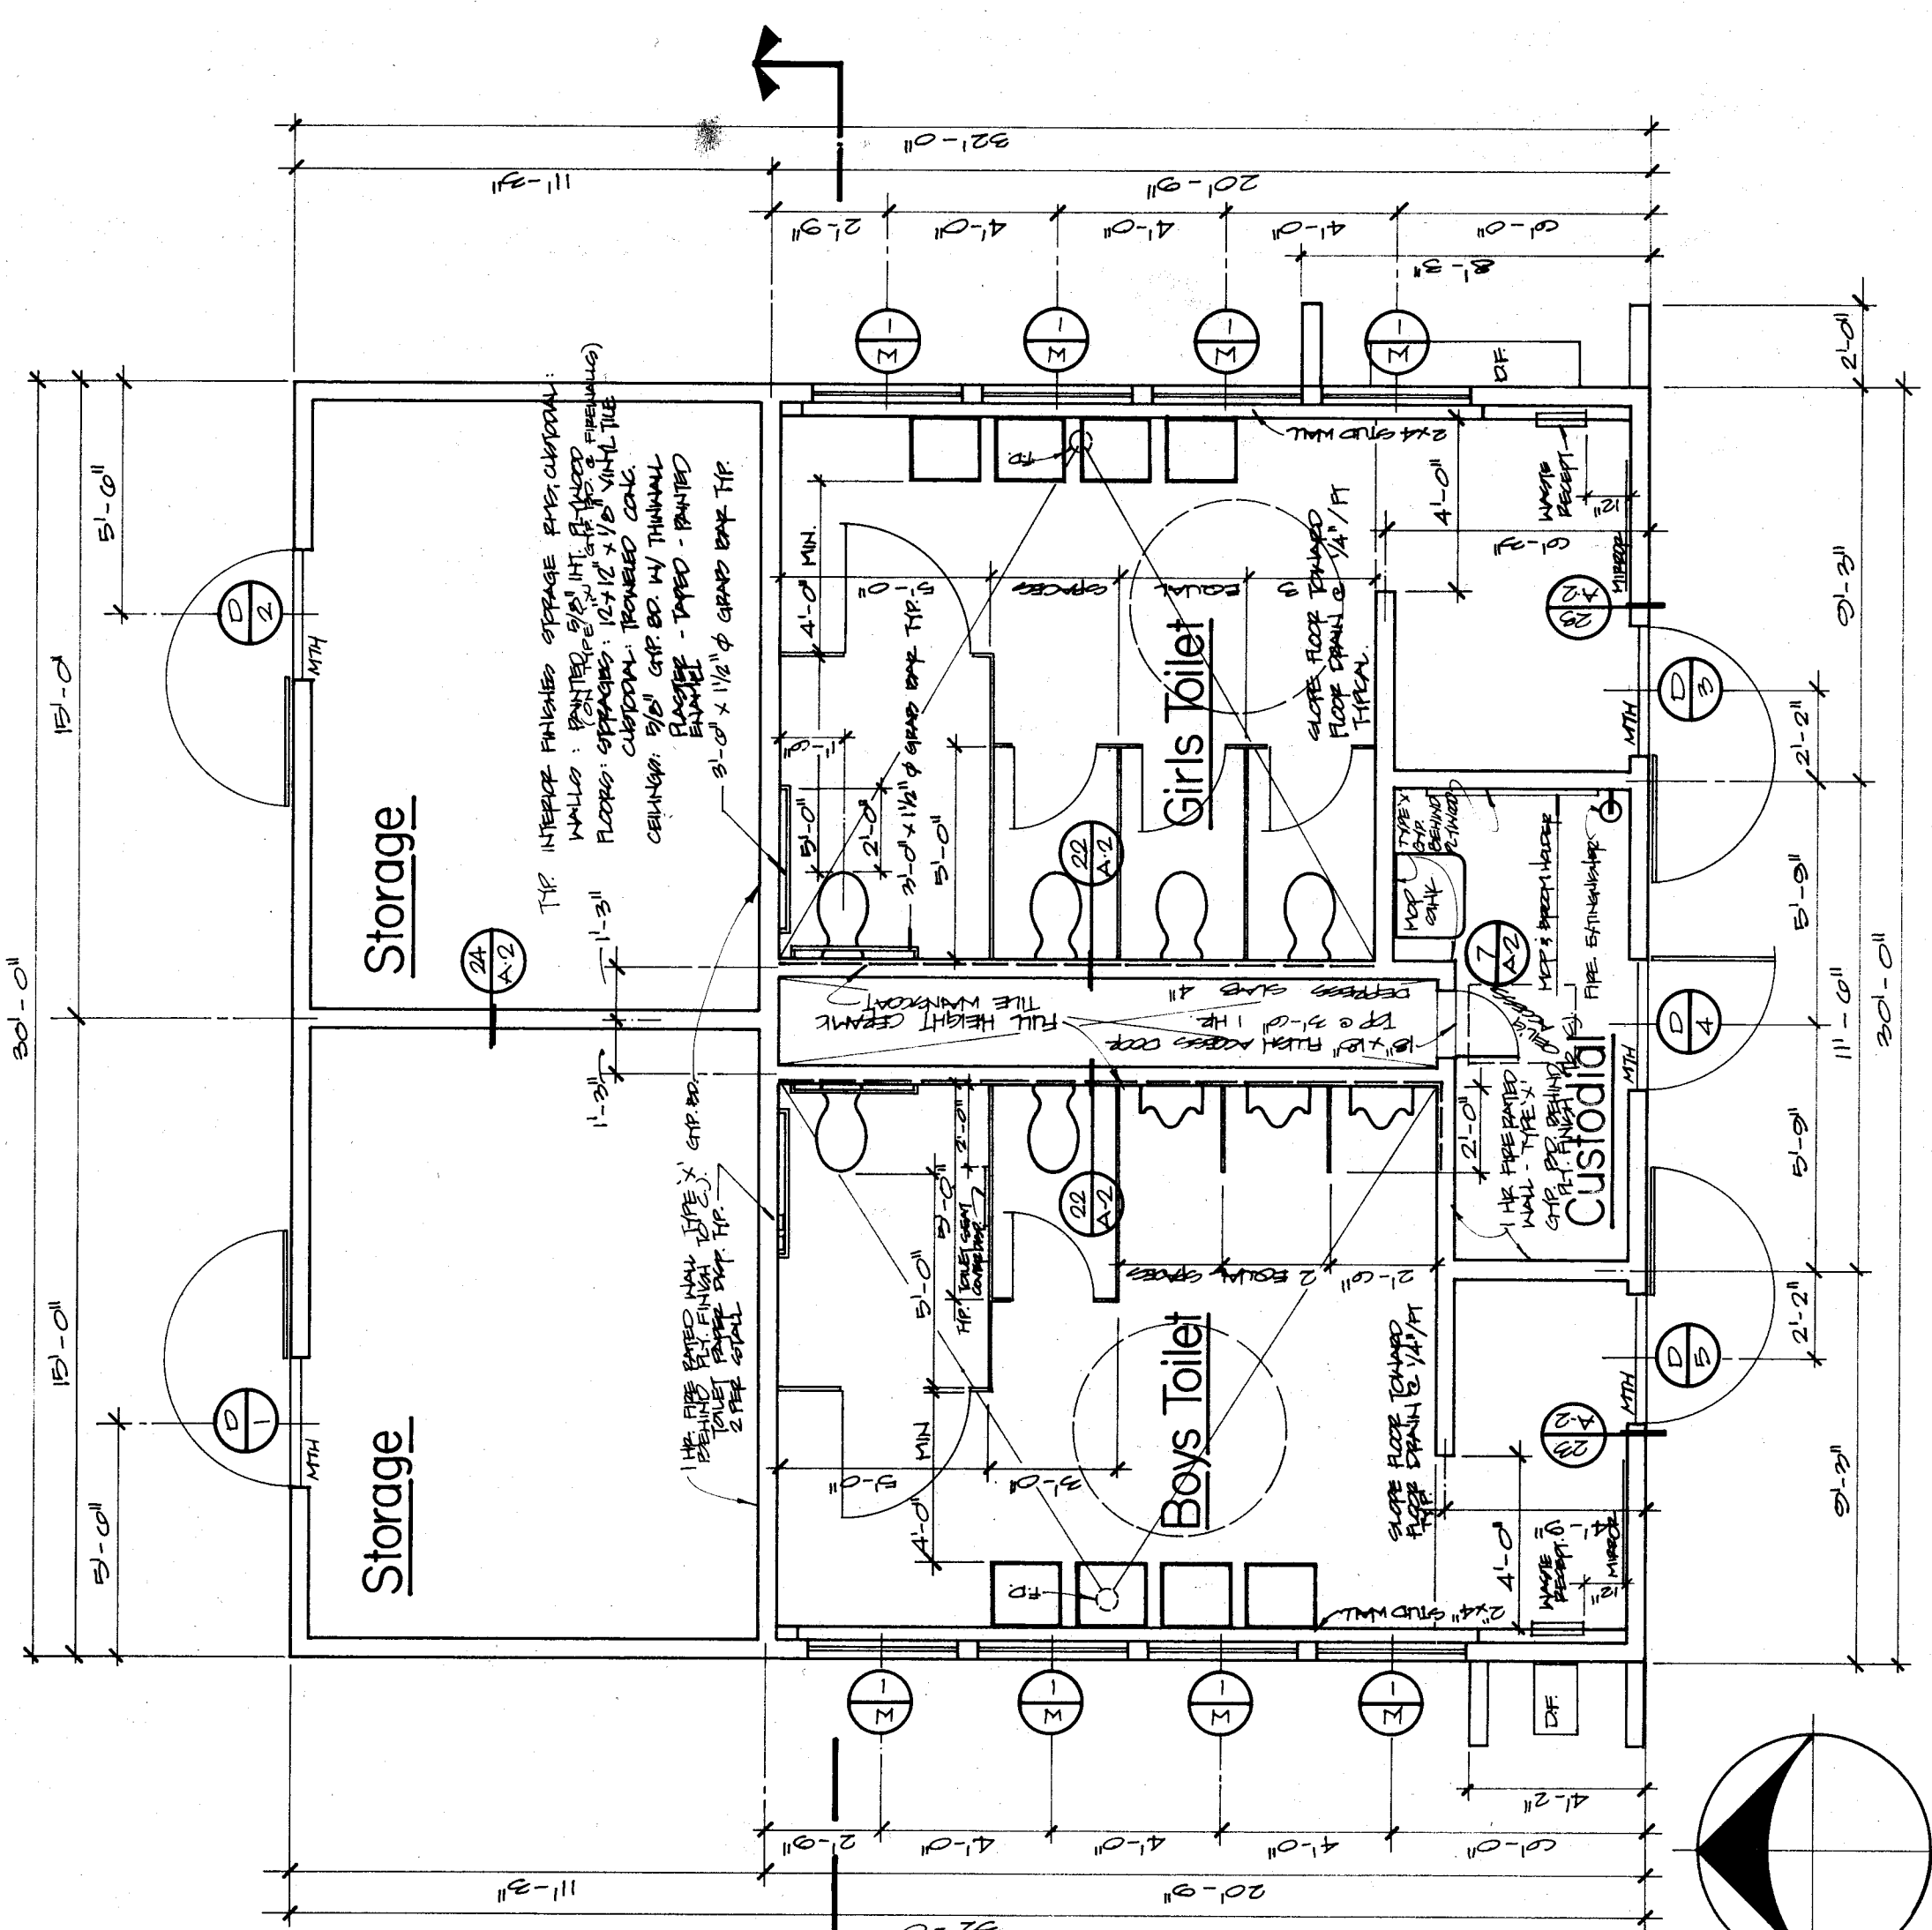

FLOOR PLAN

FLOOR PLAN, SECTION, ELEVATION & INTERIOR ELEVATIONS, ROOF, SITE PLAN	A 1	PORTABLE TOILET BUILDING BAKERSFIELD CITY SCHOOLS NICHOLS ELEMENTARY SCHOOL	OF 2
--	-------------------	---	-------------