



JMPE\JOB\14346\DATE:11-13-14 AC

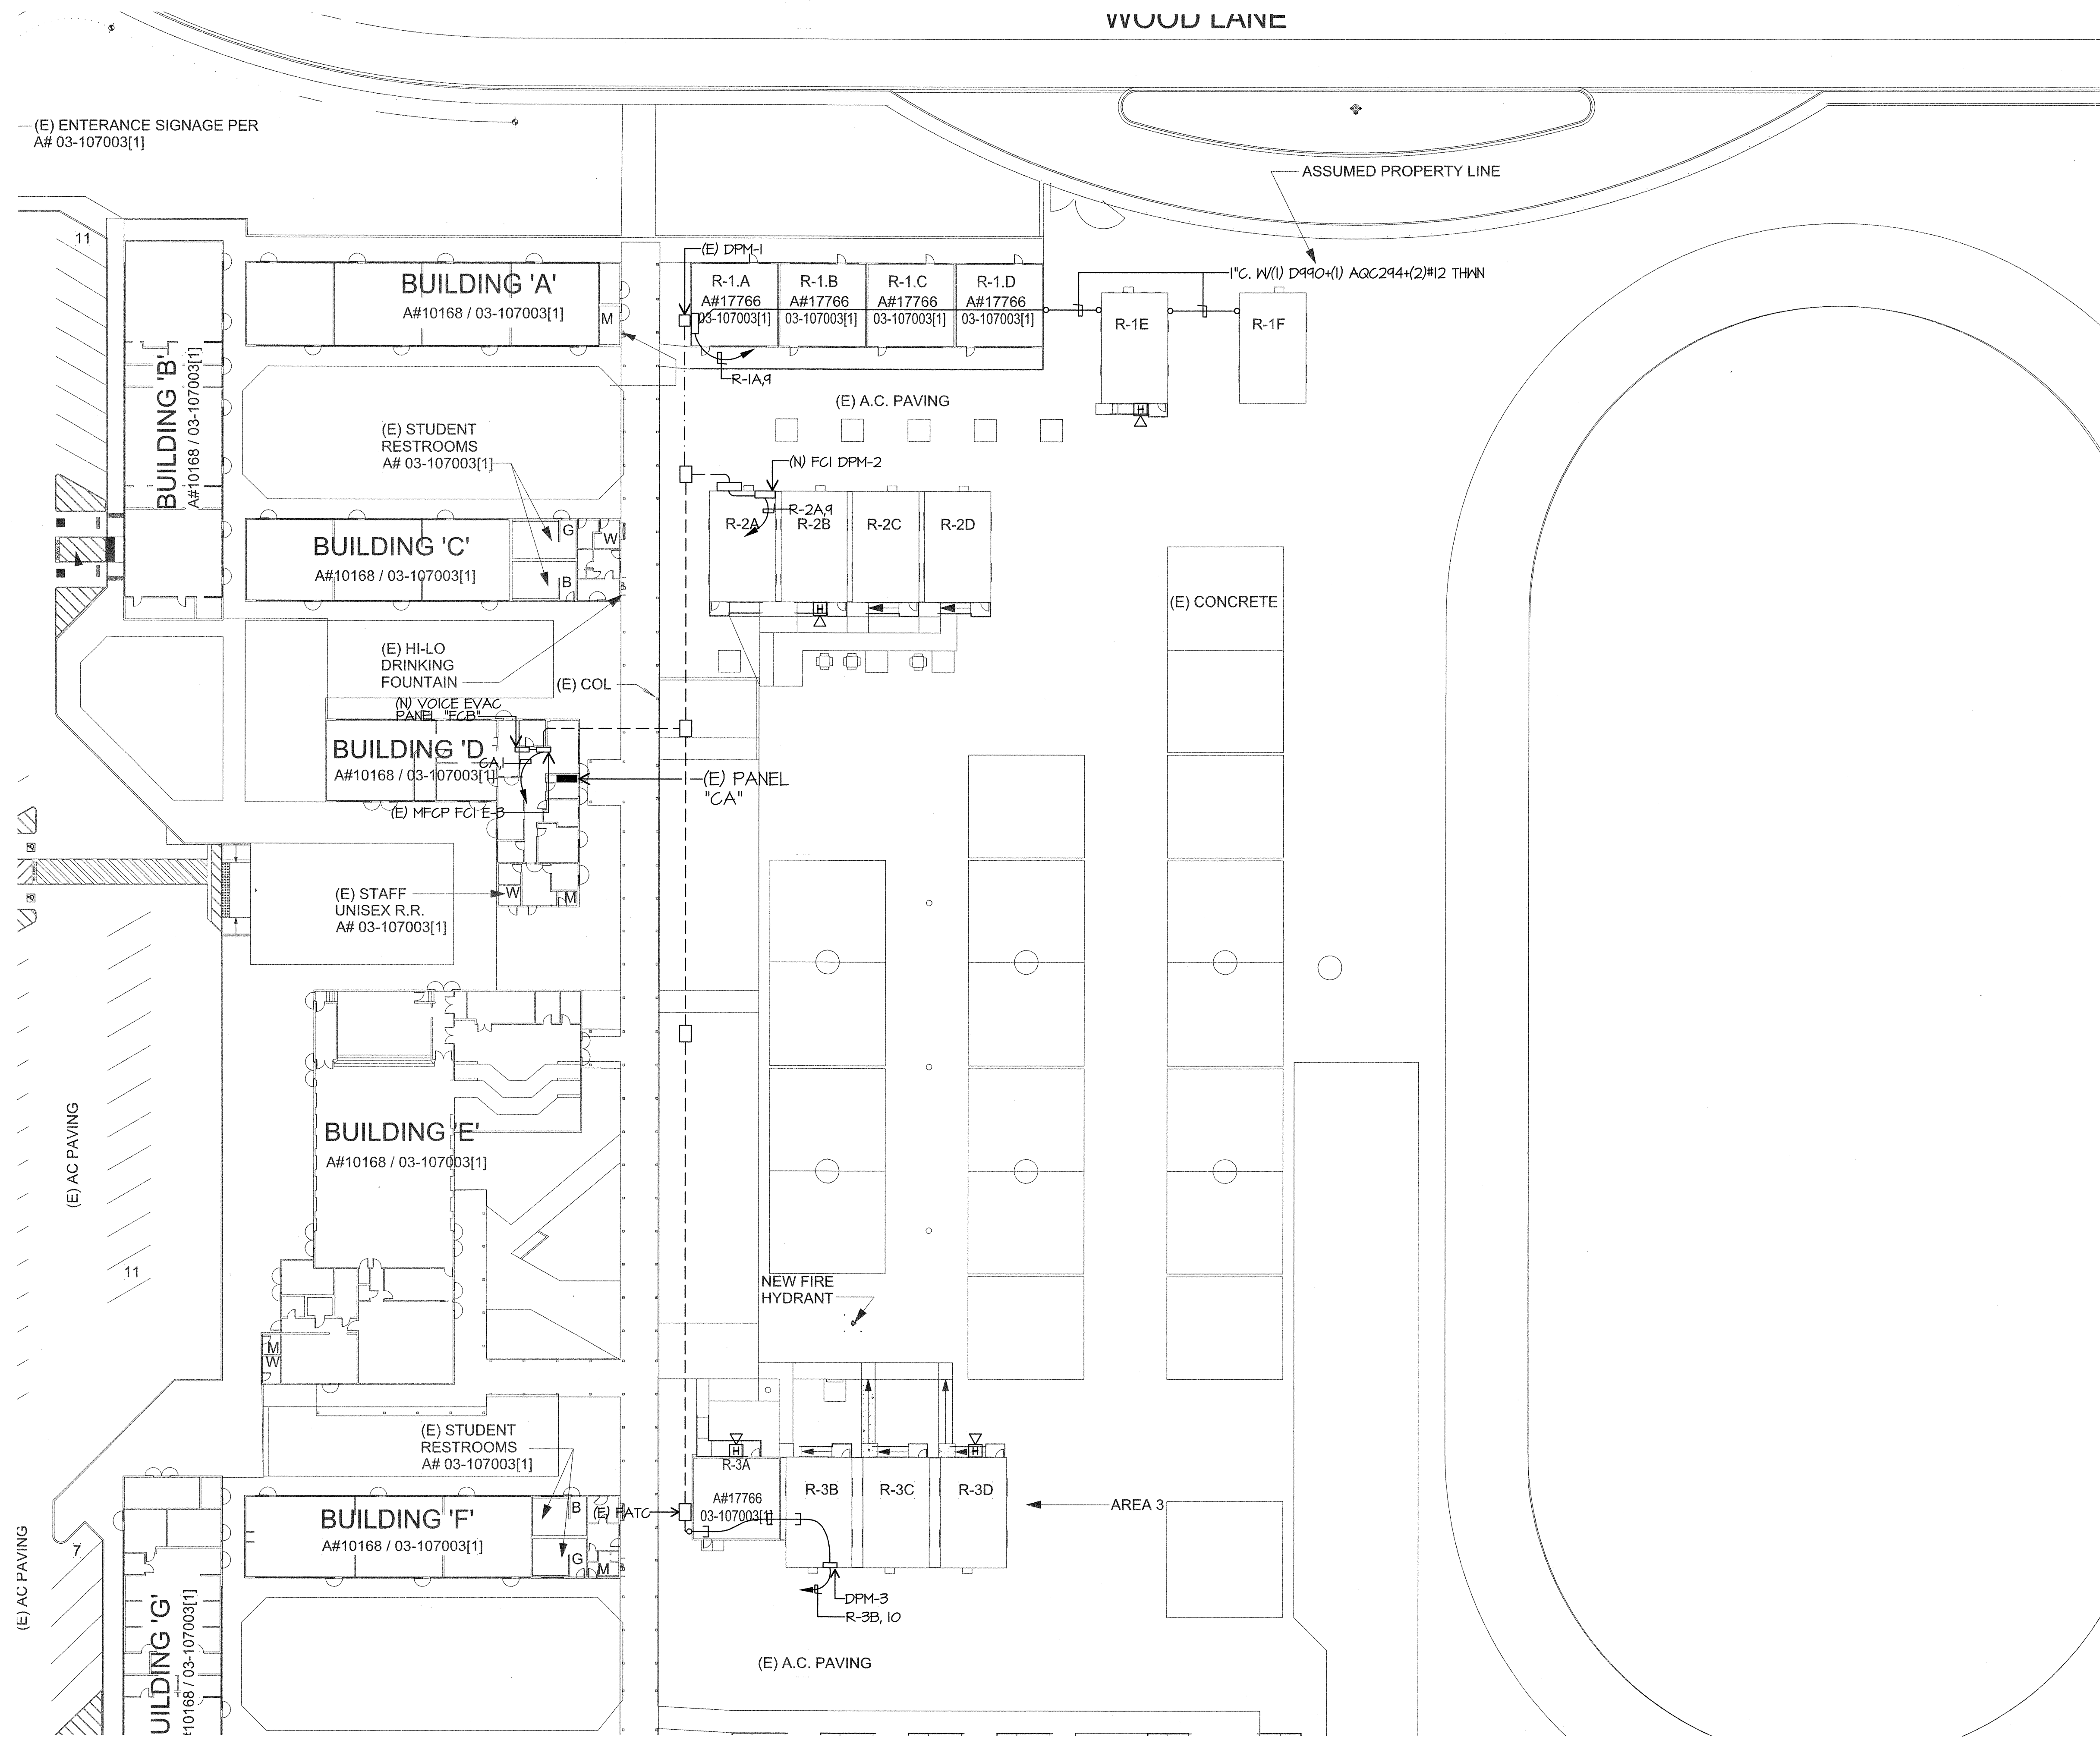


PARTIAL SITE FIRE ALARM PLAN

SCALE: 1"=30'-0"

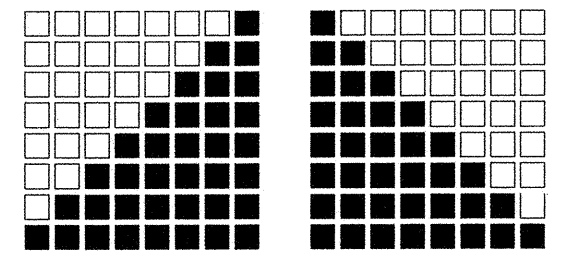

**ORDIZ
MELBY**
ARCHITECTS, INC.

5500 MING AVENUE SUITE 280
BAKERSFIELD, CALIFORNIA 93309
TELEPHONE (661) 832-5258
FACSIMILE (661) 832-4291

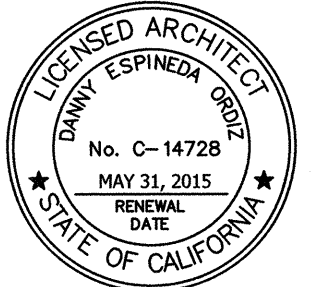

Danny E. Ordiz
DANNY E. ORDIZ, AIA
ARCHITECT C-14,728
WILLIAM J. MELBY, AIA
ARCHITECT C-16,835

IDENTIFICATION STAMP
DIV. OF THE STATE ARCHITECT

APPG3 116318

AC 11/15 FLS. 12 SS. EY

DATE 05/12/15

**9 RELOCATABLE
CLASSROOM BUILDINGS
FOR:**

**CURRAN MIDDLE SCHOOL
1116 LYMRIC WAY
BAKERSFIELD, CA 93309
FOR:**

**BAKERSFIELD CITY
SCHOOL DISTRICT
1300 BAKER STREET
BAKERSFIELD, CA 93305**

MARK	DATE	DESCRIPTION

JOB NUMBER:
1508.00
CAD DRAWING FILE:
1508 NINE New Portables - CD16.pln
DRAWN BY:
AC
CHECKED BY:
KT

CHECK AND VERIFY ALL DIMENSIONS BEFORE
PROCEEDING WITH THE WORK.
REPORT DISCREPANCIES TO THE ARCHITECT.

THE DRAWINGS, IDEAS, AND DESIGNS
REPRESENTED ON THIS SHEET ARE THE
PROPERTY OF THE ARCHITECT.

COPYRIGHT
ORDIZ-MELBY ARCHITECTS, INC. 2010

SHEET TITLE

**PARTIAL SITE
FIRE ALARM
PLAN**

SHEET IDENTIFICATION NUMBER

E-2

SHEET OF

