

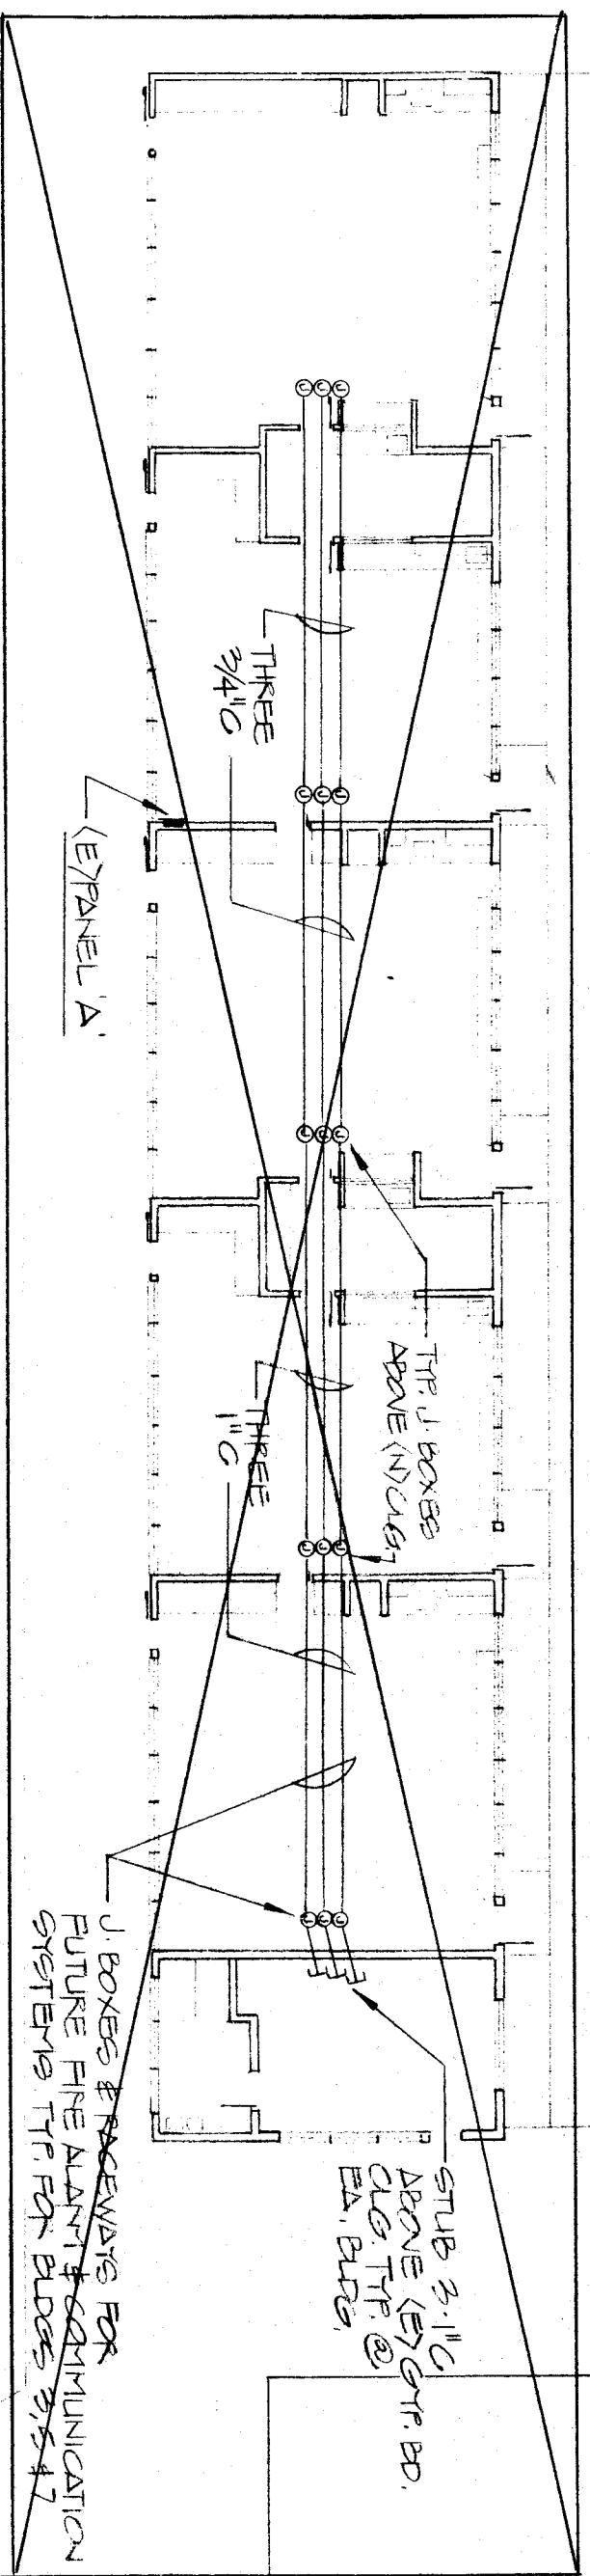
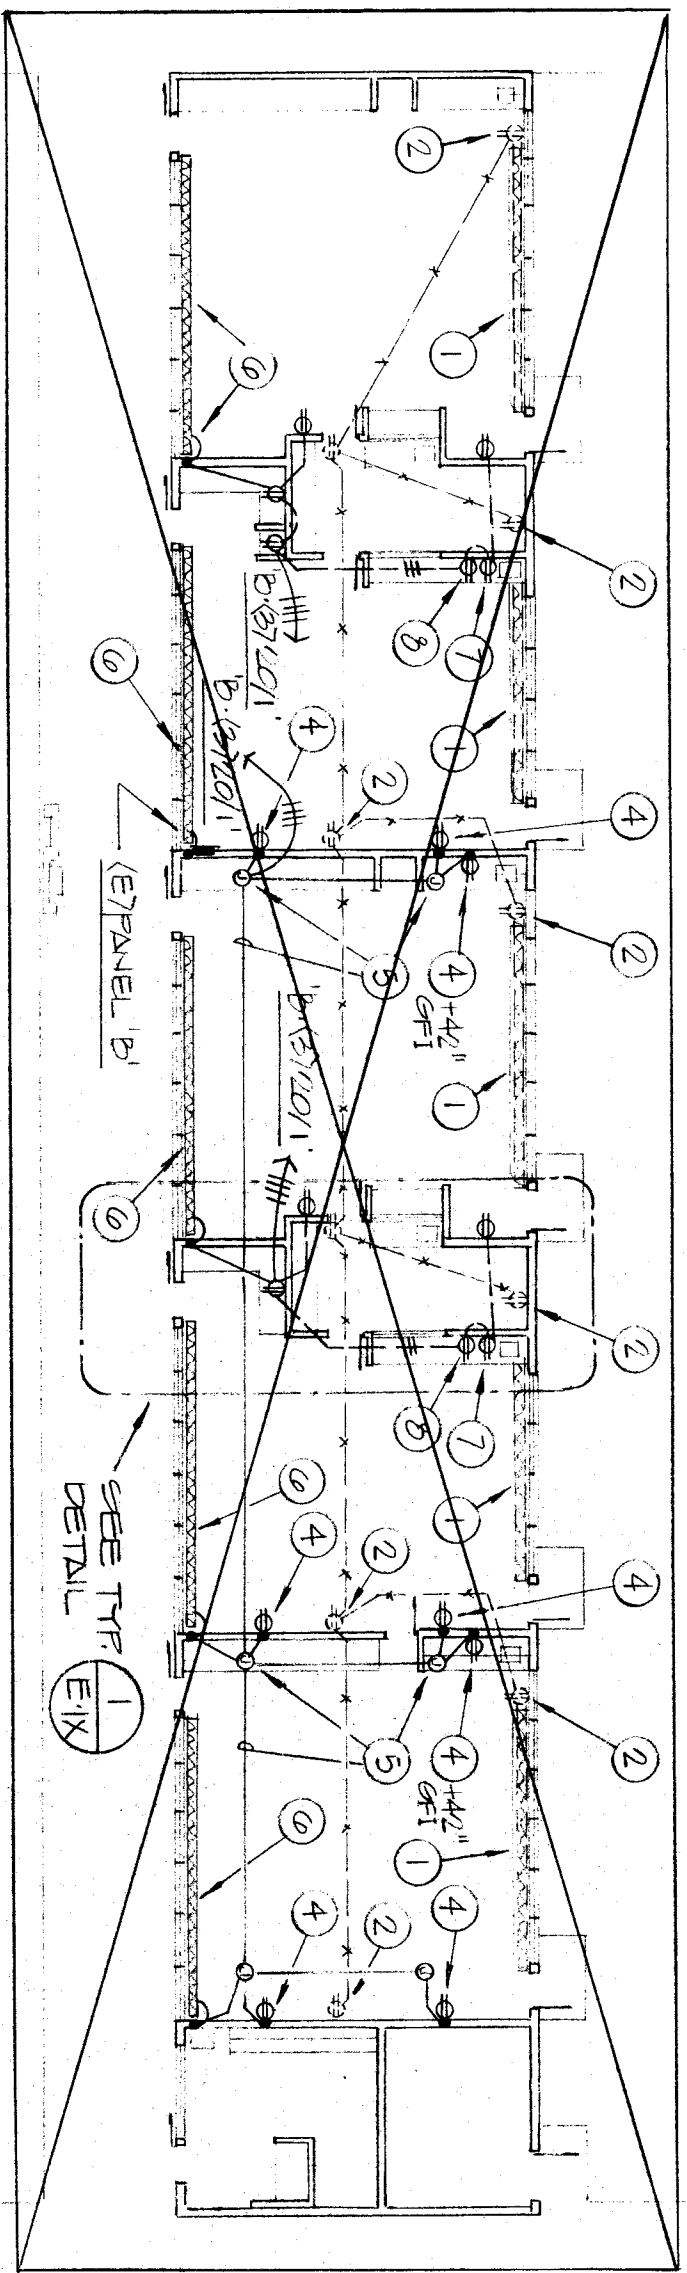
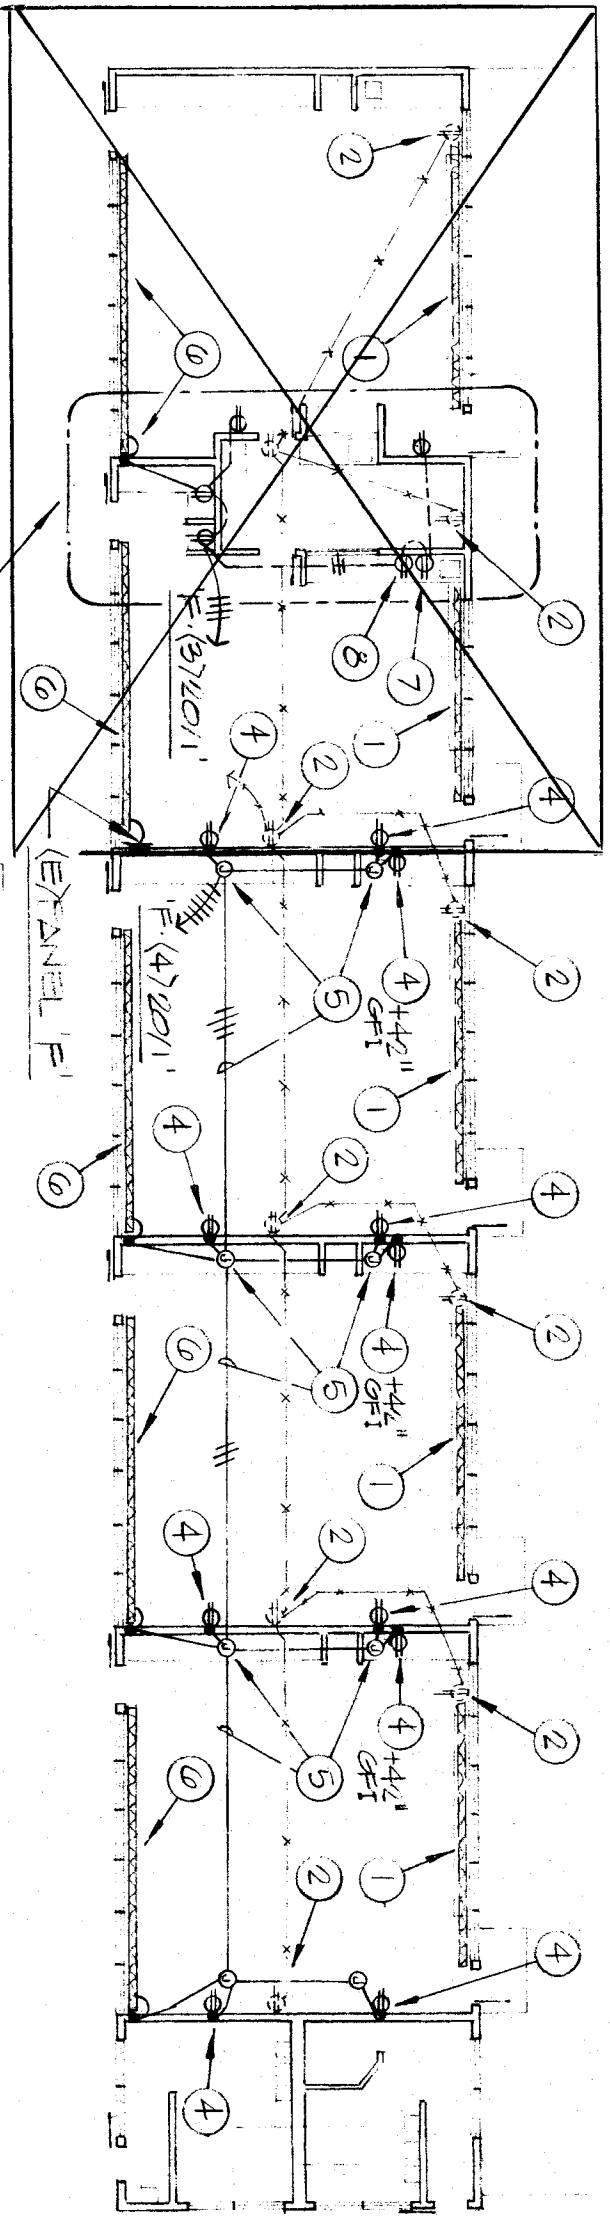
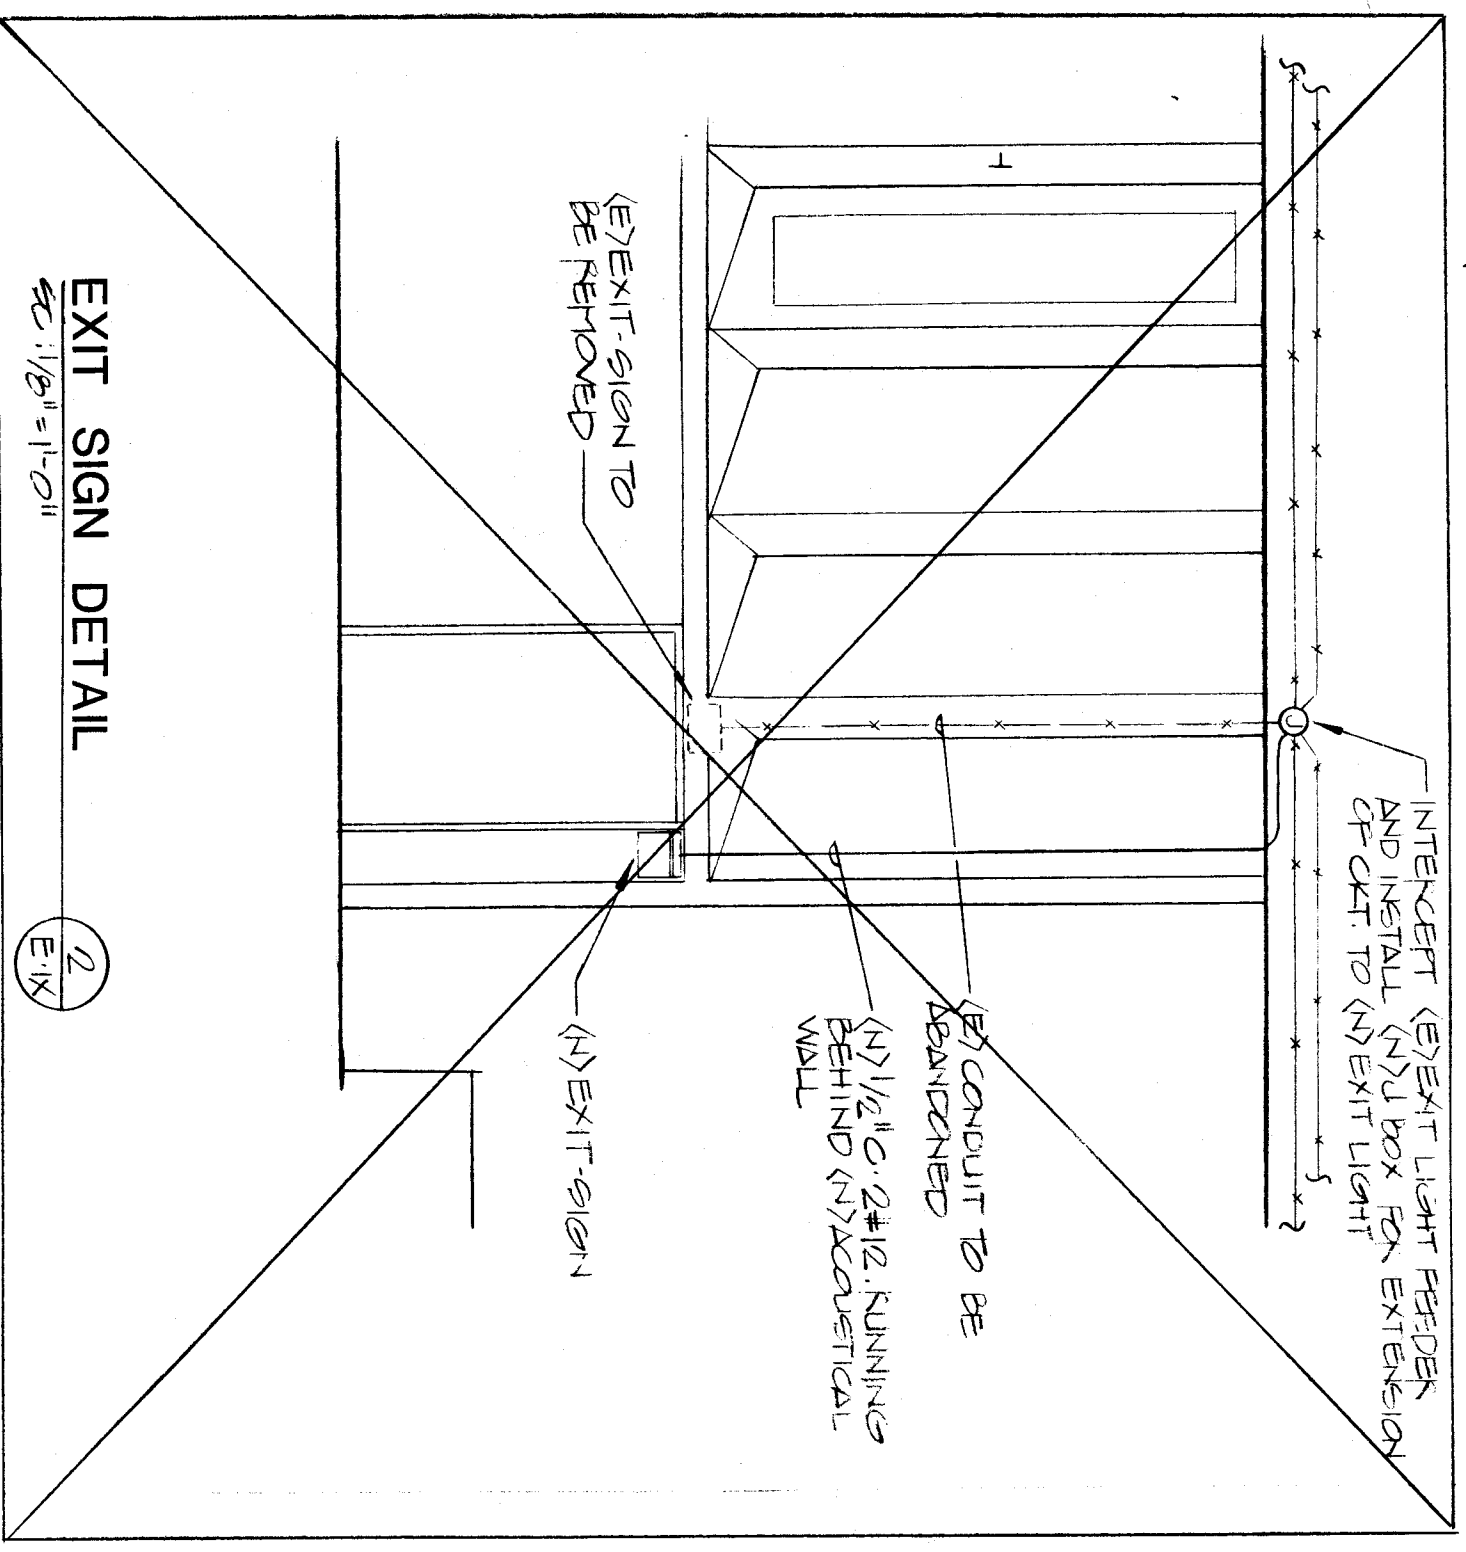
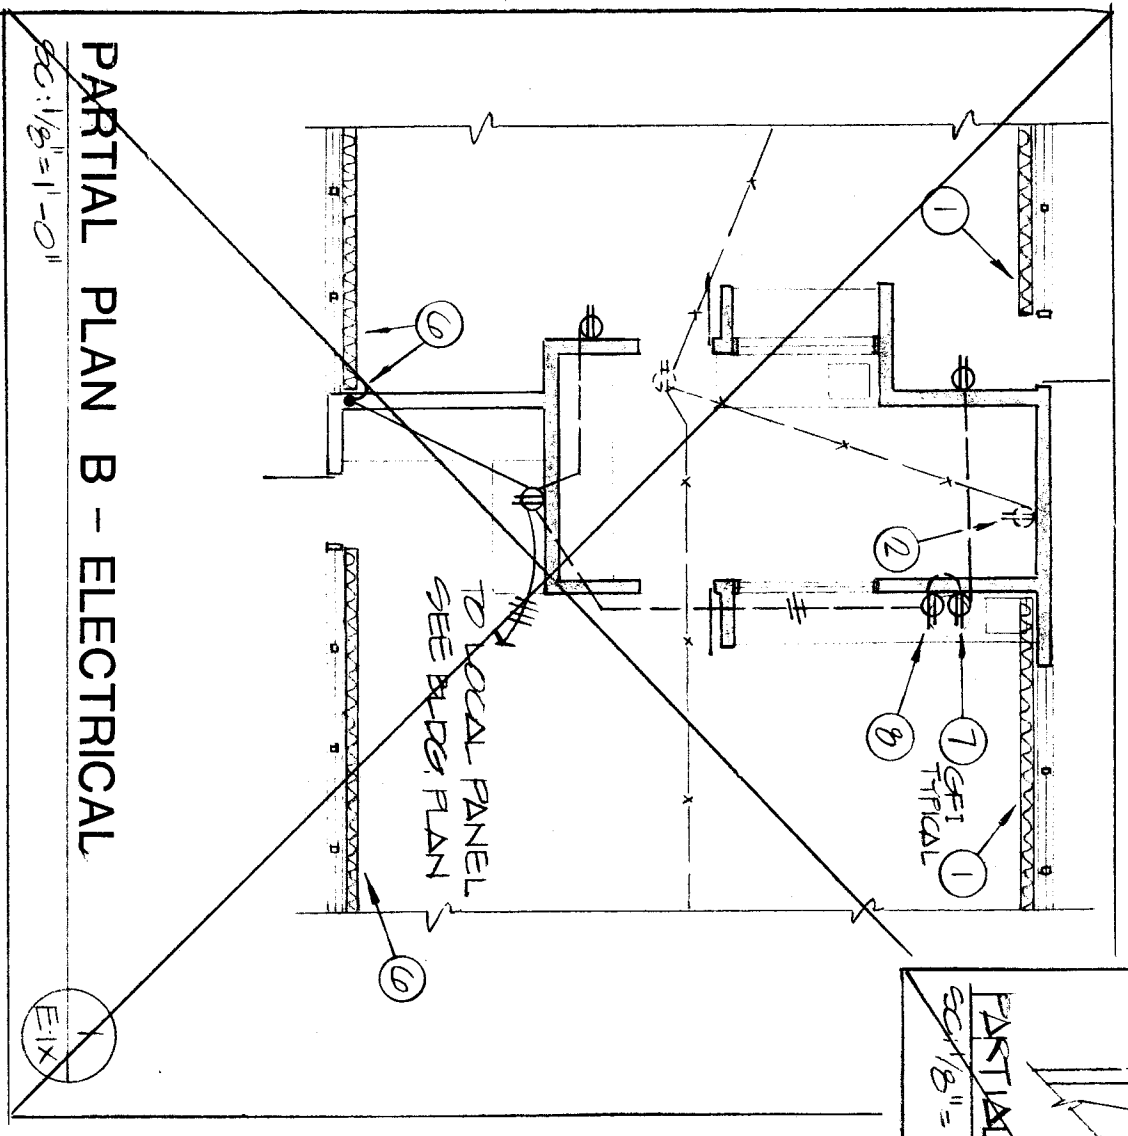
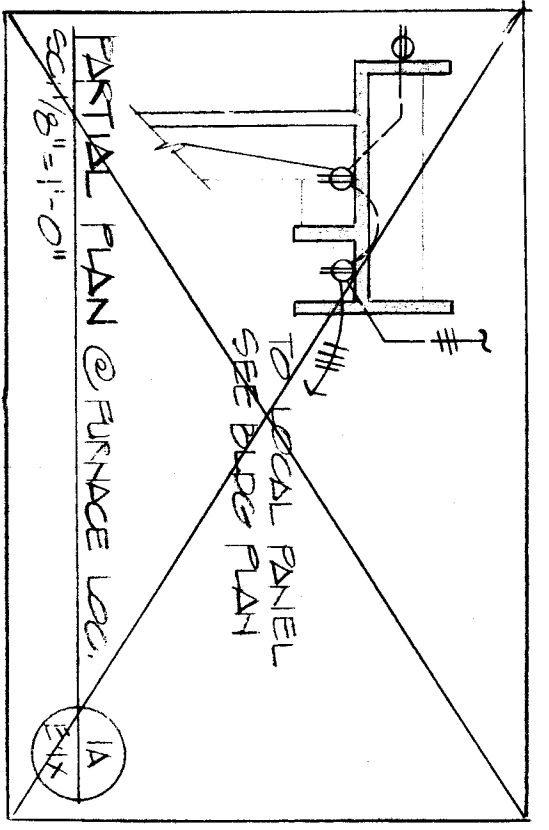
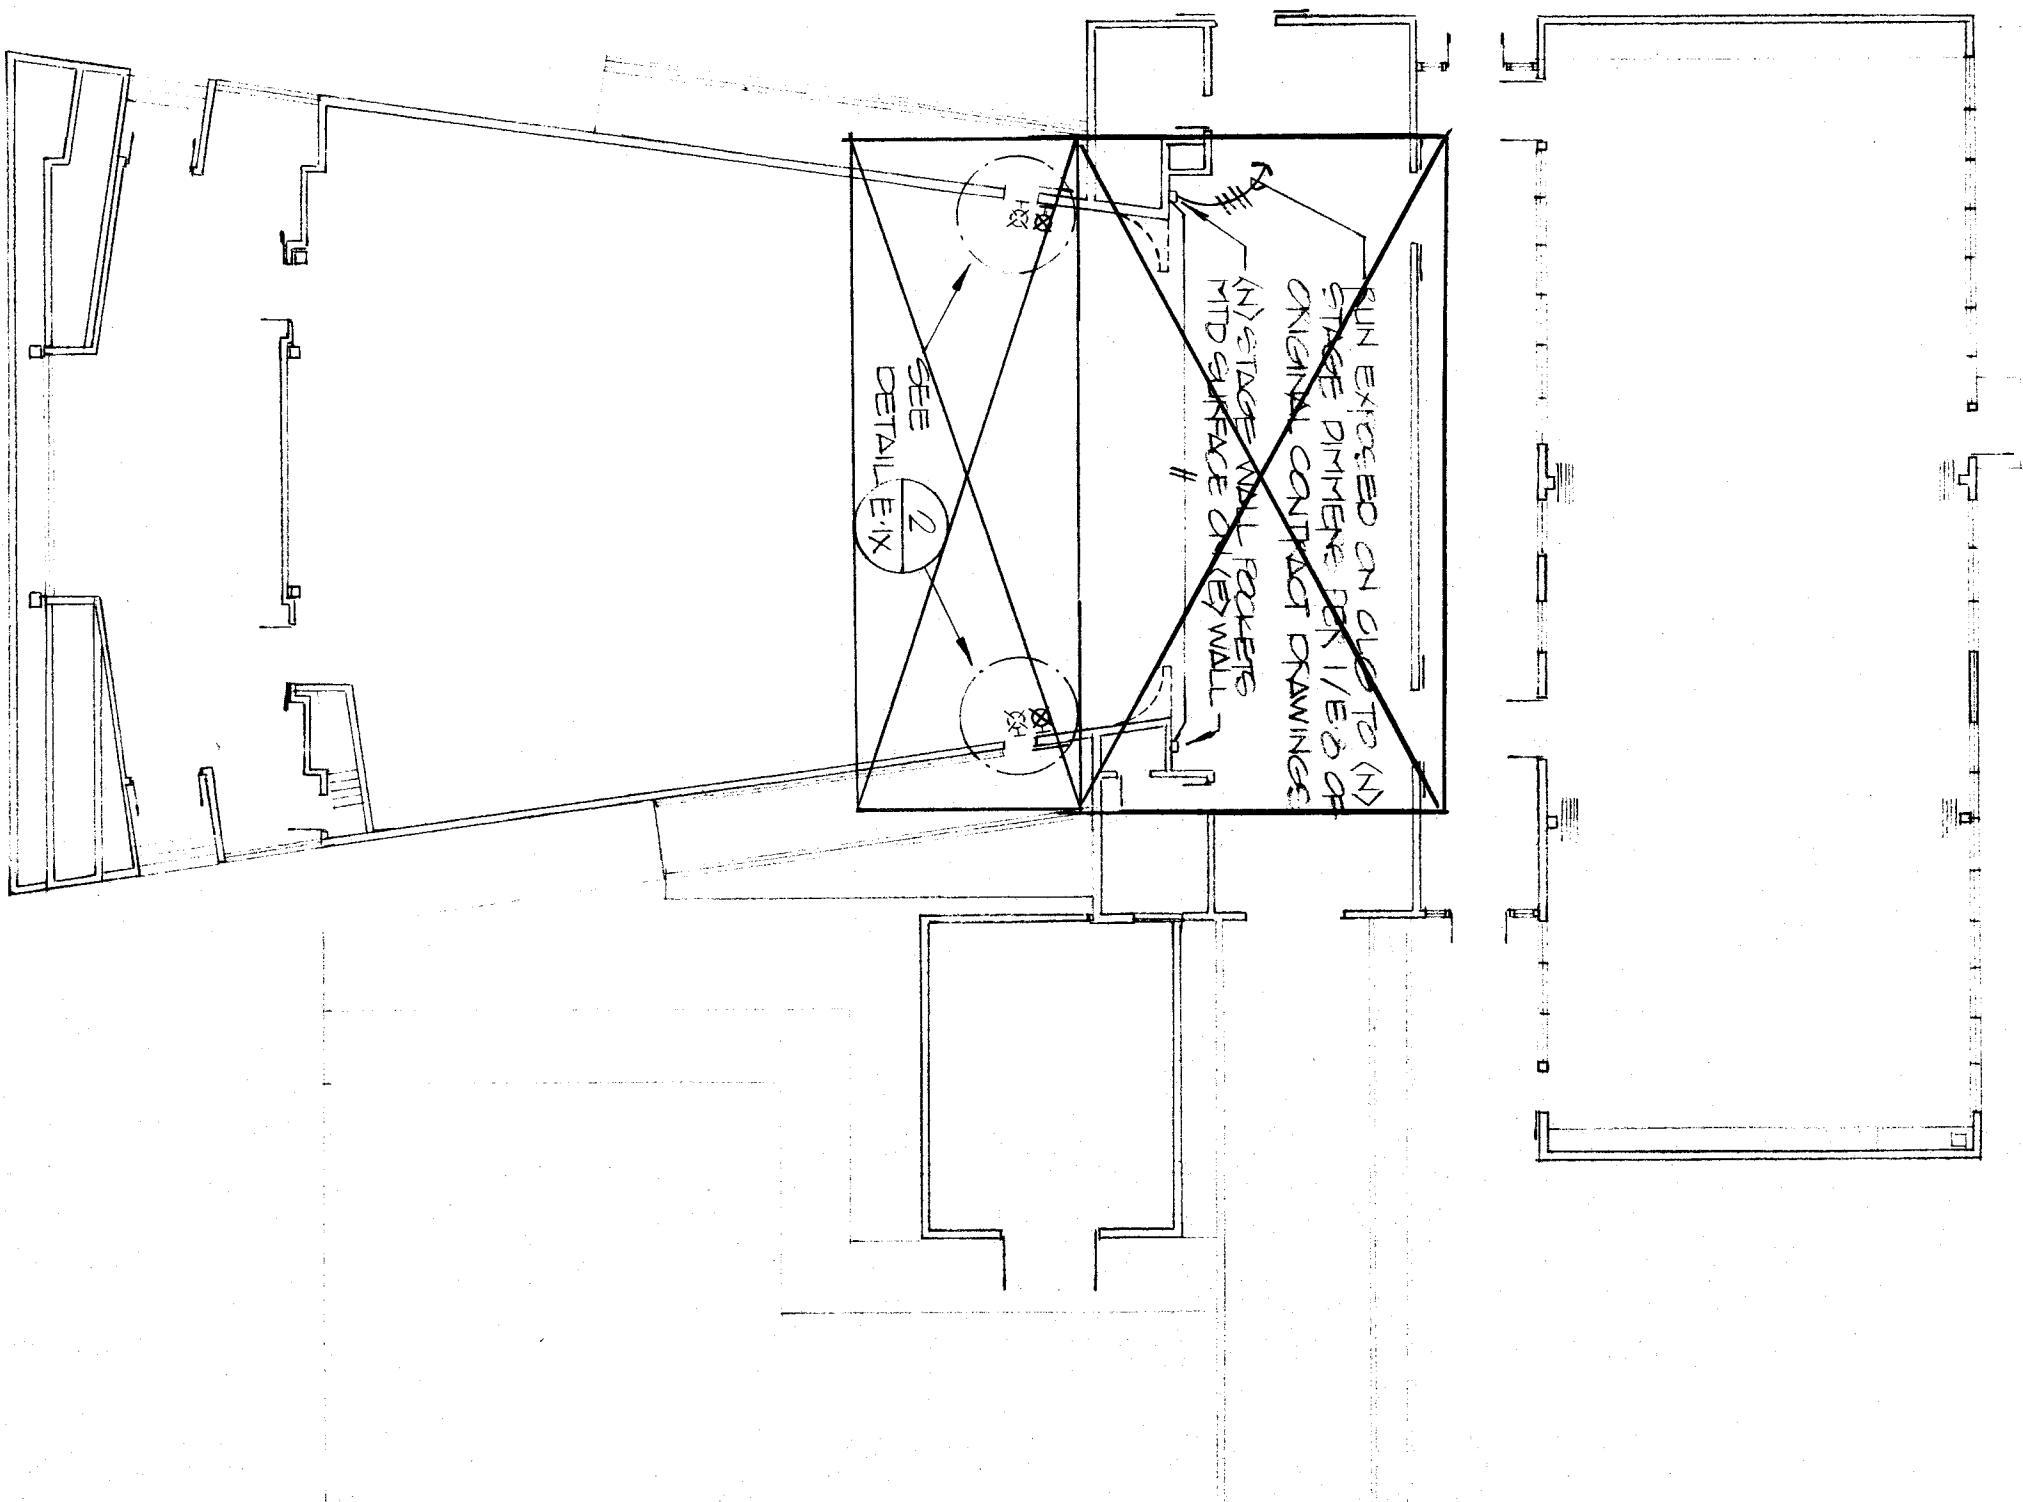
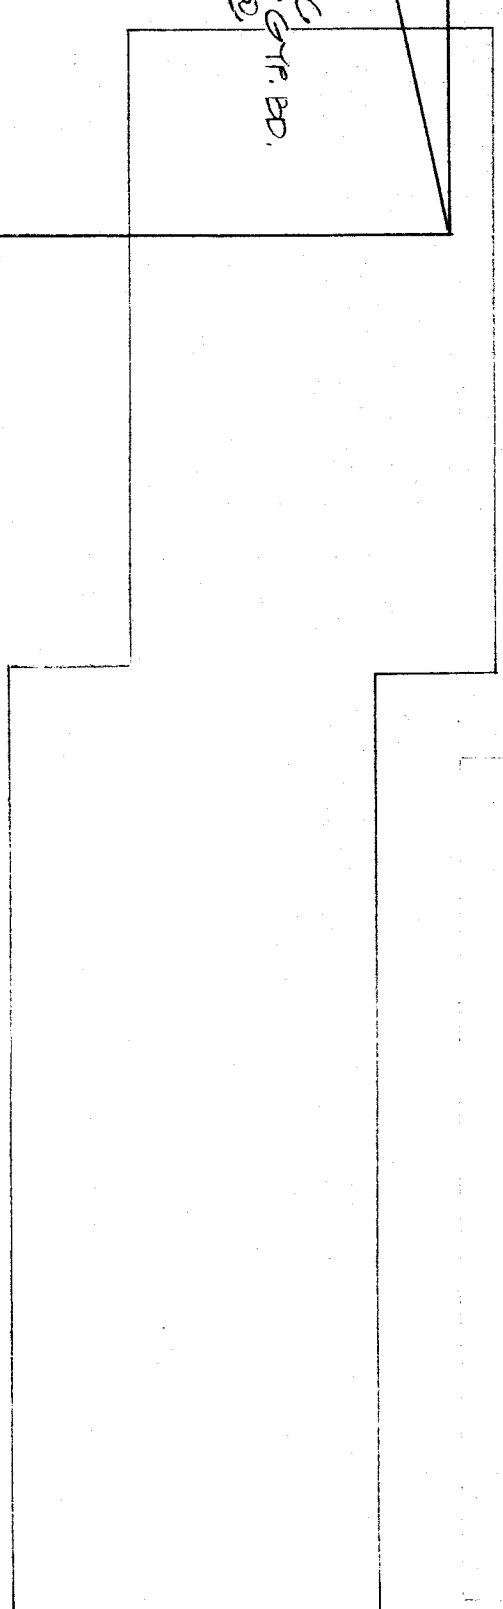



- GENERAL NOTES - TYPICAL THIS SHEET:
- 1 DISCONNECT AND REMOVE EXISTING WIREHOLD.
 - 2 REMOVE EXISTING DUPLEX CONVENIENCE OUTLETS AND WIRING. COVER BOX OUTLETS AS SHOWN. REMOVE EXISTING CIRCUIT BREAKER AT PANEL FOR NEW OUTLETS AS SHOWN.
 - 3 CUT AND PATCH EXISTING WALL FOR CONCEALED ELECTRICAL WORK.
 - 4 PROVIDE AND INSTALL NEW DUPLEX CONVENIENCE OUTLETS IN LOCATIONS SHOWN. FISH IN CONDUIT AND WIRES DOWN IN EXISTING WALL; FLEXIBLE CONDUIT IS ACCEPTABLE.
 - 5 NEW JUNCTION BOX AND CONDUIT MOUNTED ABOVE T-BAR CEILING.
 - 6 EXISTING WIREHOLD TO REMAIN. INTERCEPT EXISTING CIRCUIT AT WALL AND EXTEND TO NEW JBOX. INTERCEPT EXISTING CIRCUIT AT PANEL AS SHOWN ON PLANS.
 - 7 NEW DUPLEX CONVENIENCE OUTLET MOUNTED ABOVE COUNTER +/- 42" A.F.F. (COORDINATE WITH ARCHITECT).
 - 8 NEW DUPLEX CONVENIENCE OUTLET MOUNTED BELOW COUNTER FOR NEW ELECTRICAL WATER HEATER.

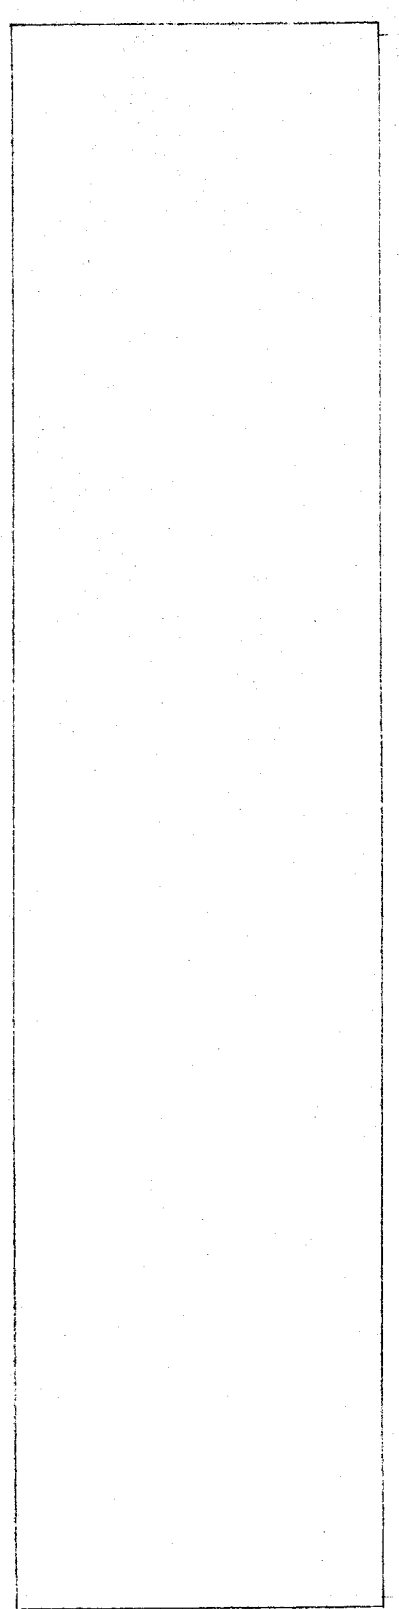

BUILDING # 3
NOTE:
ALL ELECTRICAL WORK TO BE PERFORMED IN THIS BLDG
SHALL BE SIMILAR TO THAT OF BLDG #6 ABOVE

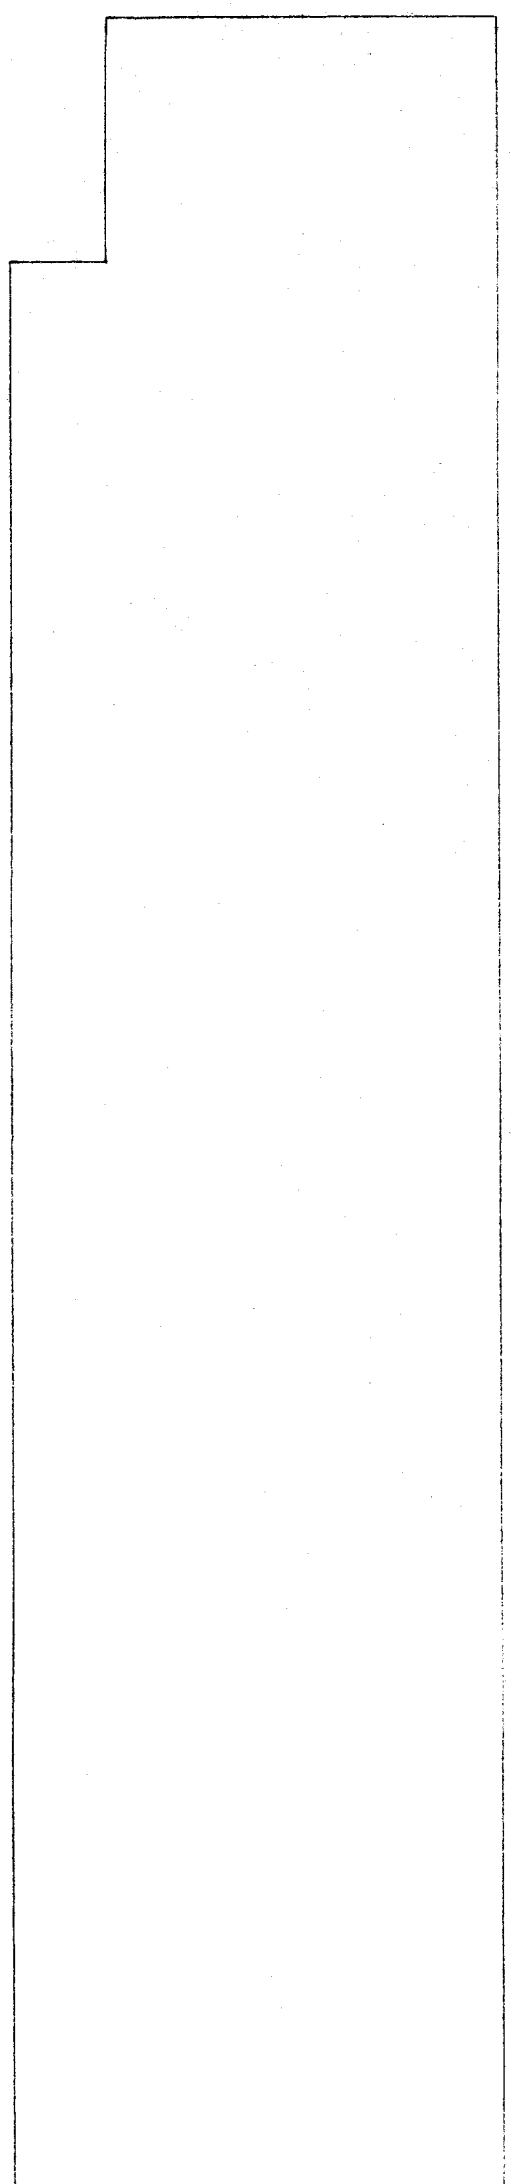

ELECTRICAL FLOOR PLANS
SCALE: 1/16" = 1'-0"

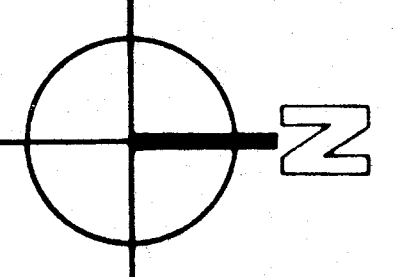

C-3289
 C-3132
 *C-6844
 DAVID R. OAKMAN
 INTERSTATE ENGINEERING, INC.
 1000 WEST 10TH AVENUE, SUITE 100
 DENVER, CO 80202
 © COPYRIGHTED 1987

bfgc inc.
 architects planners
 31 SOUTH HALL ROAD BOX 9688
 BAKERSFIELD CALIFORNIA 93309
 805 832 8122

ELECTRICAL FLOOR PLANS AND DETAILS
BLAIR LEARNING CENTER
 KERN COUNTY SUPERINTENDENT OF SCHOOLS
 BAKERSFIELD CA.

10/85-10/86
 11/16/87

bfgc
 architects - planners