


LIGHTING PANEL B			
LOCATION: ROOM 73			
DRAWING: ELEC			
DATE: 10-4			
NO.	DESCRIPTION	WATTAGE	LOCATION
1	1/2" x 4" x 16"	40	ENGLISH #8
2	1/2" x 4" x 16"	40	"
3	1/2" x 4" x 16"	40	"
4	1/2" x 4" x 16"	40	"
5	1/2" x 4" x 16"	40	"
6	1/2" x 4" x 16"	40	"
7	1/2" x 4" x 16"	40	"
8	1/2" x 4" x 16"	40	"
9	1/2" x 4" x 16"	40	"
10	1/2" x 4" x 16"	40	"
11	1/2" x 4" x 16"	40	"
12	1/2" x 4" x 16"	40	"
13	1/2" x 4" x 16"	40	"
14	1/2" x 4" x 16"	40	"
15	1/2" x 4" x 16"	40	"
16	1/2" x 4" x 16"	40	"
17	1/2" x 4" x 16"	40	"
18	1/2" x 4" x 16"	40	"
19	1/2" x 4" x 16"	40	"
20	1/2" x 4" x 16"	40	"
21	1/2" x 4" x 16"	40	"
22	1/2" x 4" x 16"	40	"
23	1/2" x 4" x 16"	40	"
24	1/2" x 4" x 16"	40	"
25	1/2" x 4" x 16"	40	"
26	1/2" x 4" x 16"	40	"
27	1/2" x 4" x 16"	40	"
28	1/2" x 4" x 16"	40	"
29	1/2" x 4" x 16"	40	"
30	1/2" x 4" x 16"	40	"
TOTAL		1200	

LIGHTING PANEL A			
LOCATION: ROOM 72			
DRAWING: ELEC			
DATE: 10-4			
NO.	DESCRIPTION	WATTAGE	LOCATION
1	1/2" x 4" x 16"	40	SOCIAL STUDIES #1
2	1/2" x 4" x 16"	40	"
3	1/2" x 4" x 16"	40	"
4	1/2" x 4" x 16"	40	"
5	1/2" x 4" x 16"	40	"
6	1/2" x 4" x 16"	40	"
7	1/2" x 4" x 16"	40	"
8	1/2" x 4" x 16"	40	"
9	1/2" x 4" x 16"	40	"
10	1/2" x 4" x 16"	40	"
11	1/2" x 4" x 16"	40	"
12	1/2" x 4" x 16"	40	"
13	1/2" x 4" x 16"	40	"
14	1/2" x 4" x 16"	40	"
15	1/2" x 4" x 16"	40	"
16	1/2" x 4" x 16"	40	"
17	1/2" x 4" x 16"	40	"
18	1/2" x 4" x 16"	40	"
19	1/2" x 4" x 16"	40	"
20	1/2" x 4" x 16"	40	"
21	1/2" x 4" x 16"	40	"
22	1/2" x 4" x 16"	40	"
23	1/2" x 4" x 16"	40	"
24	1/2" x 4" x 16"	40	"
25	1/2" x 4" x 16"	40	"
26	1/2" x 4" x 16"	40	"
27	1/2" x 4" x 16"	40	"
28	1/2" x 4" x 16"	40	"
29	1/2" x 4" x 16"	40	"
30	1/2" x 4" x 16"	40	"
TOTAL		1200	

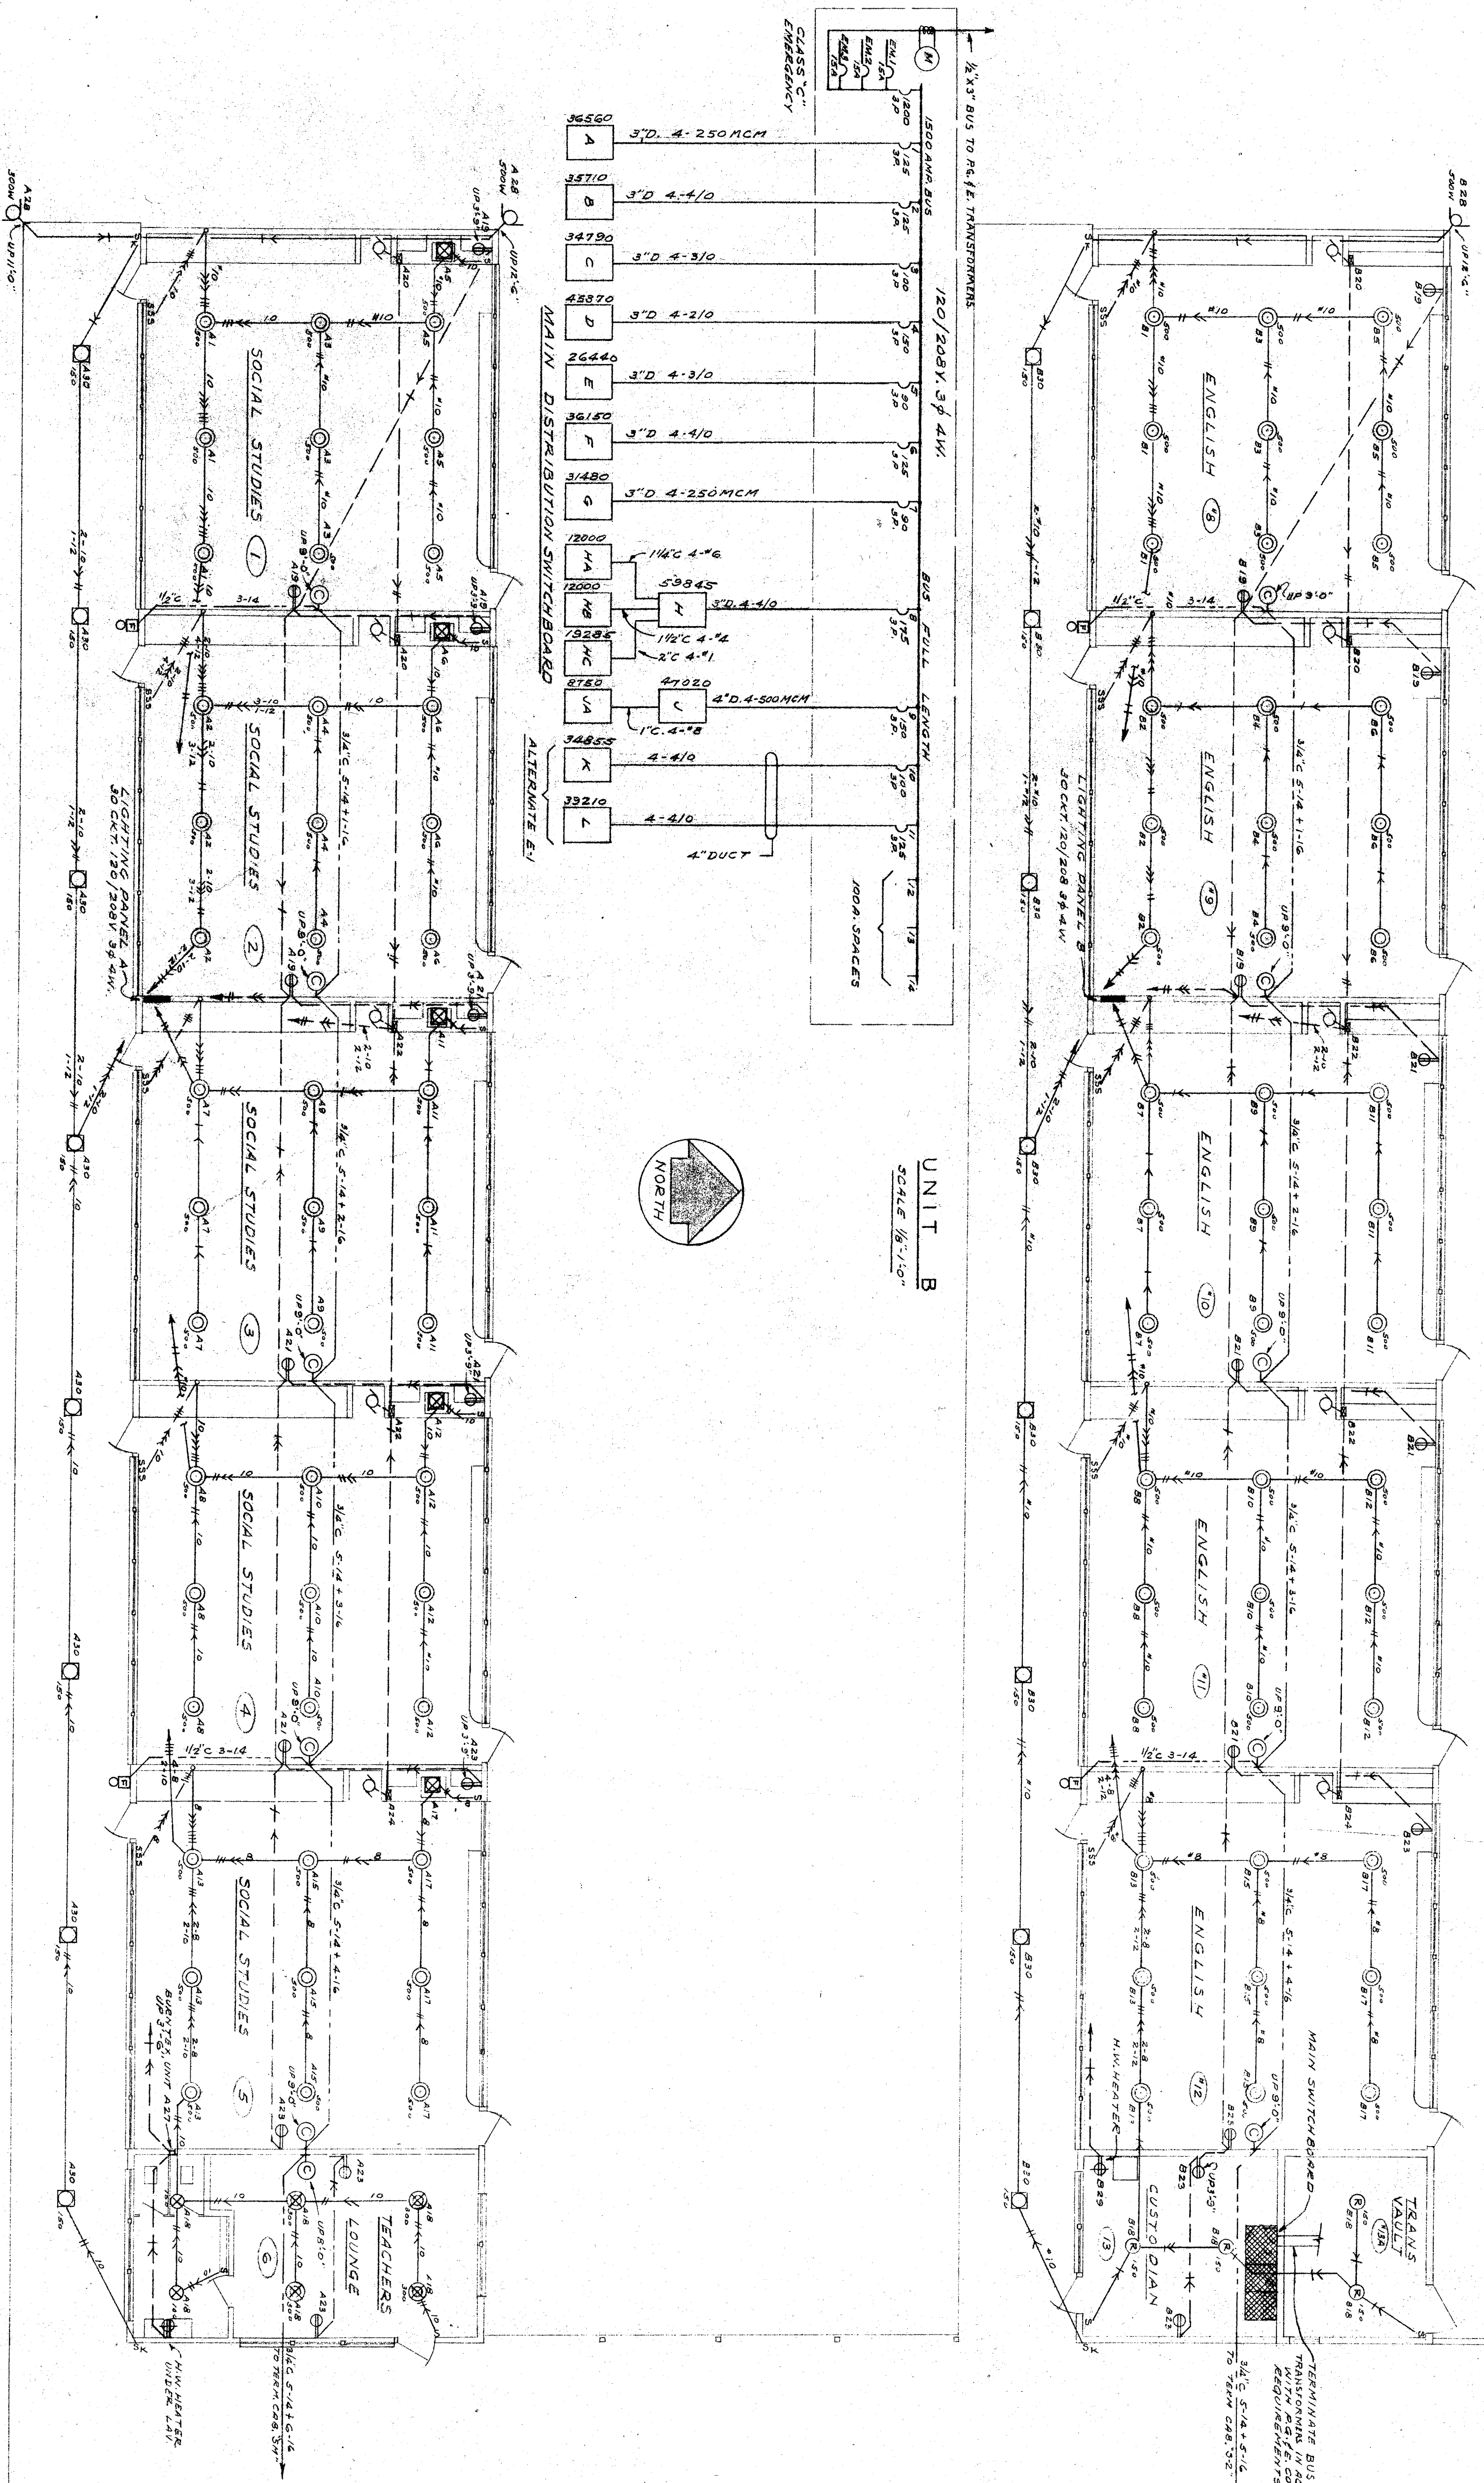

LESTER R. KELLY
MECHANICAL AND ELECTRICAL CONSULTING ENGINEER
443 SOUTH BEAUBAY AVENUE
LOS ANGELES, CALIF.

COUNTY OF KERN
OFFICE OF SUPERINTENDENT OF SCHOOLS
SUPERINTENDENT

STATE OF CALIFORNIA
DEPARTMENT OF PUBLIC WORKS
DIVISION OF ARCHITECTURE

BAKERSFIELD CITY SCHOOLS
1600 K ST BAKERSFIELD CALIFORNIA
BELLE TERRACE & P STREETS
BAKERSFIELD

ERNEST L. MCCOY A-I-A ARCHITECT
152 - 19th ST.
CALIFORNIA

FLOOR PLANS UNITS A & B ELECTRICAL

DRAWN BY: [Signature] DATE: 5-1-57
CHECKED BY: [Signature] DATE: 5-1-57

JOB NO. 152-19th ST. ARCHITECT OF SCHOOLS
DATE: 5-1-57
E-2

CHECK AND VERIFY ALL DIMENSIONS BEFORE PROCEEDING WITH THE WORK. REPORT ANY DISCREPANCIES TO ARCHITECT.