

LEGEND

- T-BAR CEILING
- FIELD INSTALLED PANEL AT MODULE LINE
- 2' x 4' RECESSED LIGHT FIXTURE
- "OPTIONAL" 1' x 4' RECESSED LIGHT FIXTURE
- SPLAY WIRE
- CEILING MOUNTED SMOKE DETECTOR
- ATTIC MOUNTED HEAT DETECTOR
- CEILING EXHAUST FAN
- CEILING EXHAUST FAN

NOTE:
 FOR ALL REFLECTED CEILING NOTES
 SEE SHEET A-0.1

THESE DRAWINGS AND ALL MATERIAL CONTAINED HEREIN ARE THE PROPERTY OF SILVERCREEK INDUSTRIES, INC (SCI INC) AND SHALL NOT BE REPRODUCED, COPIED OR OTHERWISE DISPOSED OF DIRECTLY OR INDIRECTLY AND SHALL NOT BE USED IN WHOLE OR IN PART TO ASSIST IN THE MAKING OF OR FOR THE PURPOSE OF FURNISHING ANY INFORMATION FOR THE MAKING OF DRAWINGS, PRINTS, APPARATUS OR PARTS THEREOF WITHOUT THE FULL KNOWLEDGE AND WRITTEN CONSENT OF SCI INC. ALL PATENTABLE MATERIAL CONTAINED HEREIN AND ORIGINATING WITH SCI INC SHALL BE THE PROPERTY OF SCI INC.

SILVER CREEK INDUSTRIES, INC.

 "BUILDING FOR THE NEXT GENERATION"
 195 EAST MORGAN PERRIS, CALIFORNIA 92571
 PHONE: 951-943-5393 FAX: 951-943-2211

PROJECT NAME:

CLASS LEASING

SHEET TITLE:
REFLECTED CEILING PLAN
 12'x40' MODEL C-1 OR C-2

STAVARES ASSOCIATES
 ARCHITECTS
 1001 S. GARDEN ST. SUITE 200
 ANAHEIM, CA 92805
 (714) 771-8888
 www.stavares.com

12/23/2011

ARCHITECT OF RECORD
 SUBMISSION DATE

IDENTIFICATION STAMP
 DIV. OF THE STATE ARCHITECT
 OFFICE OF REGULATION SERVICES

04 11 2011
 AC [Signature]
 DATE AUG 27 2011

PROJECT SPECIFIC STATE AGENCY APPROVAL

IDENTIFICATION STAMP
 DIV. OF THE STATE ARCHITECT
 OFFICE OF REGULATION SERVICES

04 11 2011
 AC [Signature]
 DATE AUG 27 2011

ORIGINAL PC STATE AGENCY APPROVAL

IDENTIFICATION STAMP
 DIV. OF THE STATE ARCHITECT
 OFFICE OF REGULATION SERVICES

AC [Signature]
 DATE DEC 9 2011

REVISIONS

SILVER CREEK INDUSTRIES
 12' x 40' PC

PROJECT NO:
 DRAWN BY:
 SCALE: AS NOTED
 DATE: 6-17-11


P.C. SHEET NUMBER
A-2.03

STKP 125


T-BAR SCHEDULE

ARMSTRONG PART NUMBERS PA-041
 MAIN RUNNER: 7301
 4" CROSS TEE: XL7341
 2" CROSS TEE: XL7328

STANDARD 7/8" WALL ANGLE WITH BERG-2 CLIP (CC #ESR-1308) 2" WALL ANGLE: 7510 (OPTIONAL)

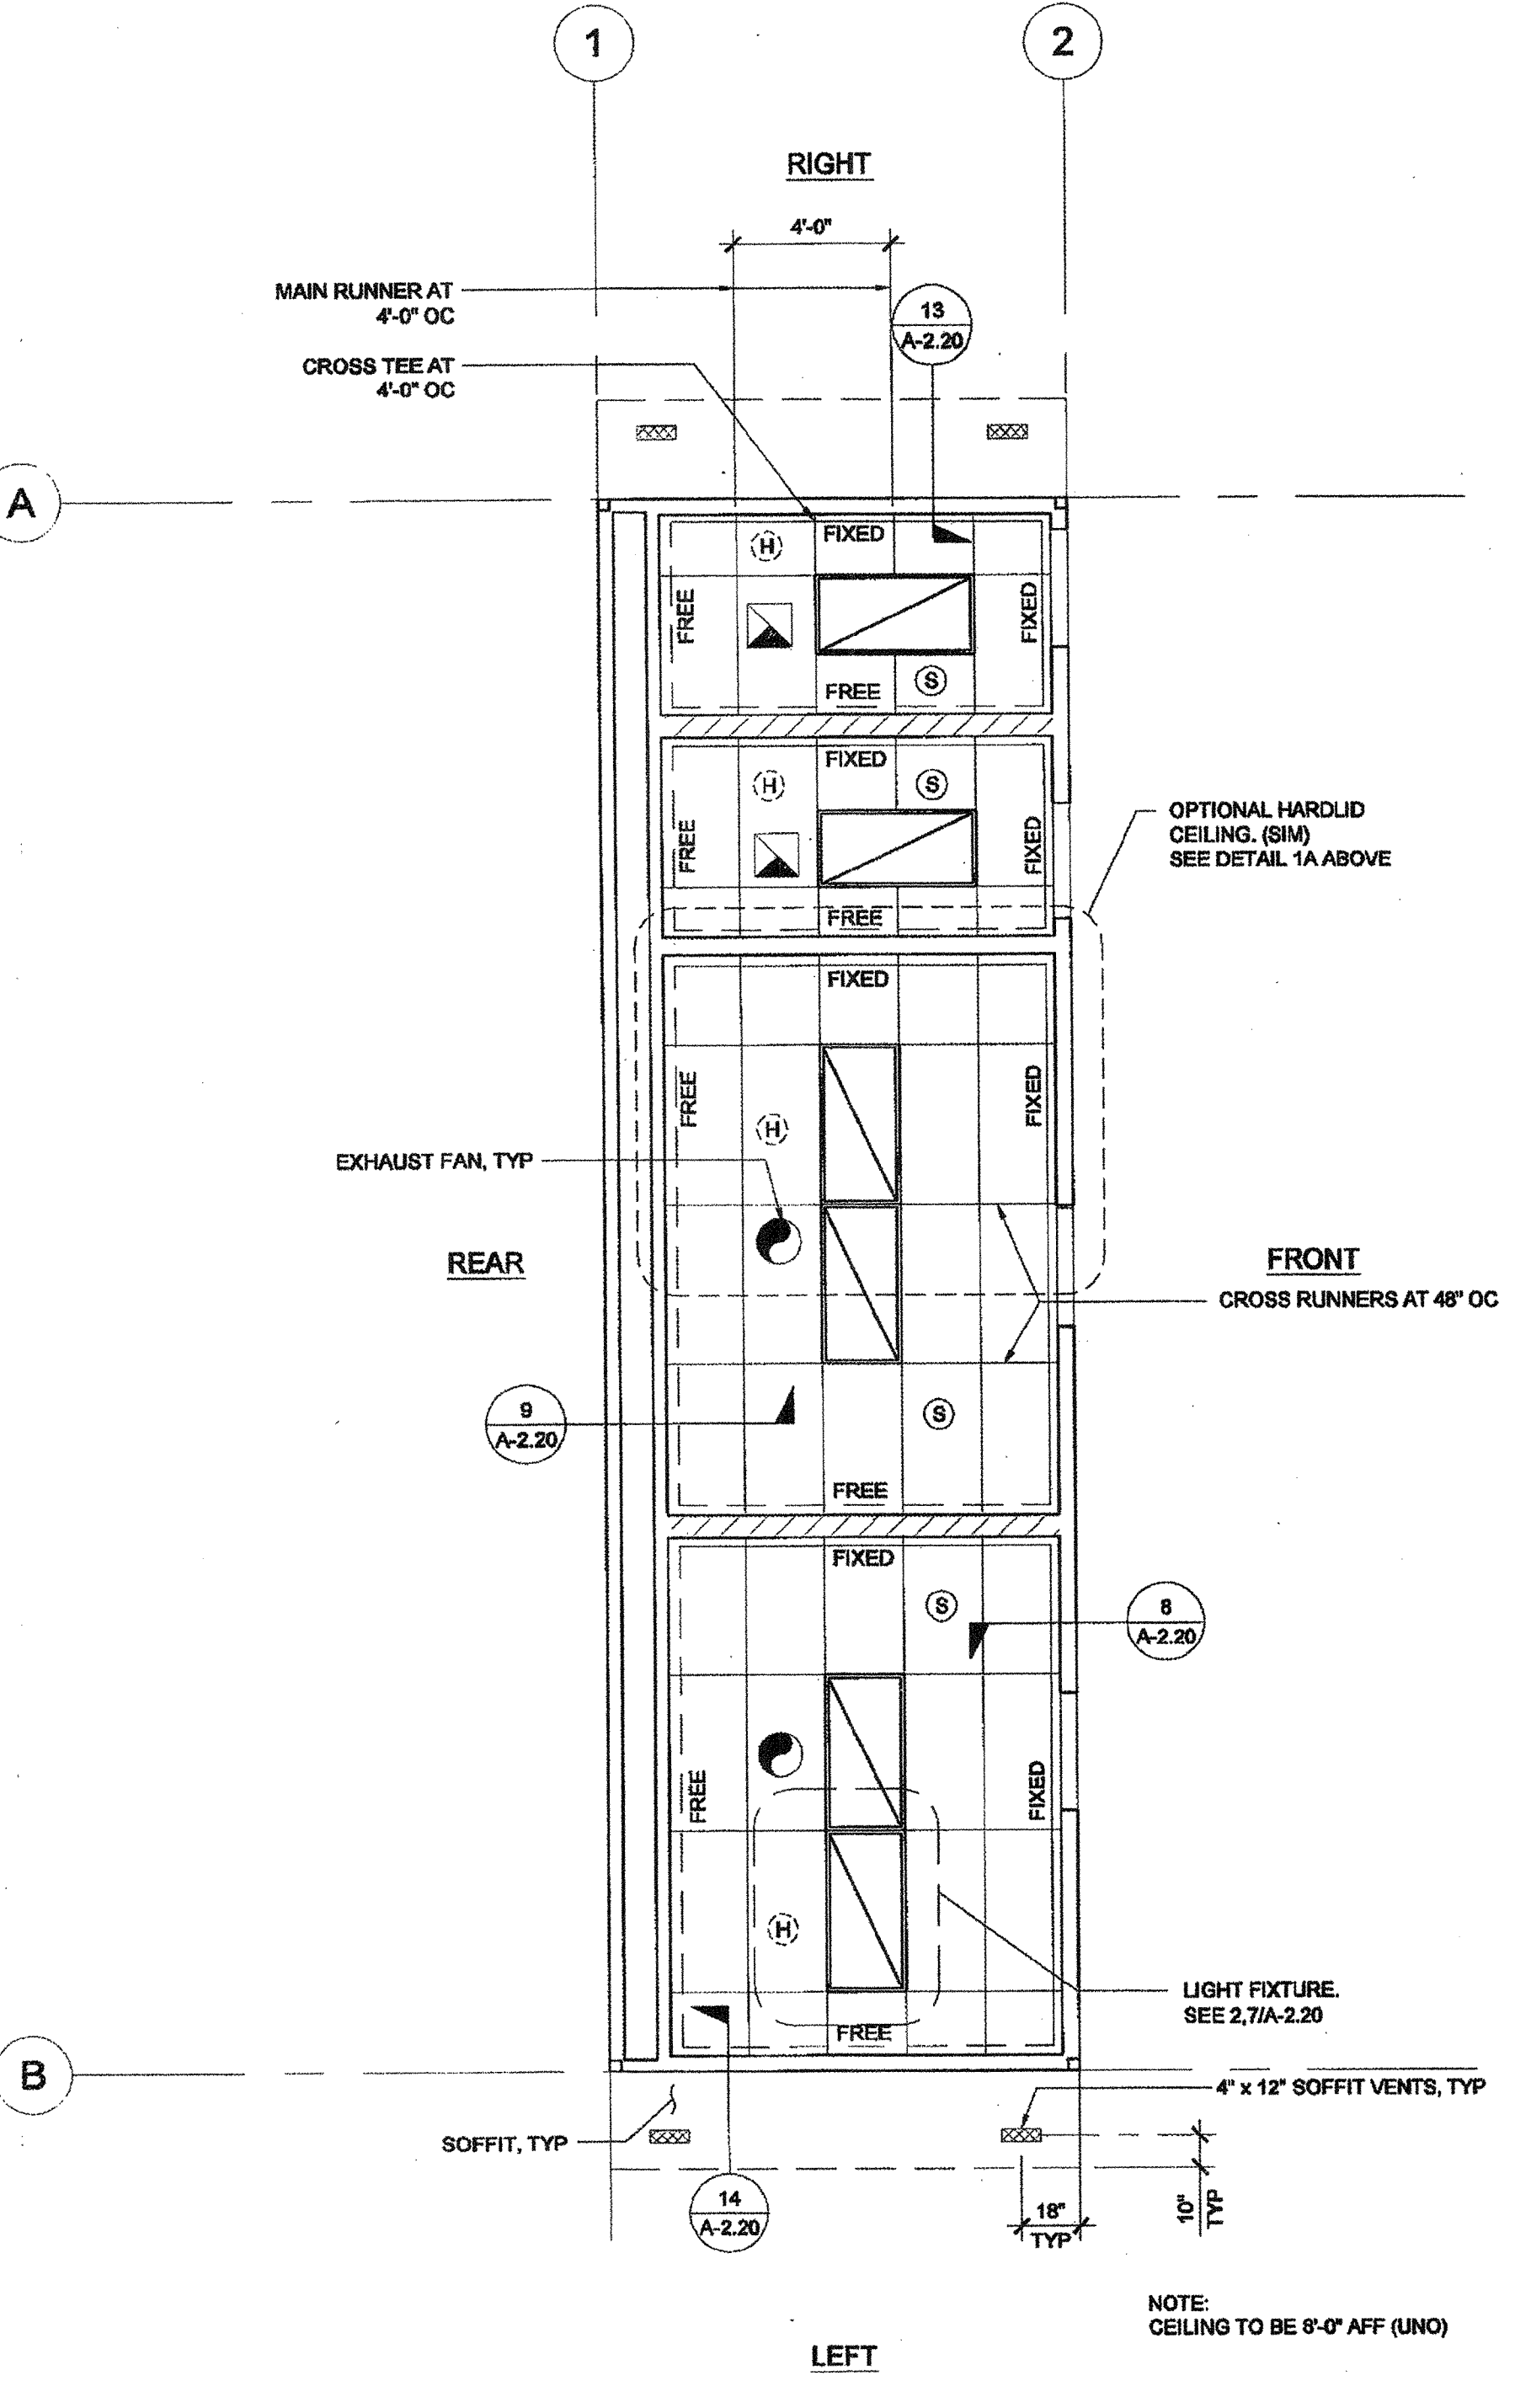

SCALE: 1/4" = 1'-0"

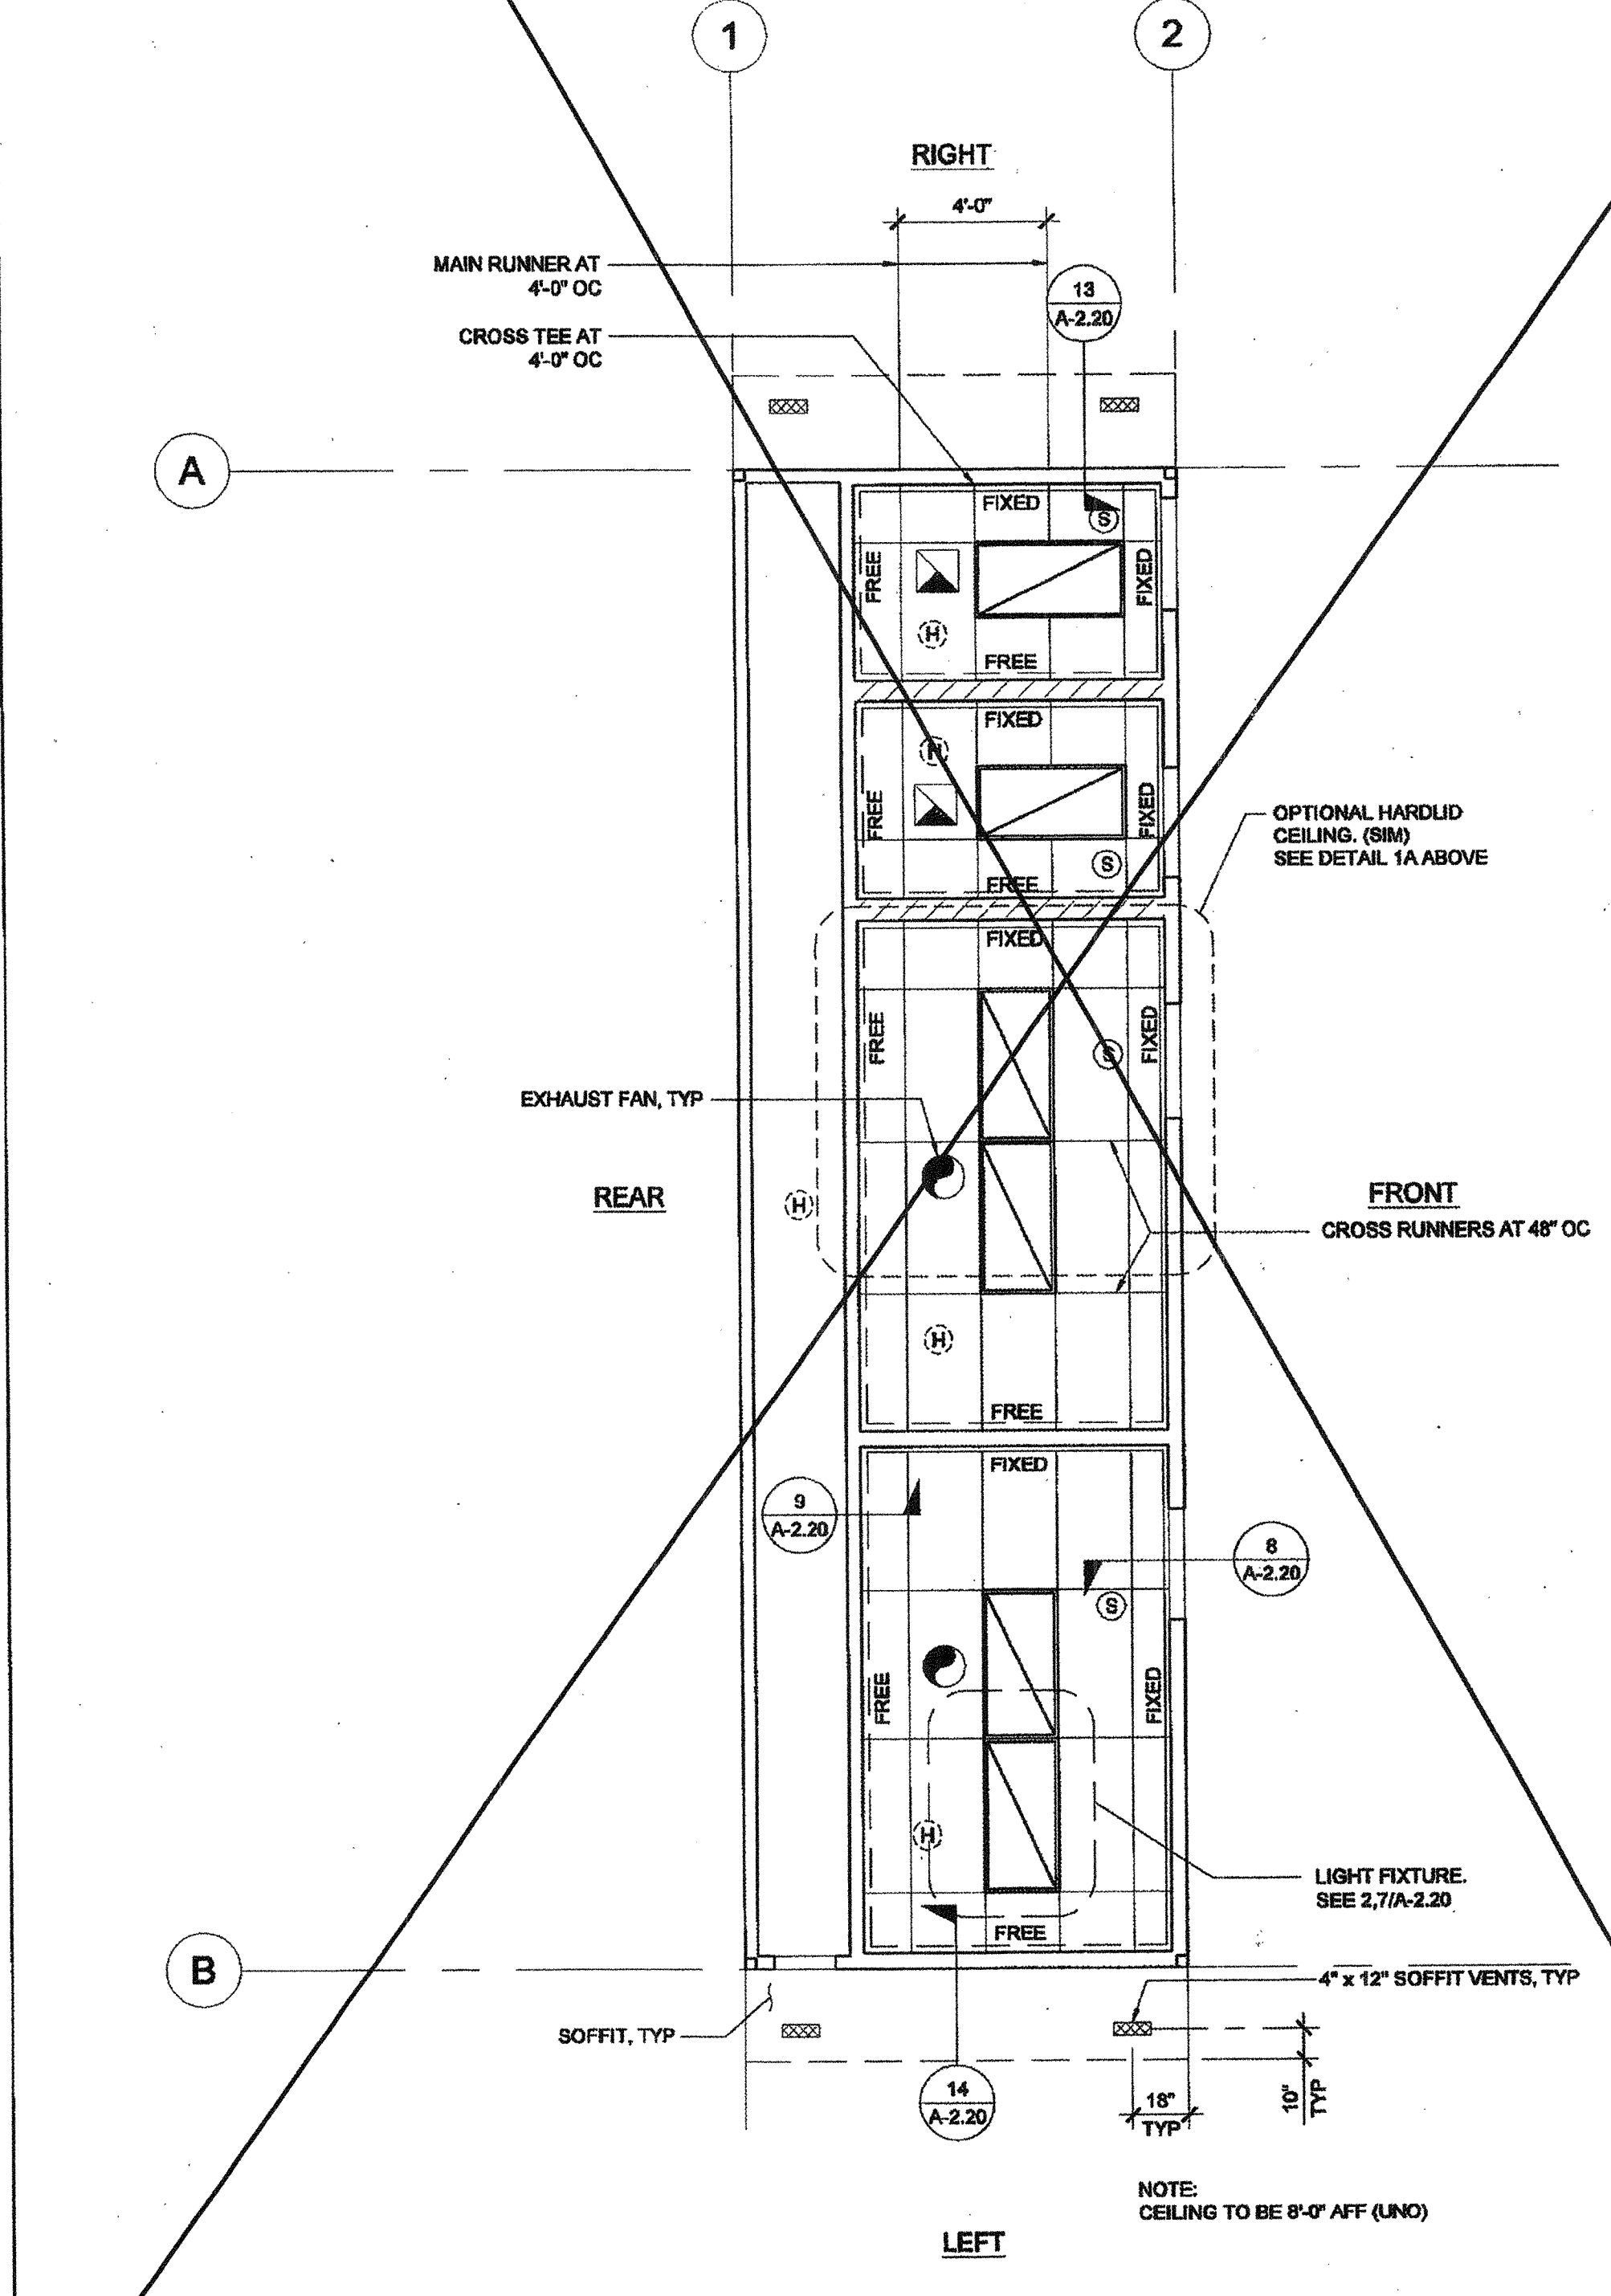

SCALE: 1/4" = 1'-0"

REFLECTED CEILING PLAN - MODEL C-2

REFLECTED CEILING PLAN - MODEL C-1