




NOTE: ALL FIXTURES SHALL HAVE SHUT-OFF VALVES
 TYPE "L" COPPER
 MAX. DEV. LENGTH = 40 FT.
 PRESSURE RANGE = 40 TO 60 PSI

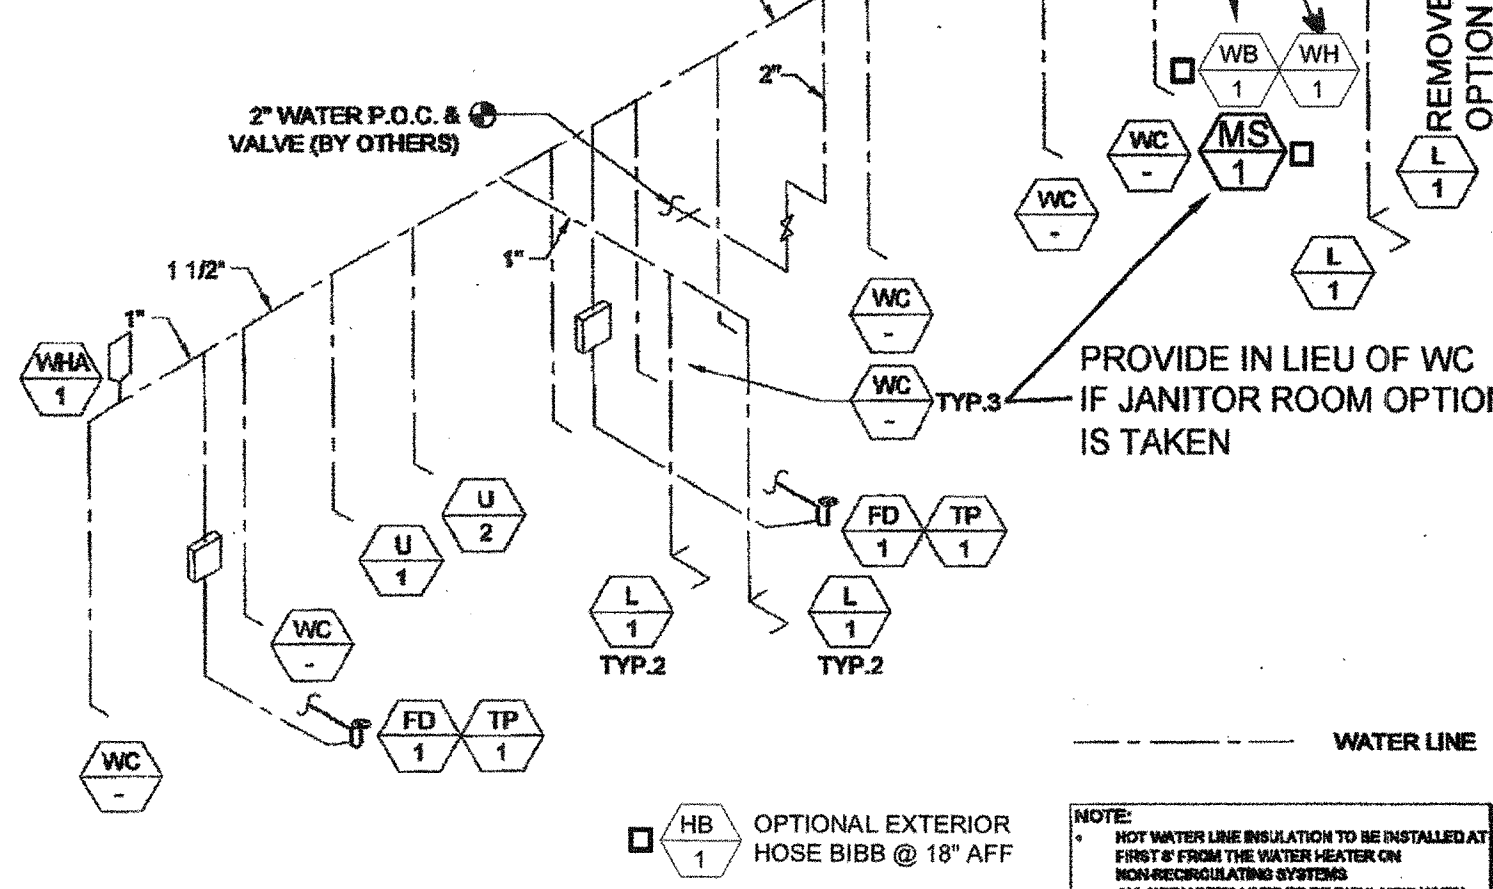


MODEL C-2
 SUPPLY ISOMETRIC - FLOOR AND WALL MOUNT
 SCALE: N.T.S. 8

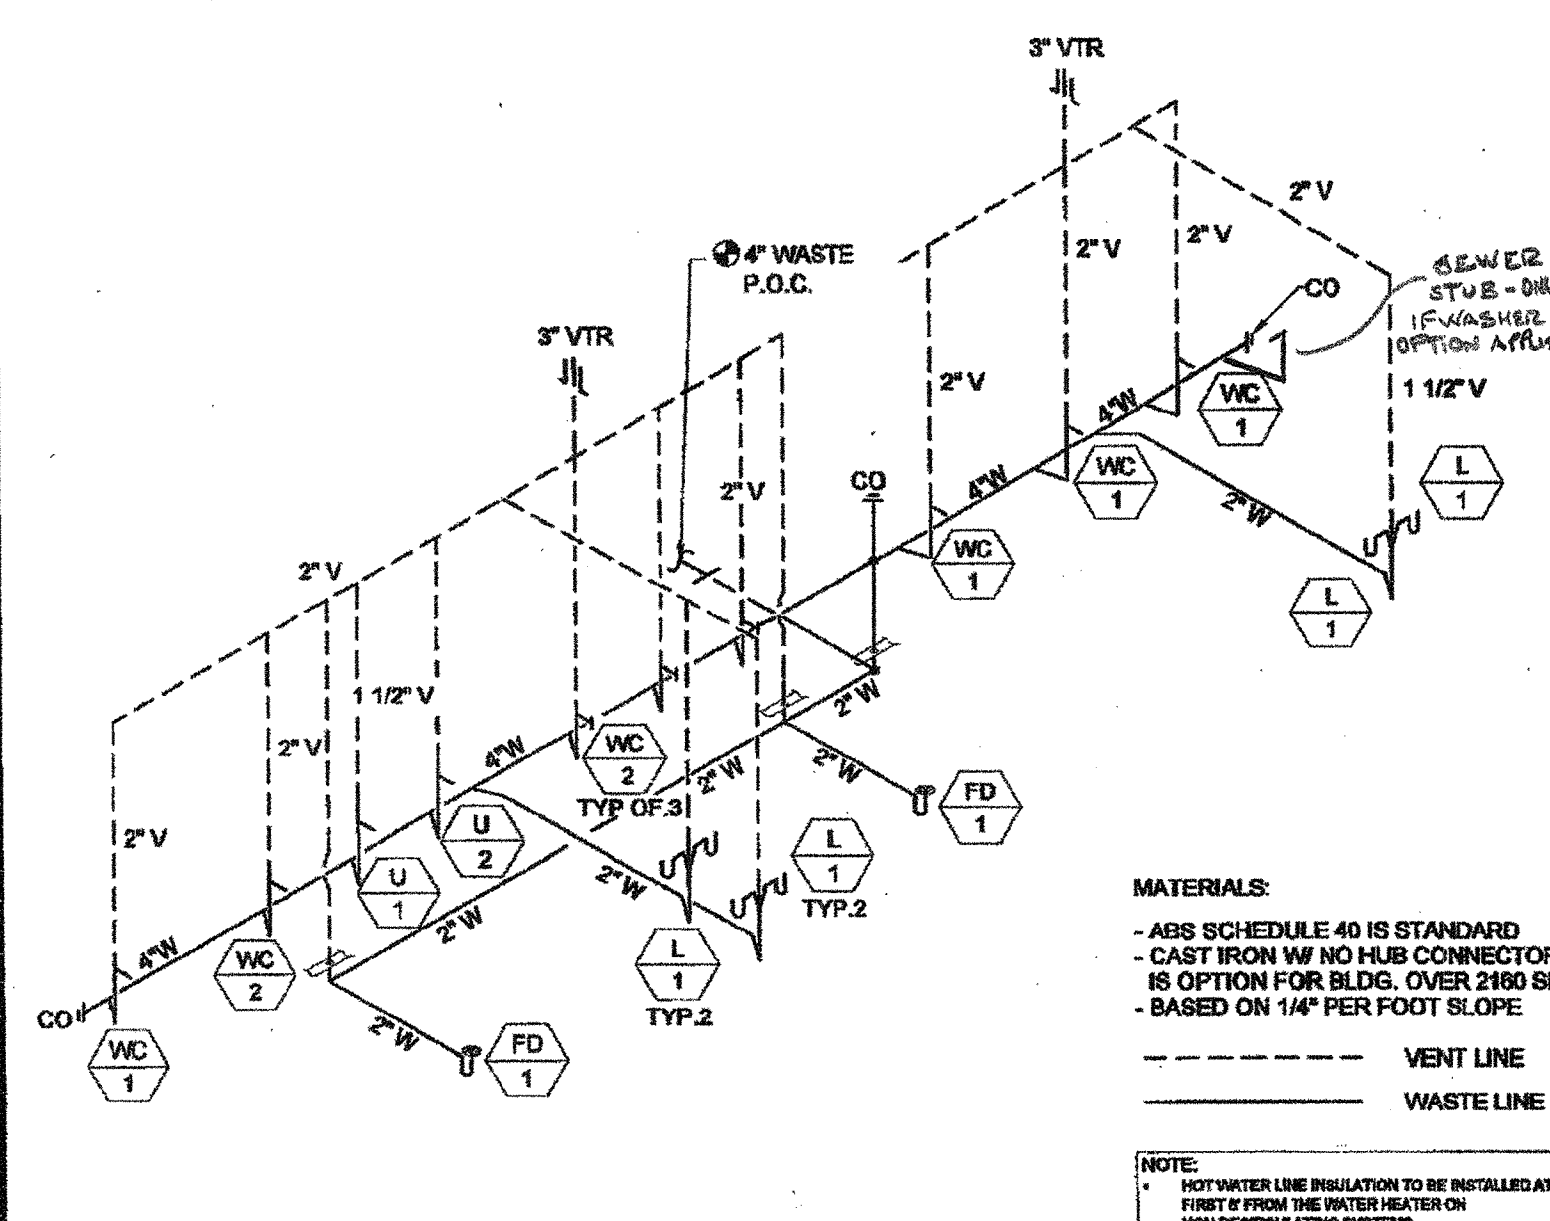


MODEL C-2
 WASTE AND VENTING ISOMETRIC - WALL MOUNT
 SCALE: N.T.S. 9

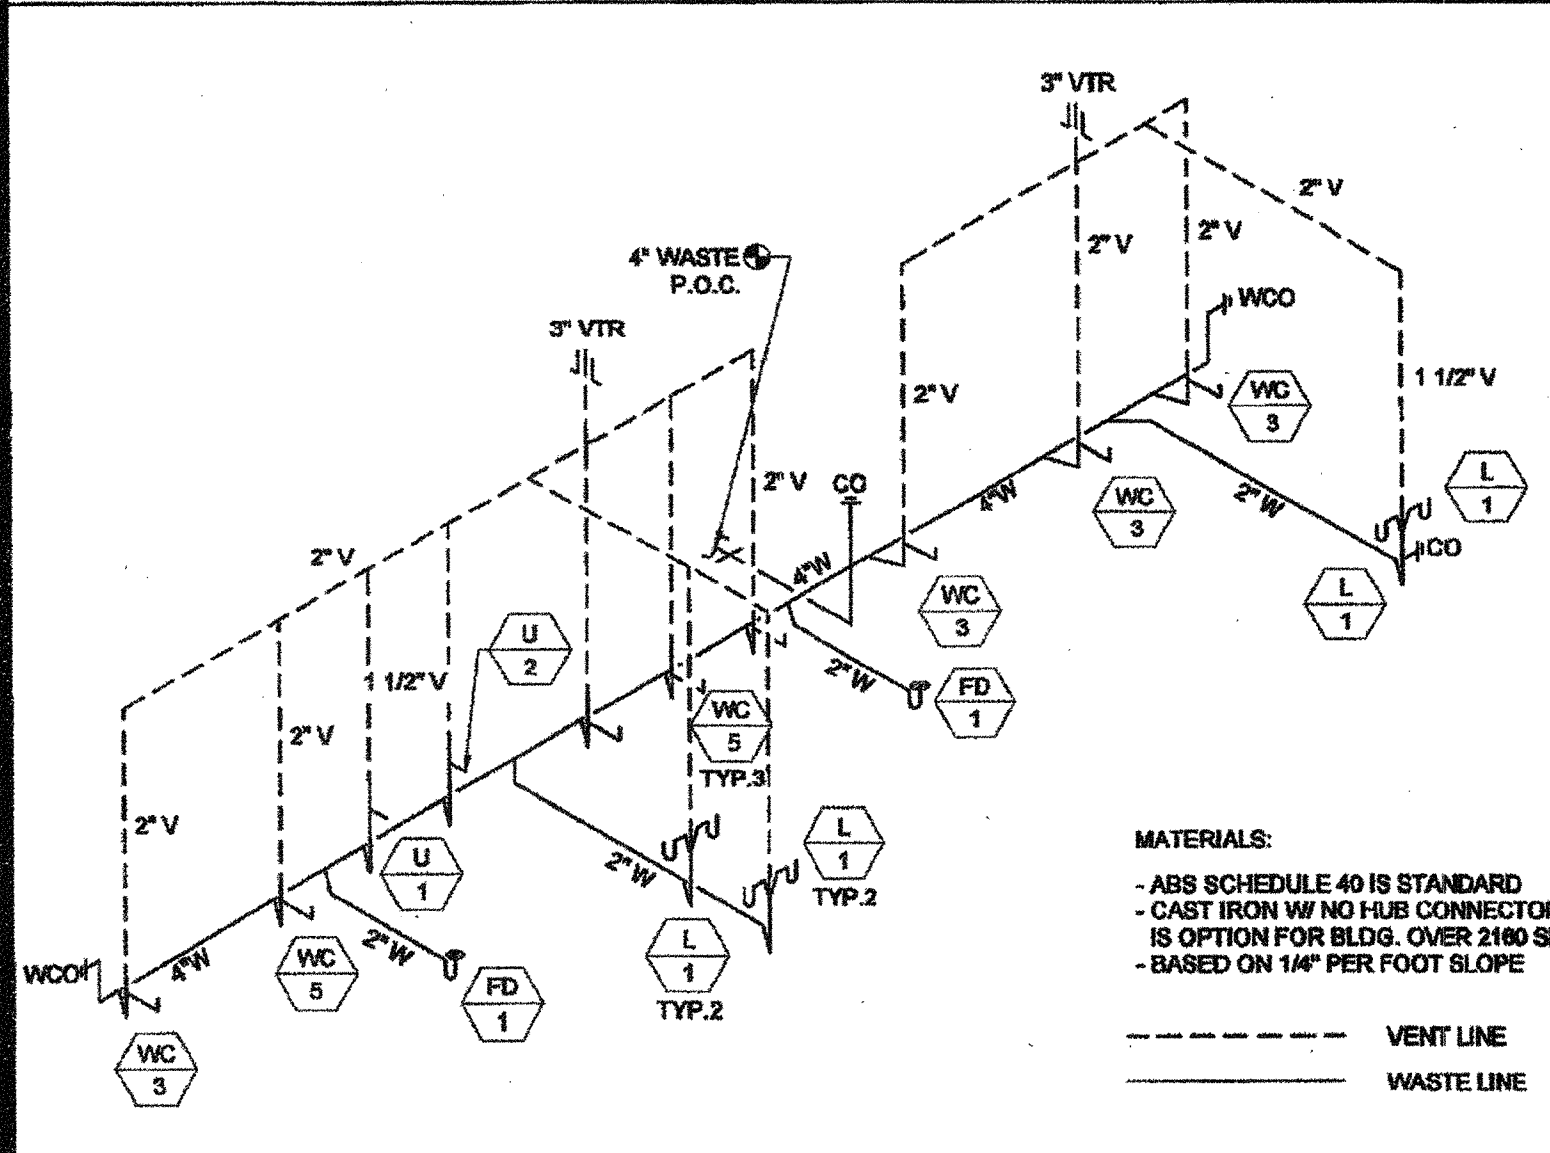


MODEL C-2
 WASTE AND VENTING ISOMETRIC - FLOOR MOUNT
 SCALE: N.T.S. 10

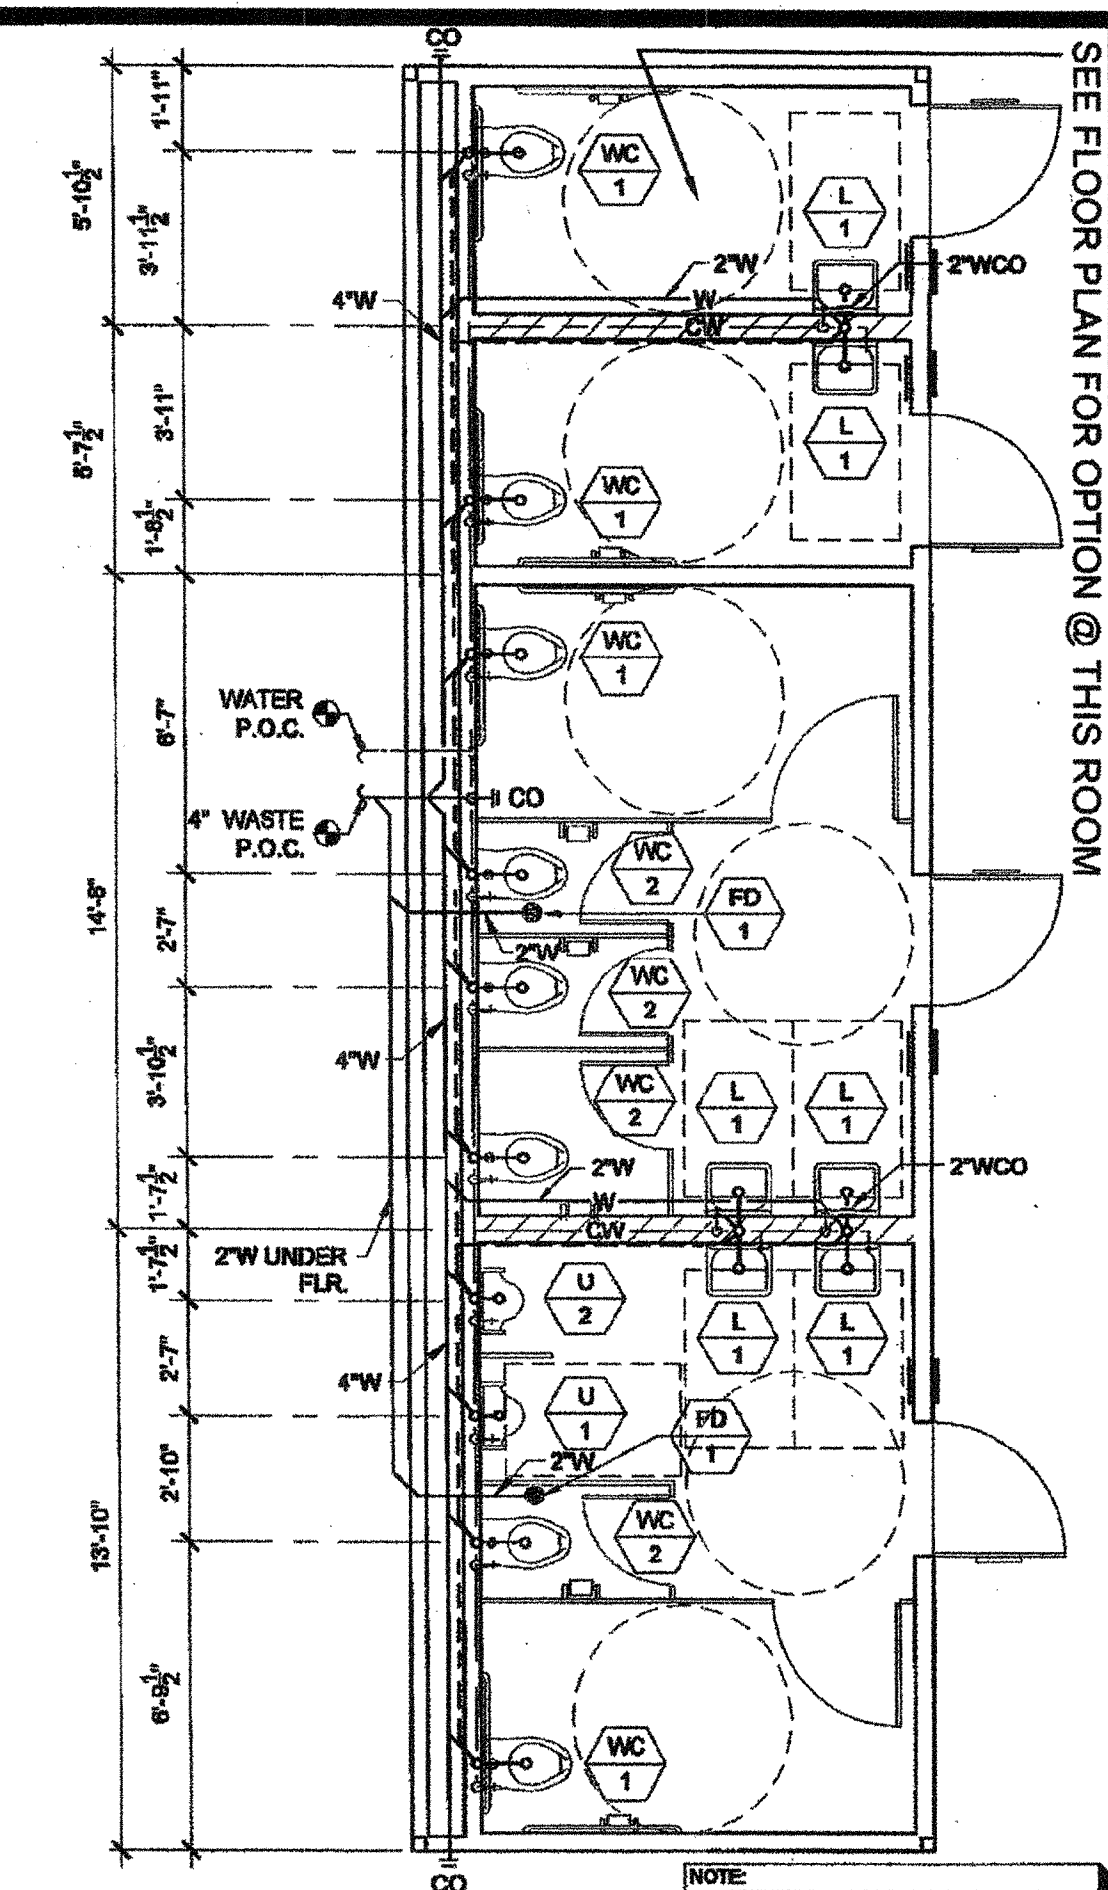


WALL MOUNT - MODEL C-2
 PLUMBING PLAN
 SCALE: 1/4" = 1'-0" 6

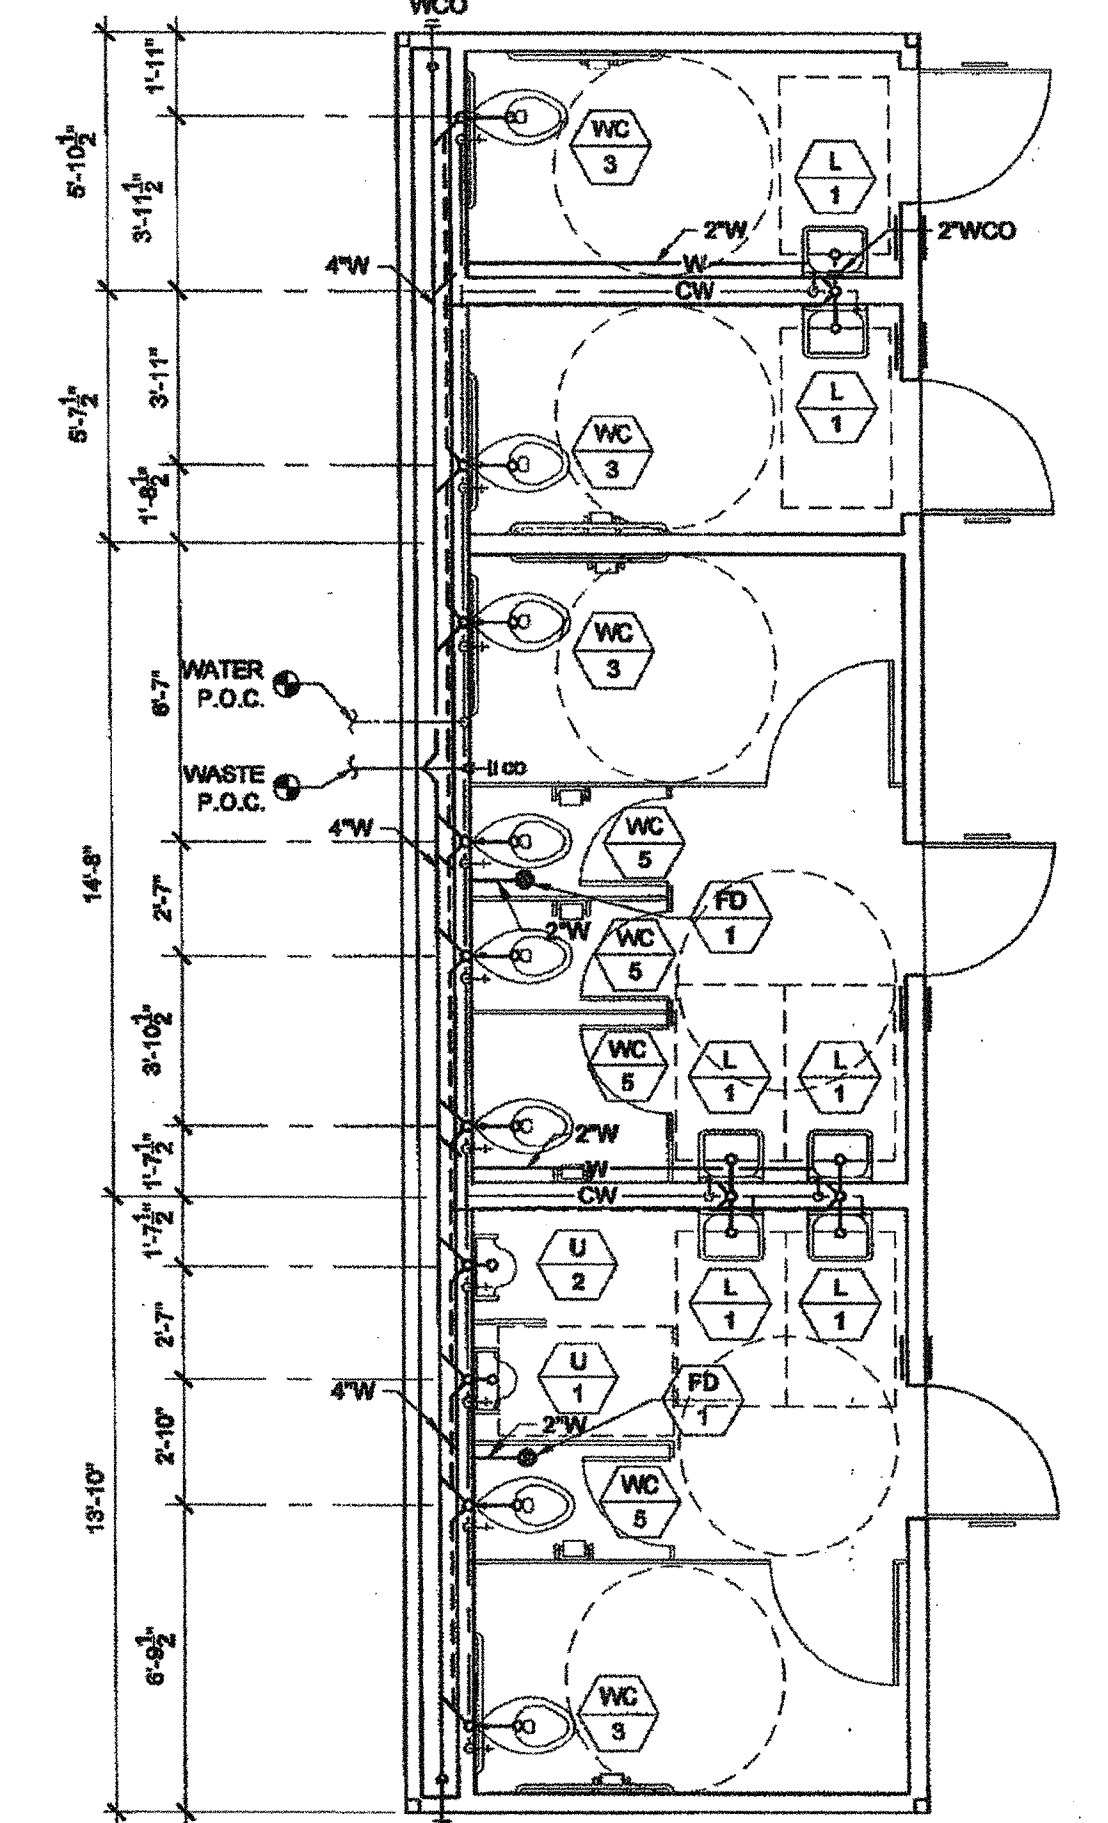


FLOOR MOUNT - MODEL C-2
 PLUMBING PLAN
 SCALE: 1/4" = 1'-0" 7

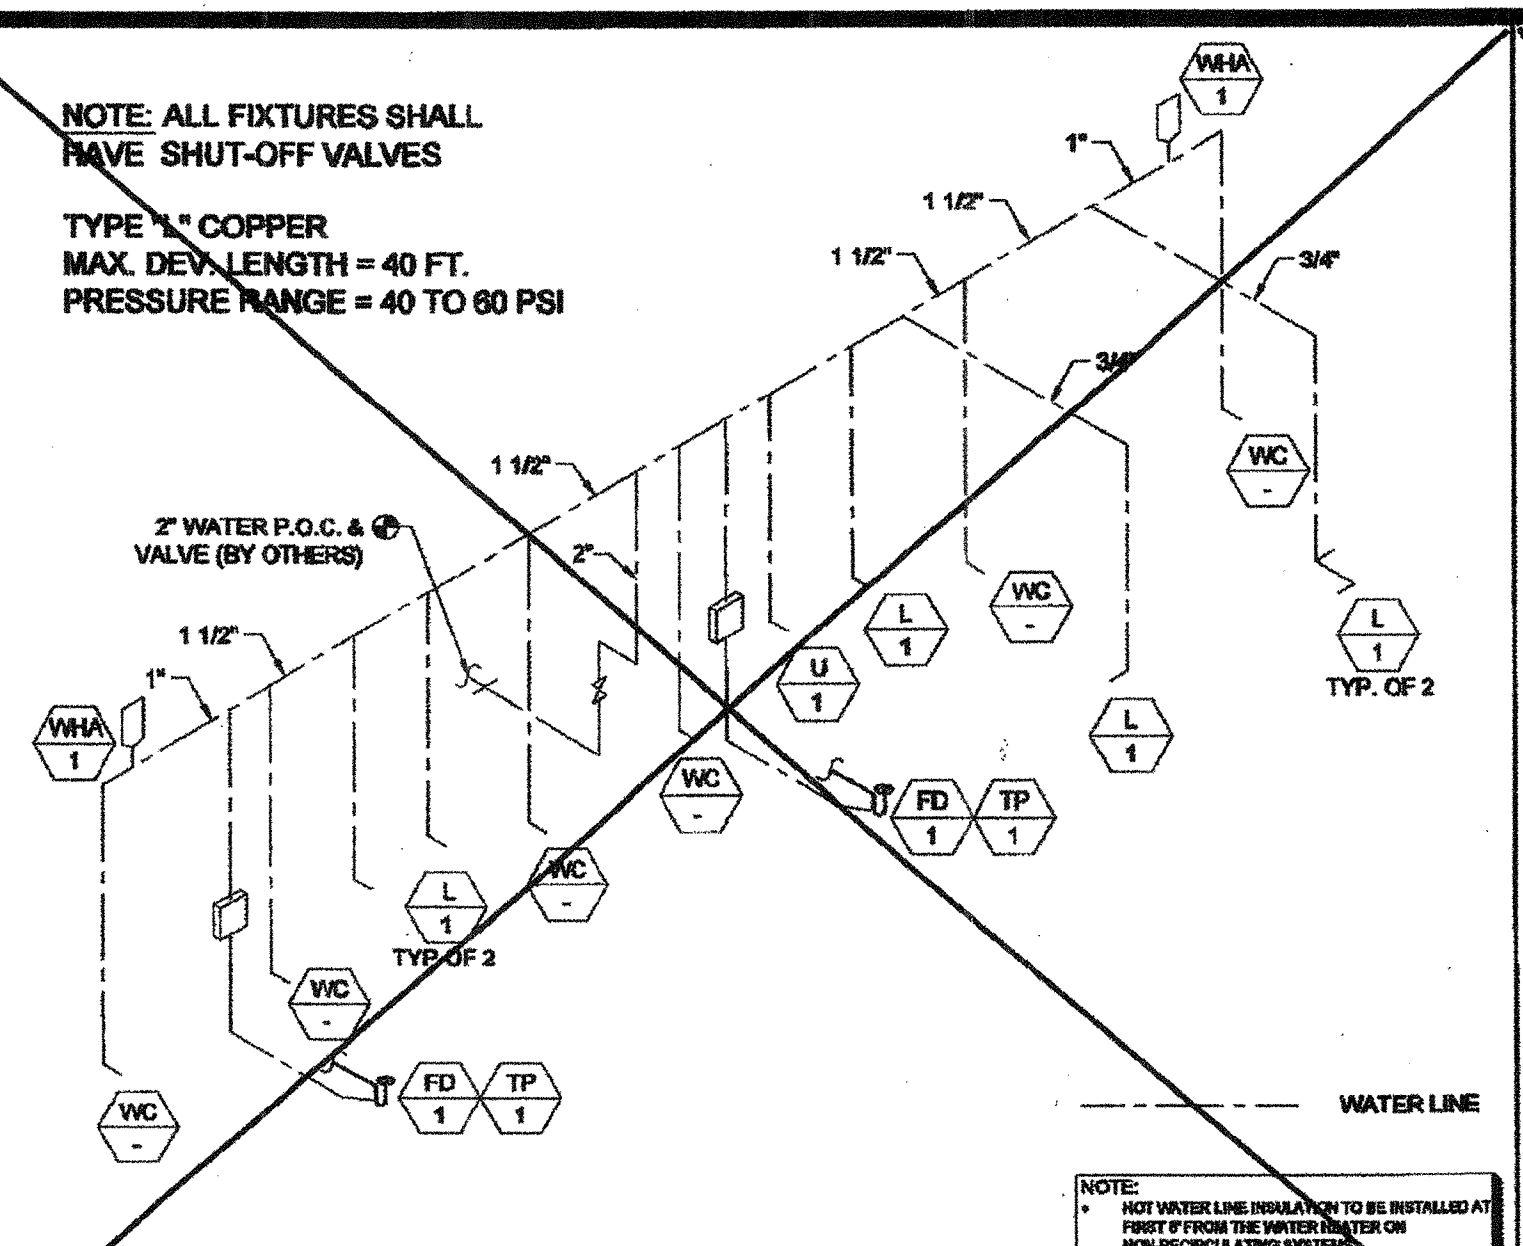


MODEL C-1
 SUPPLY ISOMETRIC - FLOOR AND WALL MOUNT
 SCALE: N.T.S. 3

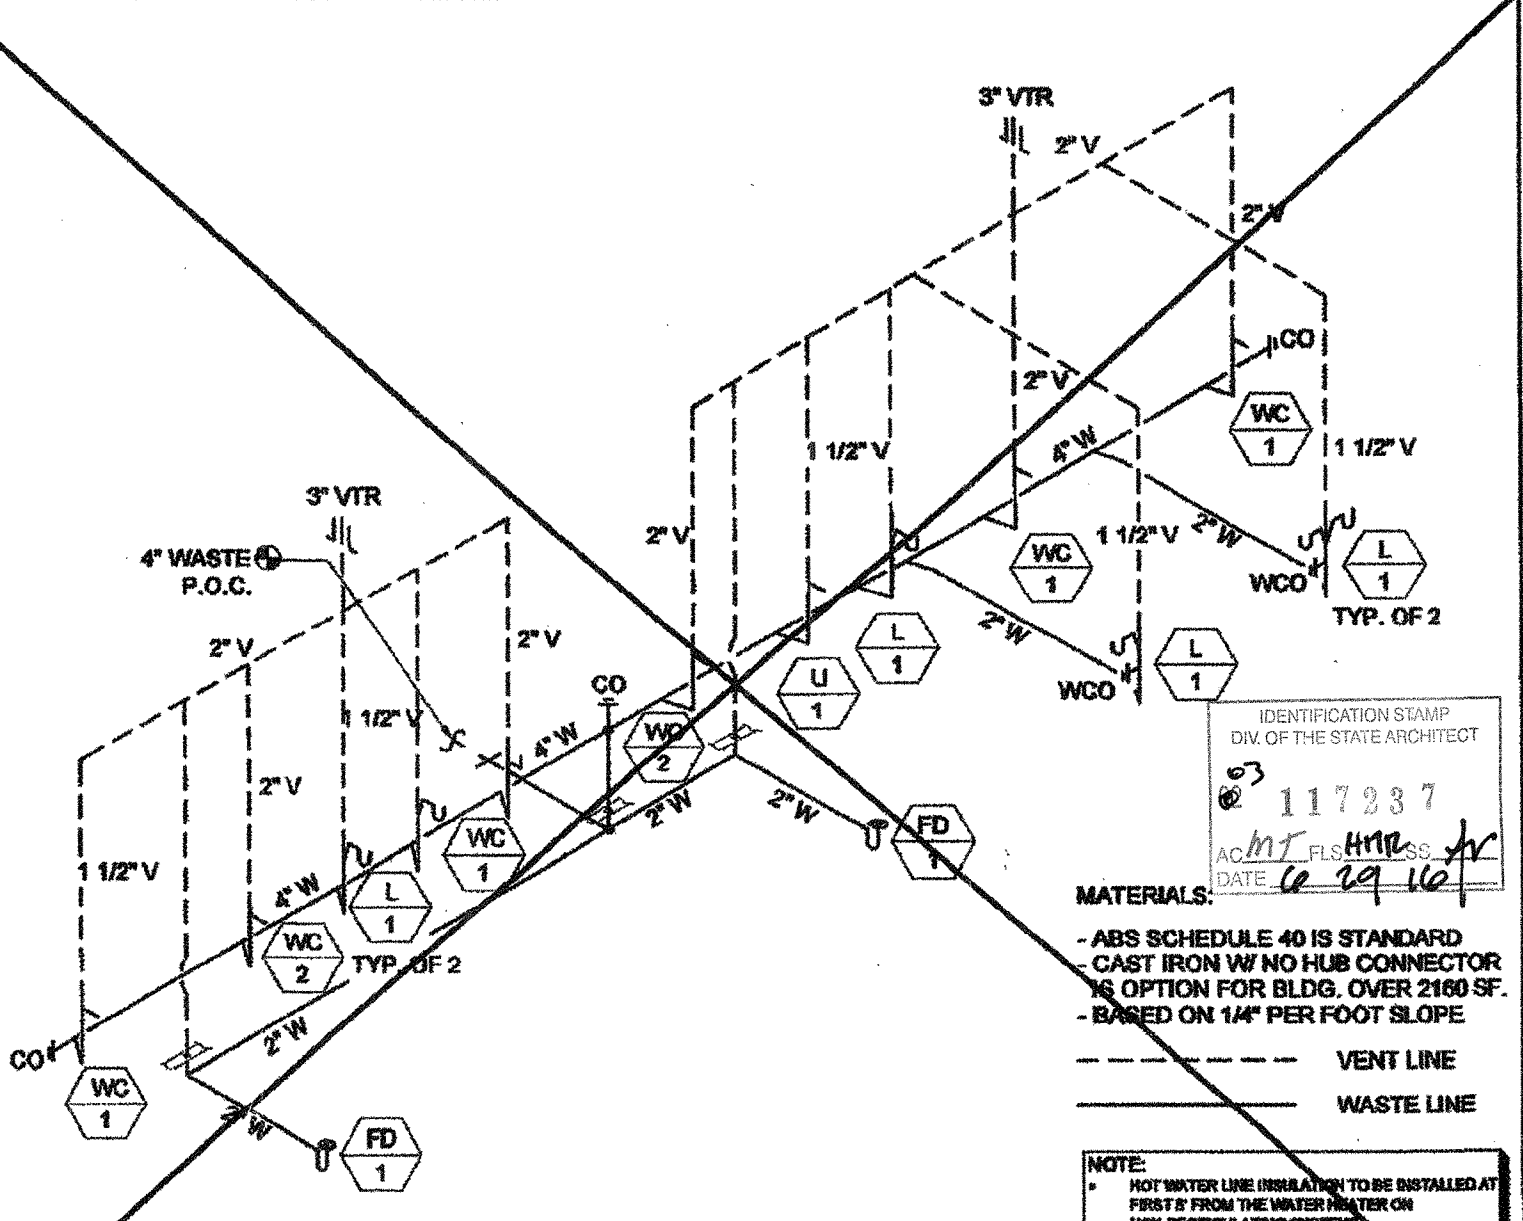


MODEL C-1
 WASTE AND VENTING ISOMETRIC - WALL MOUNT
 SCALE: N.T.S. 4

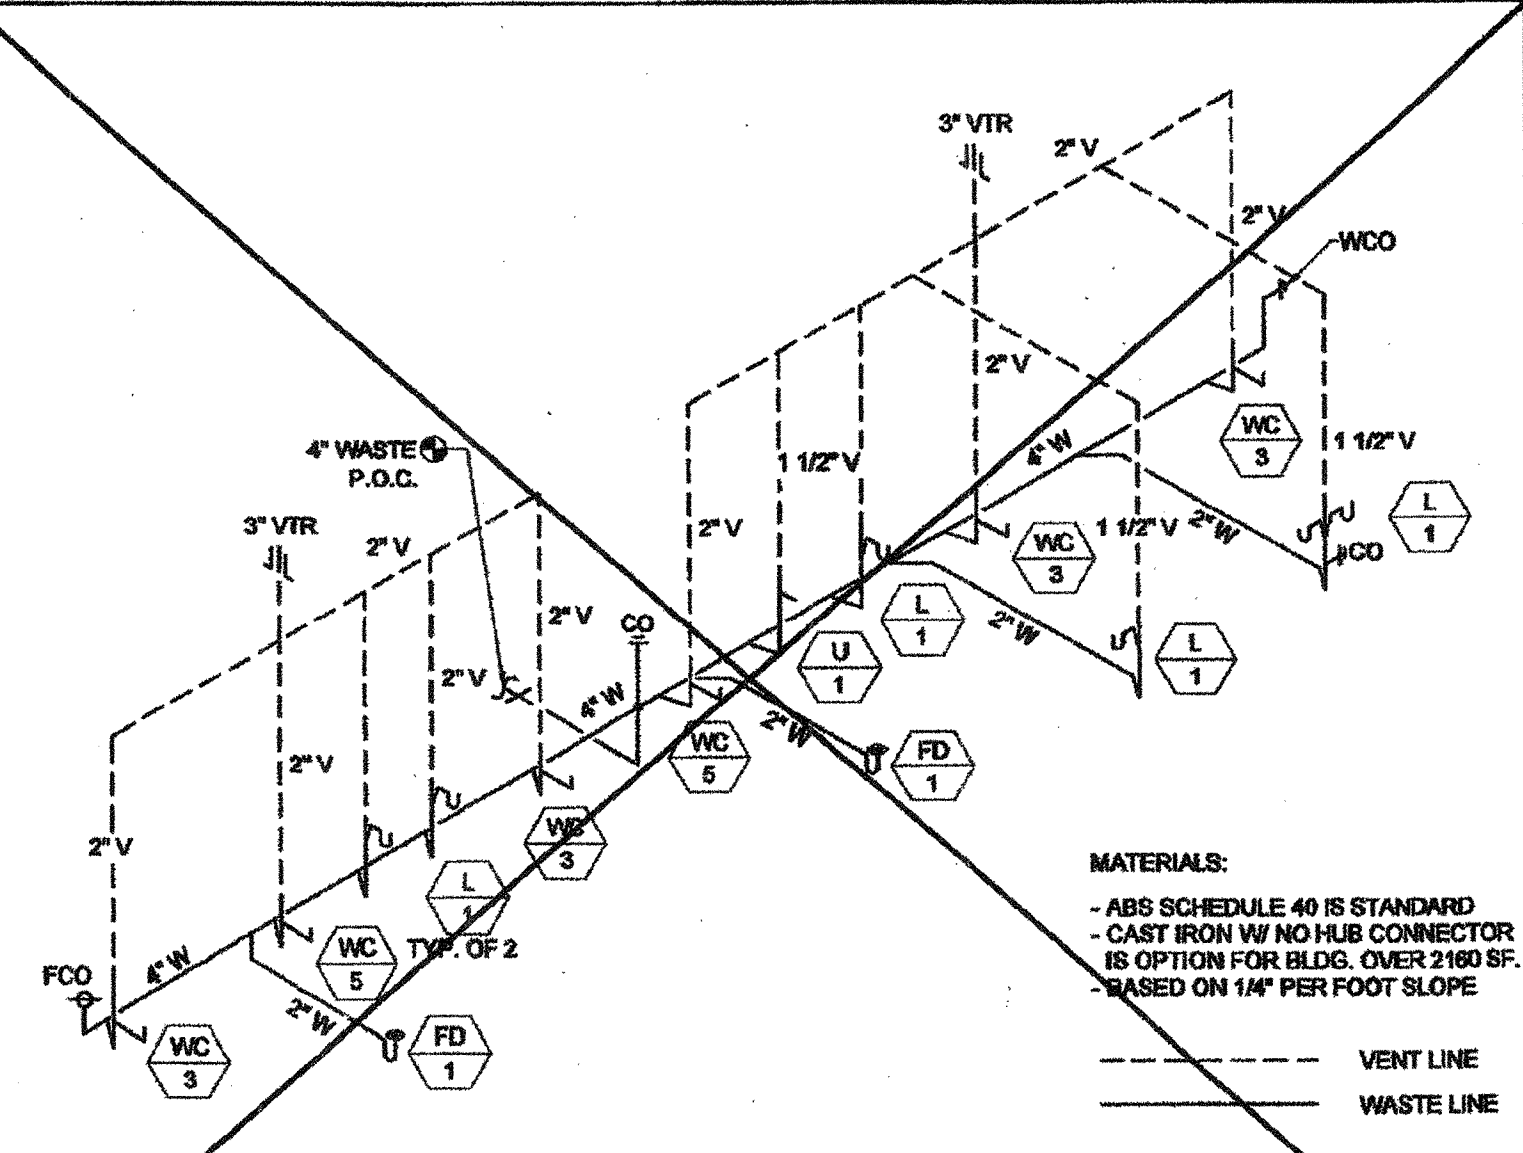

MODEL C-1
 WASTE AND VENTING ISOMETRIC - FLOOR MOUNT
 SCALE: N.T.S. 5

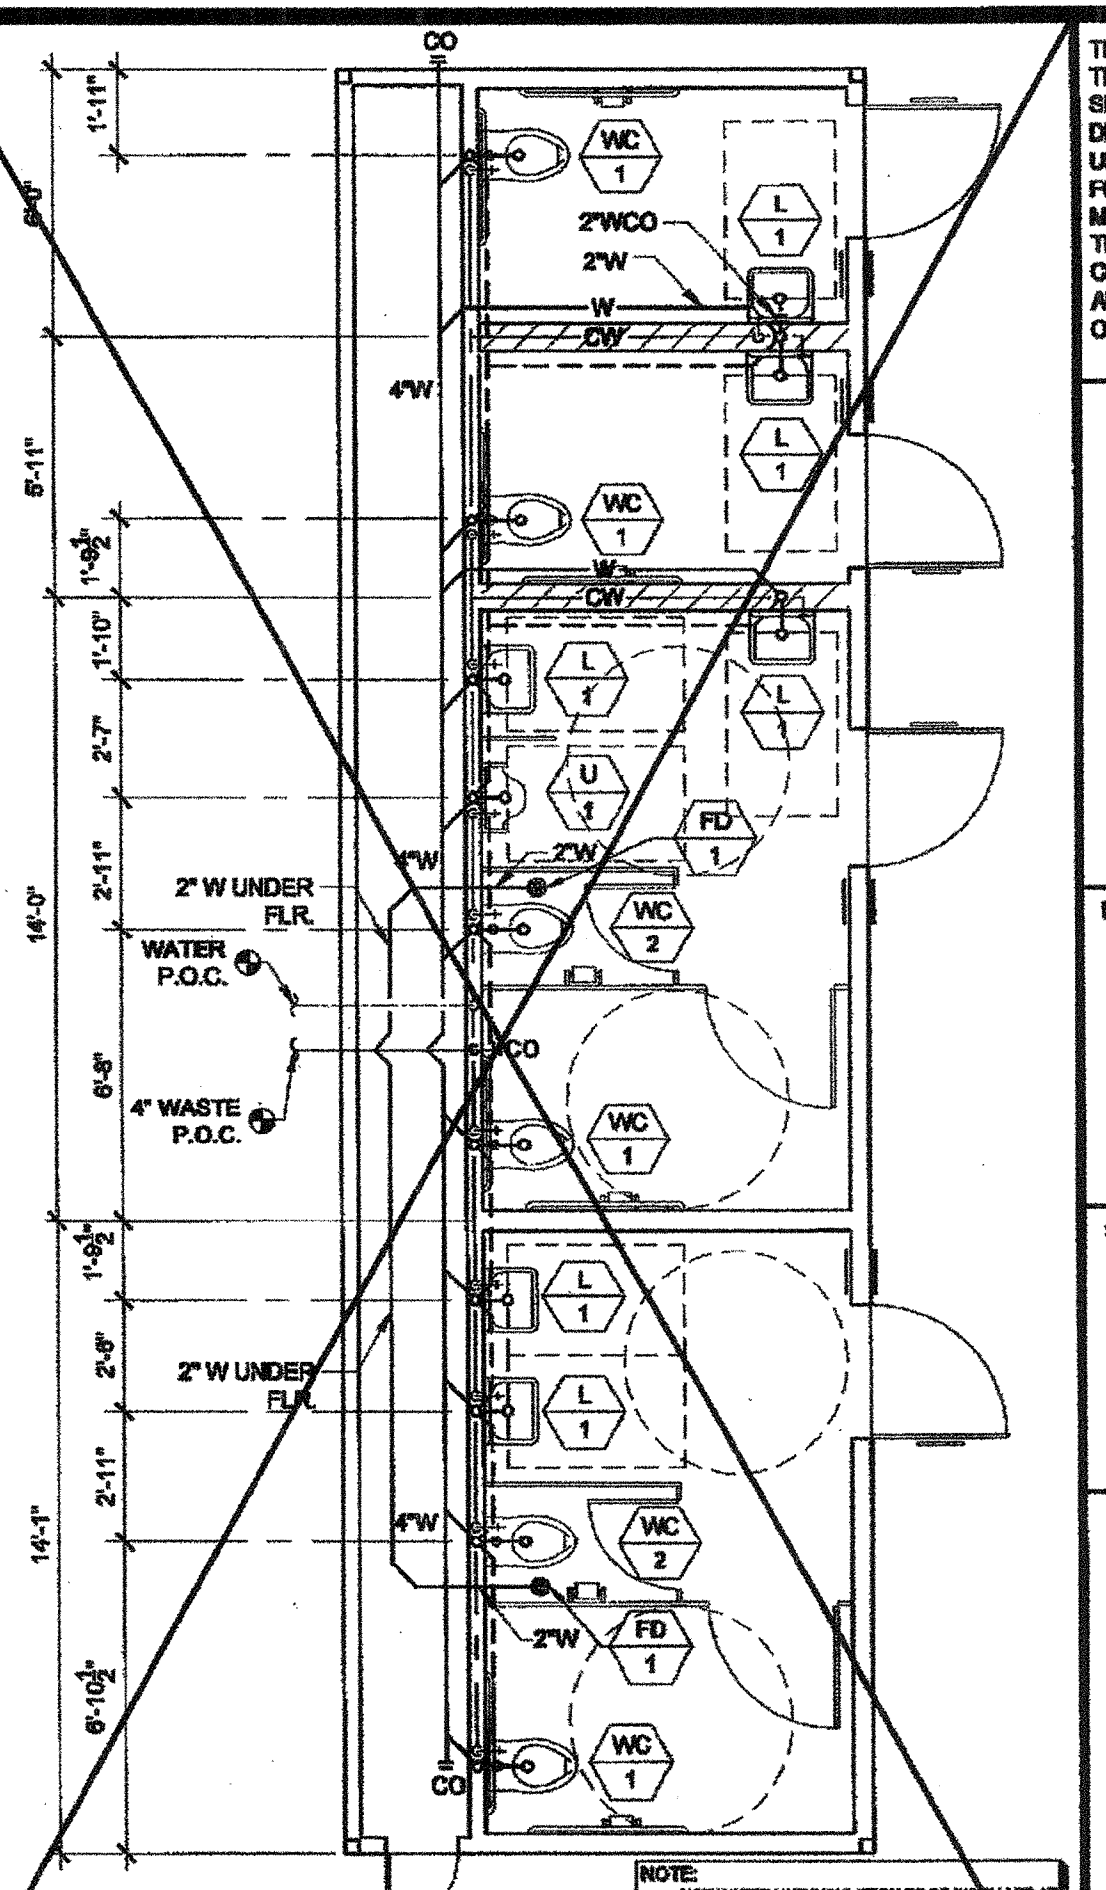

WALL MOUNT - MODEL C-1
 PLUMBING PLAN
 SCALE: 1/4" = 1'-0" 1

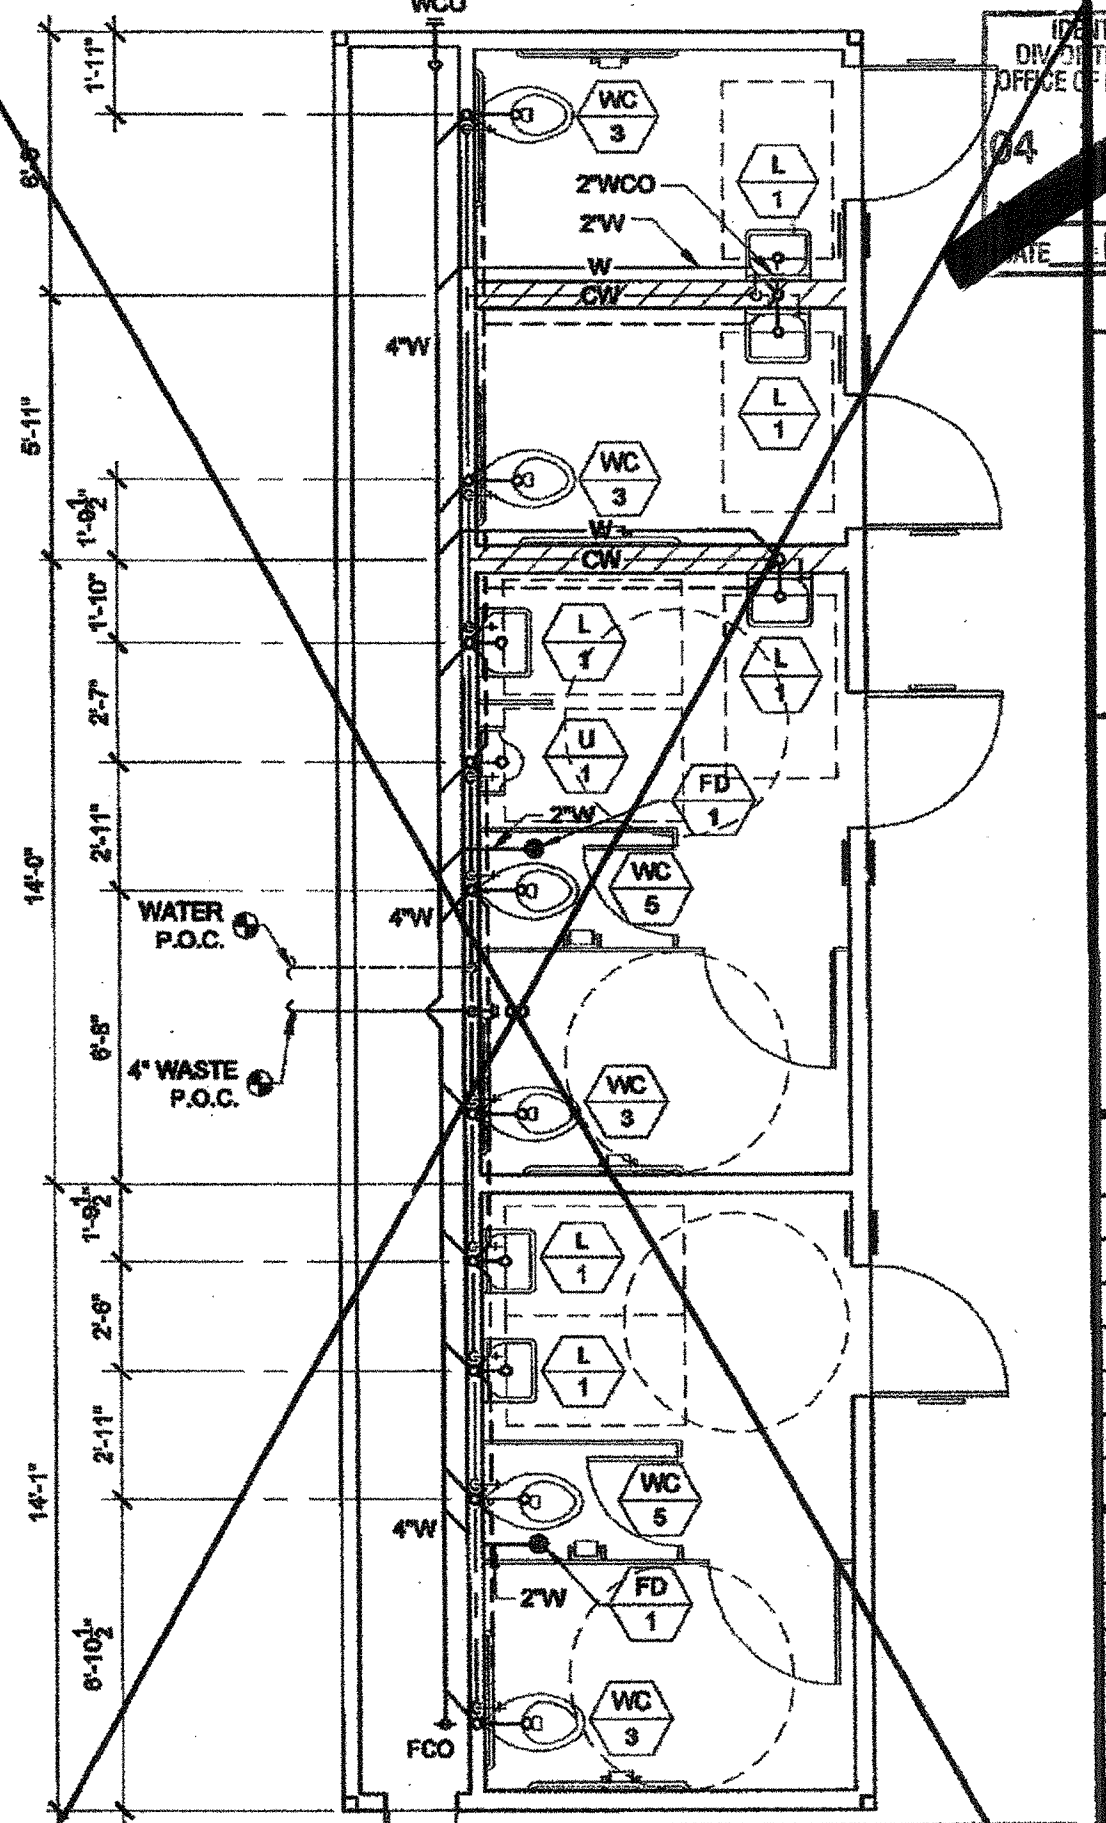

FLOOR MOUNT - MODEL C-1
 PLUMBING PLAN
 SCALE: 1/4" = 1'-0" 2

THESE DRAWINGS AND ALL MATERIAL CONTAINED HEREIN ARE THE PROPERTY OF SILVERCREEK INDUSTRIES, INC (SCI Inc) AND SHALL NOT BE REPRODUCED, COPIED OR OTHERWISE DISPOSED OF DIRECTLY OR INDIRECTLY AND SHALL NOT BE USED IN WHOLE OR IN PART TO ASSIST IN THE MAKING OF OR FOR THE PURPOSE OF FURNISHING ANY INFORMATION FOR THE MAKING OF DRAWINGS, PRINTS, APPARATUS OR PARTS THEREOF WITHOUT THE FULL KNOWLEDGE AND WRITTEN CONSENT OF SCI Inc. ALL PATENTABLE MATERIAL CONTAINED HEREIN AND ORIGINATING WITH SCI Inc SHALL BE THE PROPERTY OF SCI Inc.

SILVER CREEK INDUSTRIES, INC.
 "BUILDING FOR THE NEXT GENERATION"
SILVER CREEK
 195 EAST MORGAN PERRIS, CALIFORNIA 92571
 PHONE: 951-943-5313 FAX: 951-943-2211

PROJECT NAME:
CLASS LEASING

SHEET TITLE:
PLUMBING PLAN AND ISOMETRICS MODEL G-1 OR C-2 "ADULT"

STAVARES ASSOCIATES
 ARCHITECT OF RECORD
 1223/2011

ARCHITECT OF RECORD SUBMISSION
 IDENTIFICATION STAMP
 DIV. OF THE STATE ARCHITECTS OFFICE OF REGULATION SERVICES
 04 117937
 DATE AUG 28 2011

PROJECT SPECIFIC STATE AGENCY APPROVAL
 IDENTIFICATION STAMP
 DIV. OF THE STATE ARCHITECTS OFFICE OF REGULATION SERVICES
 04 117951
 DATE AUG 28 2011

ORIGINAL PC STATE AGENCY APPROVAL
 IDENTIFICATION STAMP
 DIV. OF THE STATE ARCHITECTS OFFICE OF REGULATION SERVICES
 04 117937
 DATE DEC 2 2011

REVISIONS

SILVER CREEK INDUSTRIES
 12 x 40 FC
 PROJECT NO:
 DRAWN BY:
 SCALE: AS NOTED
 DATE: 8-17-11 11-19-14
 P.C. SHEET NUMBER
P-1.03A
 STKP 125