



P L A N A R E A

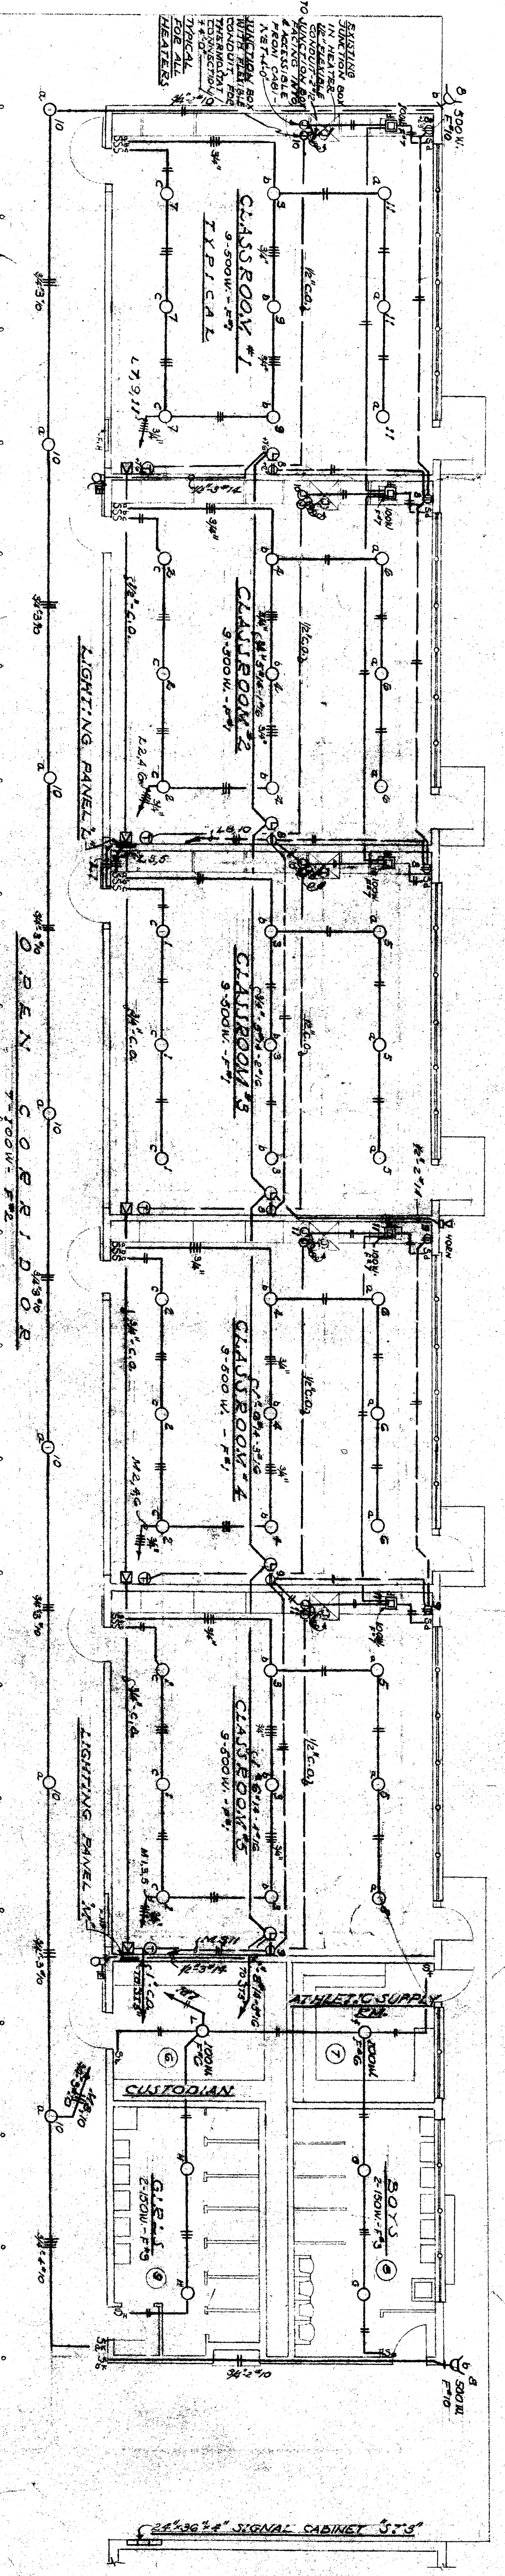

FLOOR PLAN - WING A

L A W N A R E A

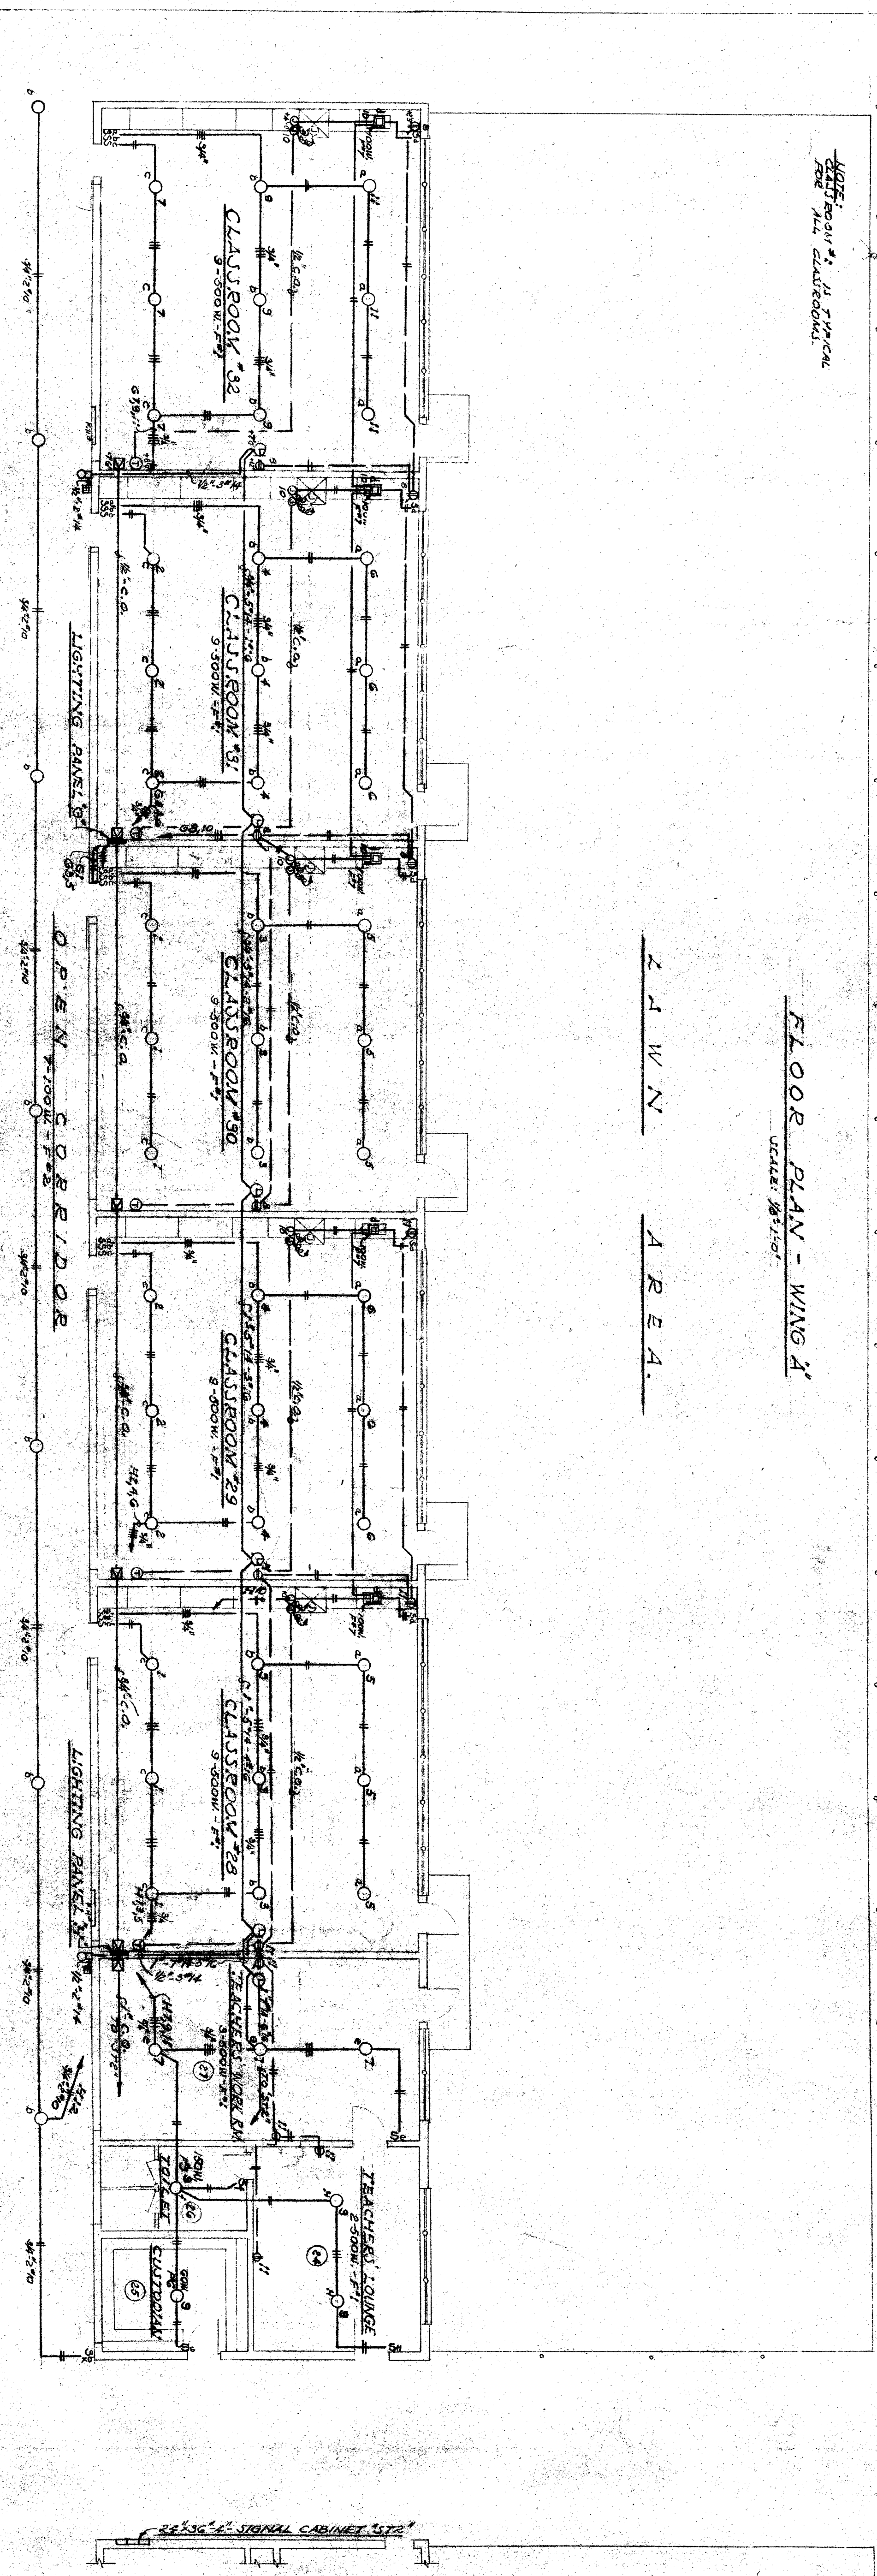

FLOOR PLAN - WING B

HILBURG, BYLER & HENGSTLER
MECHANICAL AND ELECTRICAL
ENGINEERS
257 SOUTH SPRING STREET
LOS ANGELES 12, CALIFORNIA

STATE OF CALIFORNIA
DEPARTMENT OF PUBLIC WORKS
DIVISION OF ARCHITECTURE
STATE OF CALIFORNIA DEPARTMENT OF PUBLIC WORKS
DIVISION OF ARCHITECTURE
APPROVED: 3-17-48
N O W E L B O W E N

SHERESFIELD CITY SCHOOLS
1600 F ST SHERESFIELD CALIF
BOARD OF EDUCATION
APPROVED: 3-17-48
SECRETARY

E L E C T R I C A L
SHERESFIELD CITY SCHOOL DISTRICT
1600 F ST SHERESFIELD CALIF
ARCHITECT
DATE

DATE
DESIGNED BY
CHECKED BY
DRAWN BY
E-4