


FLOOR PLAN - WING 'E'

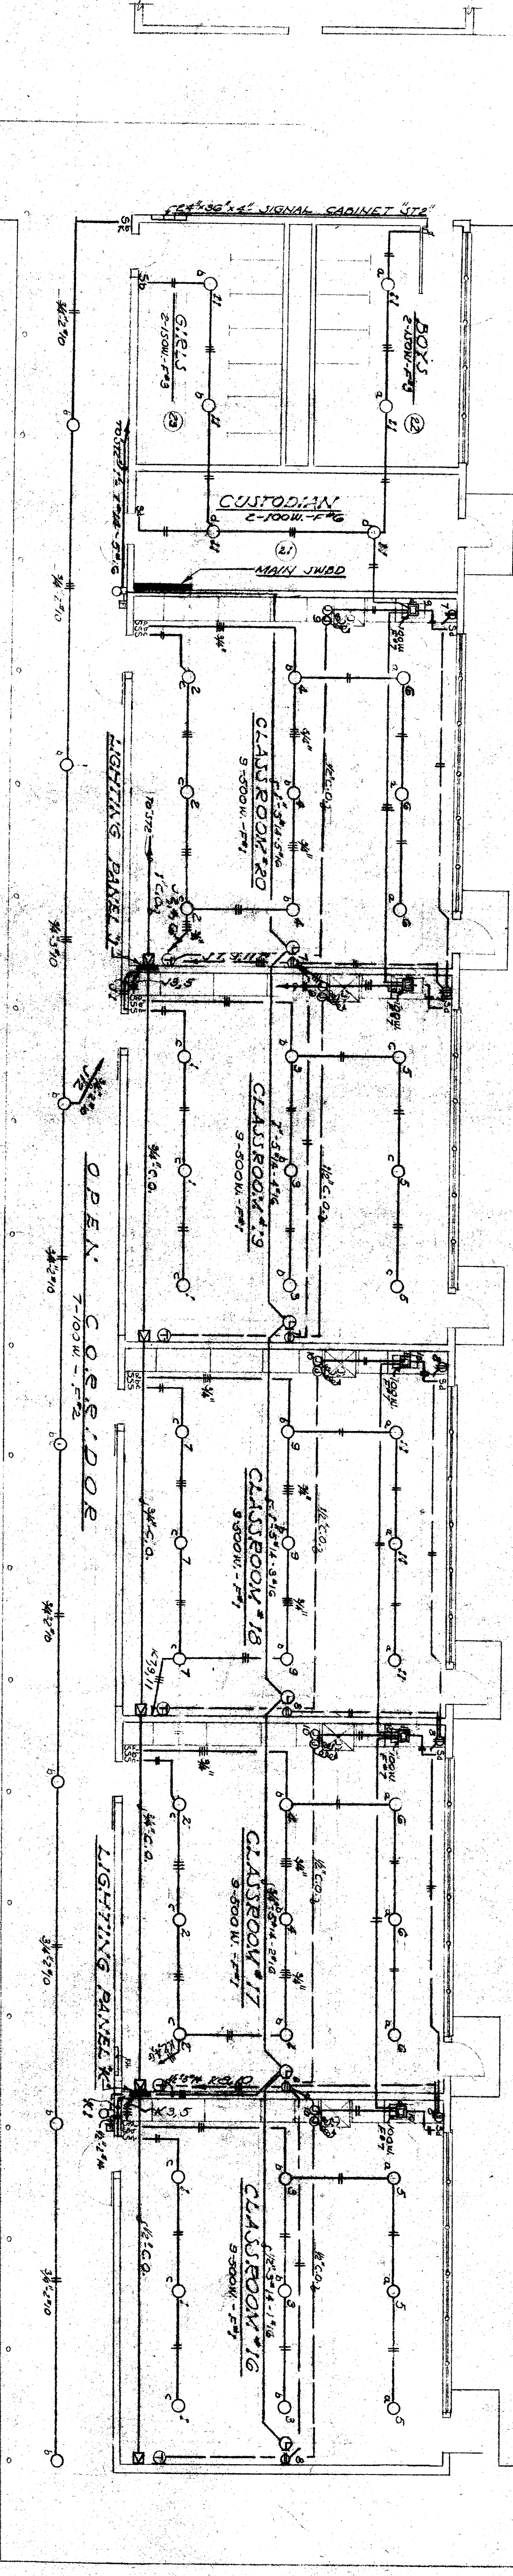

FLOOR PLAN - WING 'E'

MARKED LINE SEE PLANS

HILBING, BYLER & HENNINGER MECHANICAL AND ELECTRICAL ENGINEERS 227 SOUTH SPRING STREET LOS ANGELES 12, CALIFORNIA	STATE OF CALIFORNIA DEPARTMENT OF PUBLIC WORKS DIVISION OF ARCHITECTURE APPROVED: 3/17/48 M. J. ... ARCHITECT	SHERFIELD CITY SCHOOLS BOARD OF EDUCATION APPROVED: ... PRESIDENT	SHERFIELD CITY SCHOOLS BOARD OF EDUCATION APPROVED: ... PRESIDENT	DATE: ... DRAWN BY: ... CHECKED BY: ... SHEET NO: ... OF SHEETS: ...
	STATE OF CALIFORNIA DEPARTMENT OF PUBLIC WORKS DIVISION OF ARCHITECTURE APPROVED: 3/17/48 M. J. ... ARCHITECT	SHERFIELD CITY SCHOOLS BOARD OF EDUCATION APPROVED: ... PRESIDENT	SHERFIELD CITY SCHOOLS BOARD OF EDUCATION APPROVED: ... PRESIDENT	DATE: ... DRAWN BY: ... CHECKED BY: ... SHEET NO: ... OF SHEETS: ...

