



ELECTRICAL SITE PLAN

JEFFERSON SCHOOL

SCALE: 1" = 30' - 0"

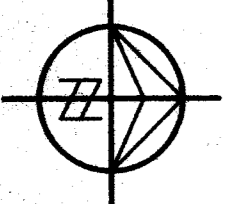




UTILITY COMPANY	P.C. & E.
UTILITY CO. JOB REF. NO.	
TELEPHONE NO.	(805) 398-5978
ADDRESS	1918 'H' STREET BAKERSFIELD CA. 93301
CONTRACT	GERRY OHARA

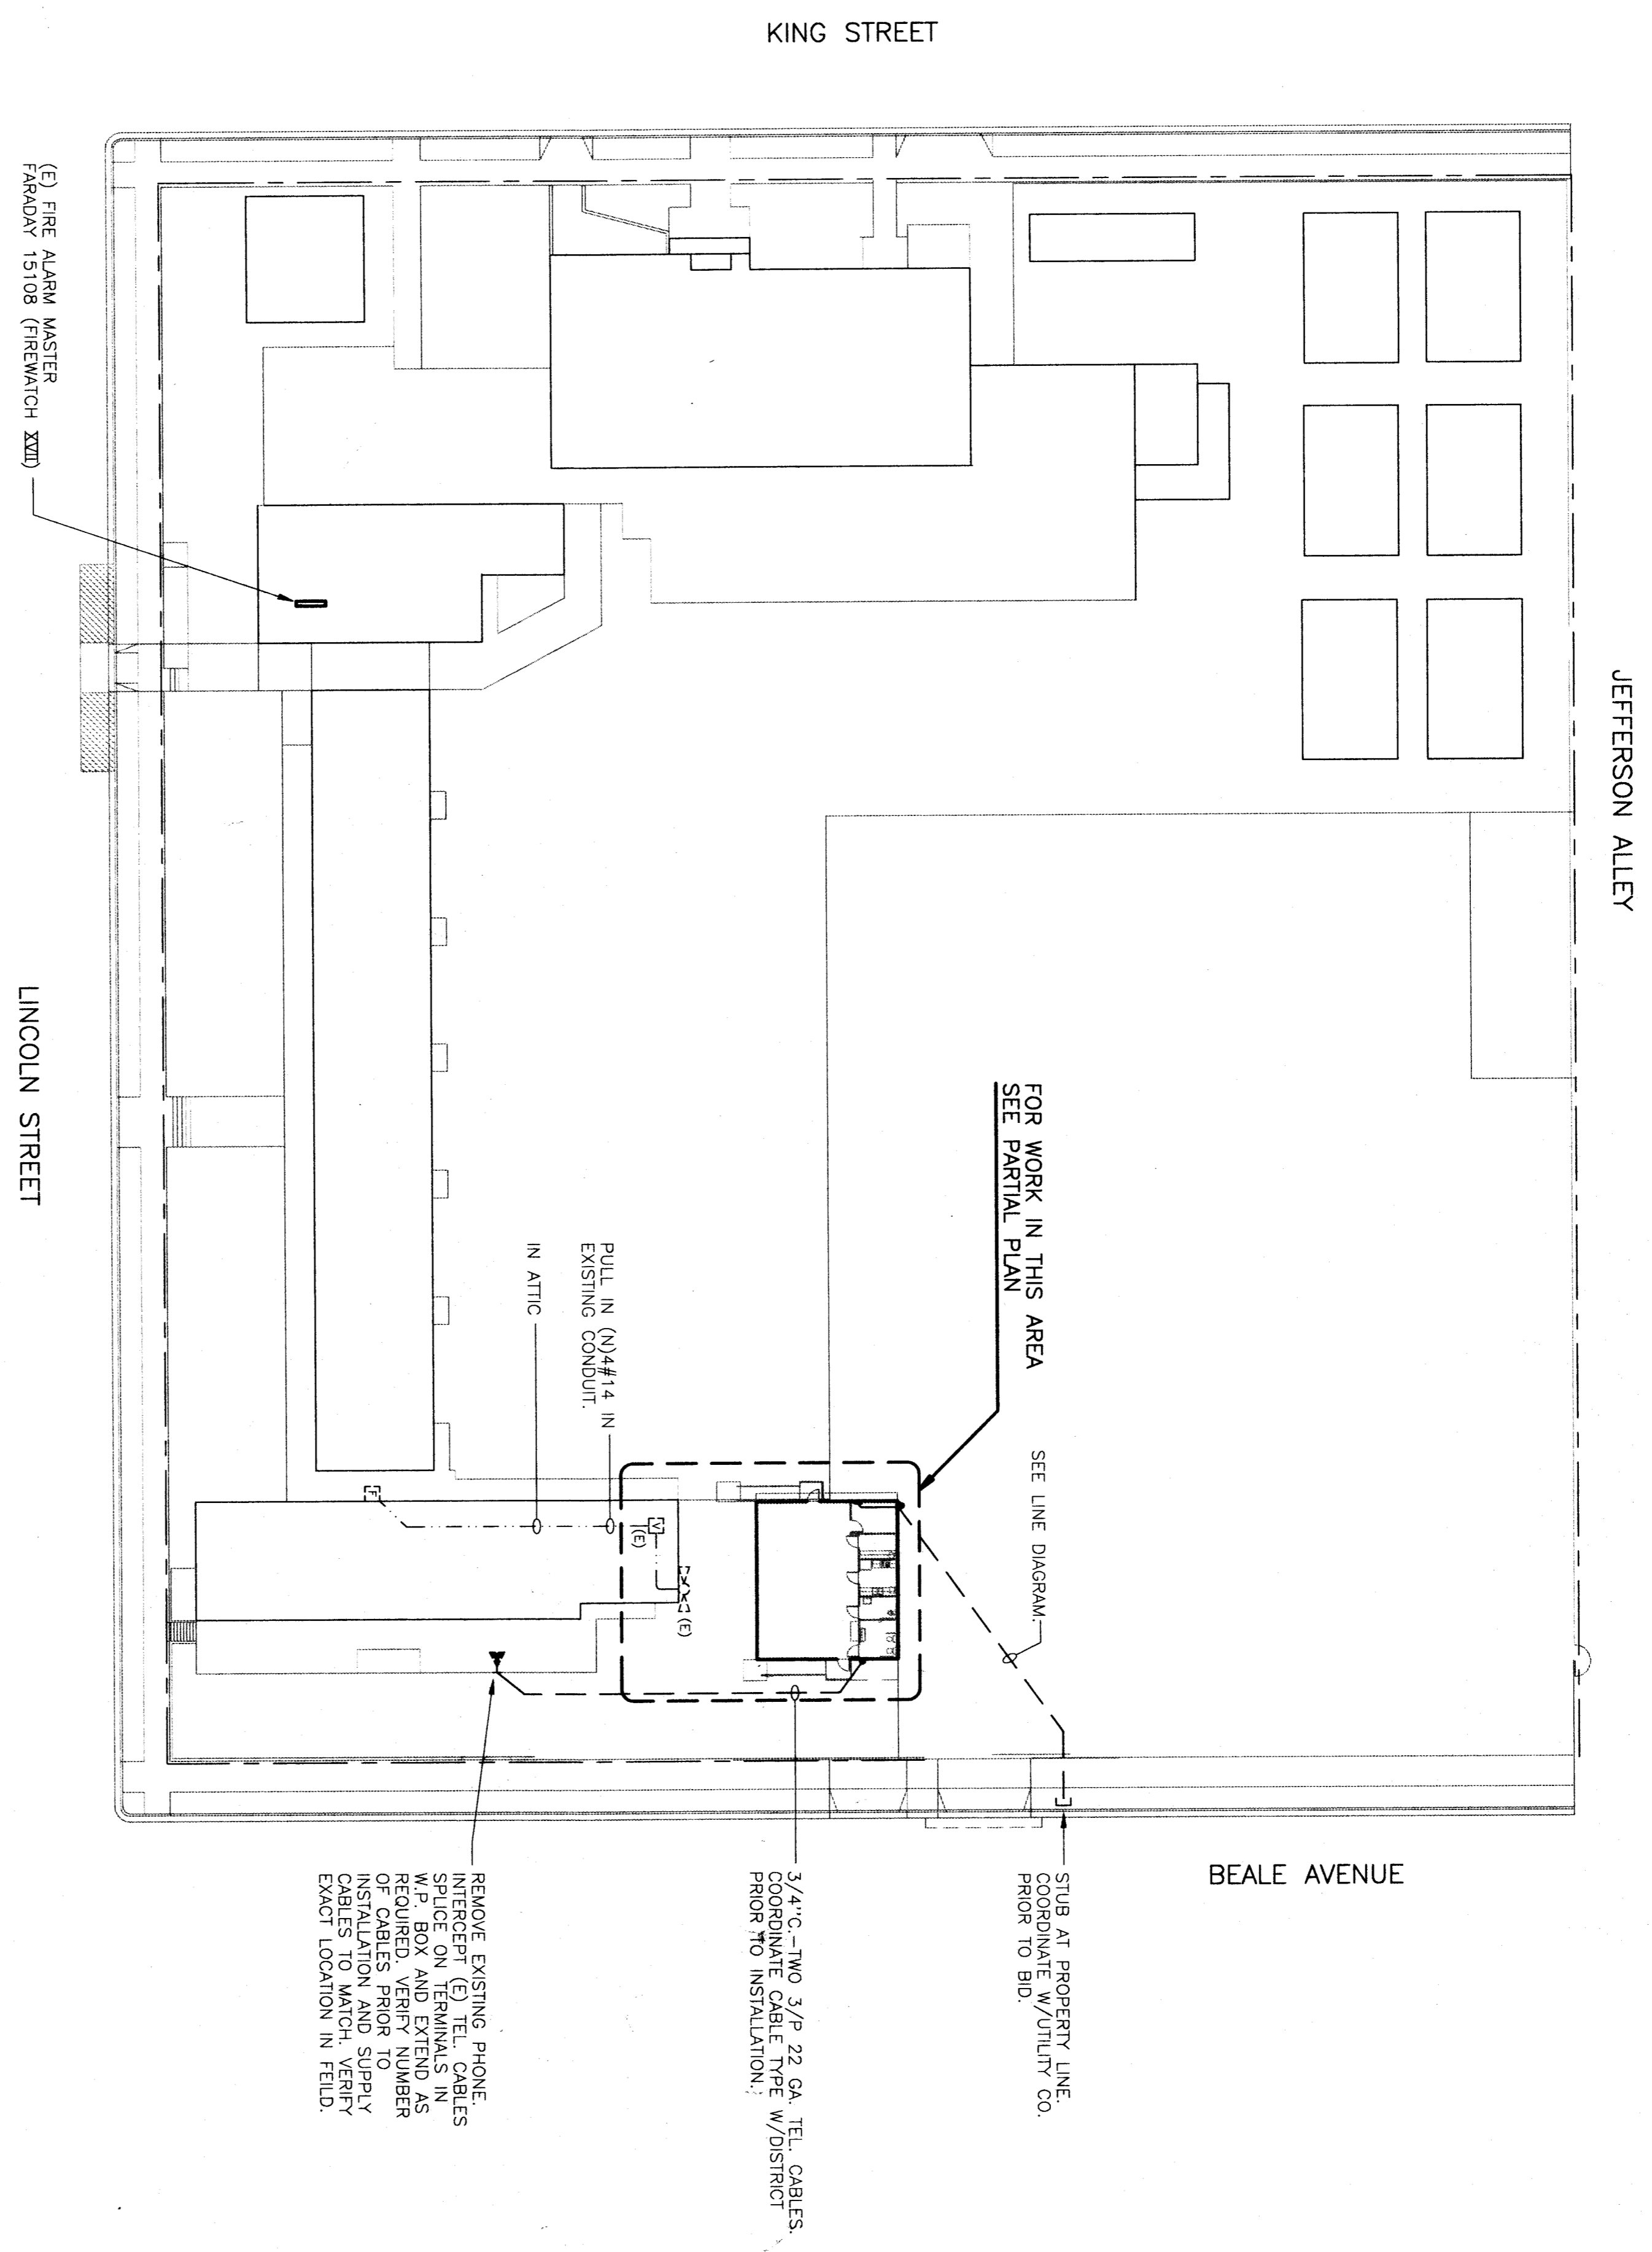

PARTIAL PLAN

JEFFERSON SCHOOL

SCALE: 1/8" = 1' - 0"

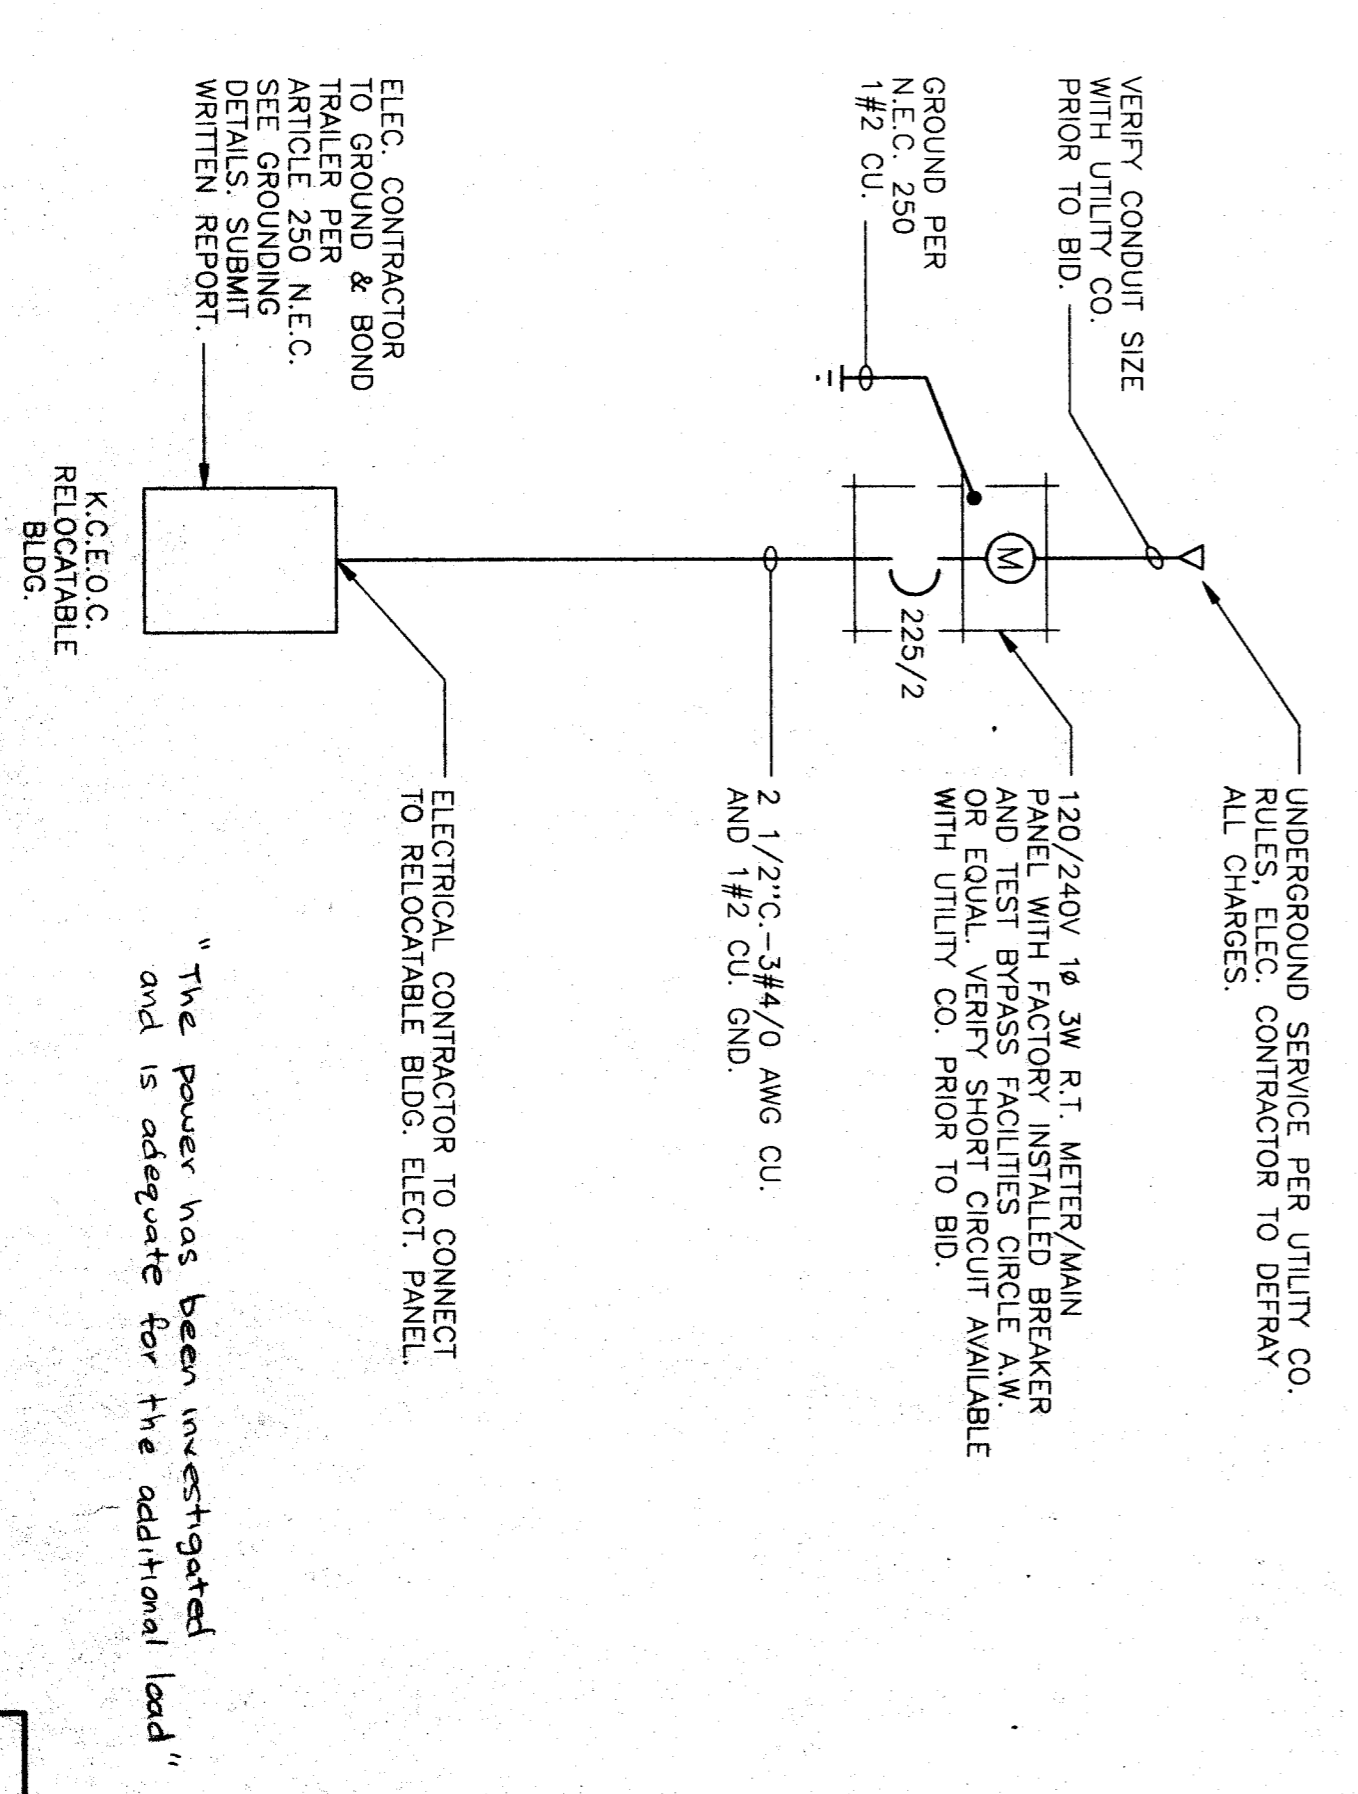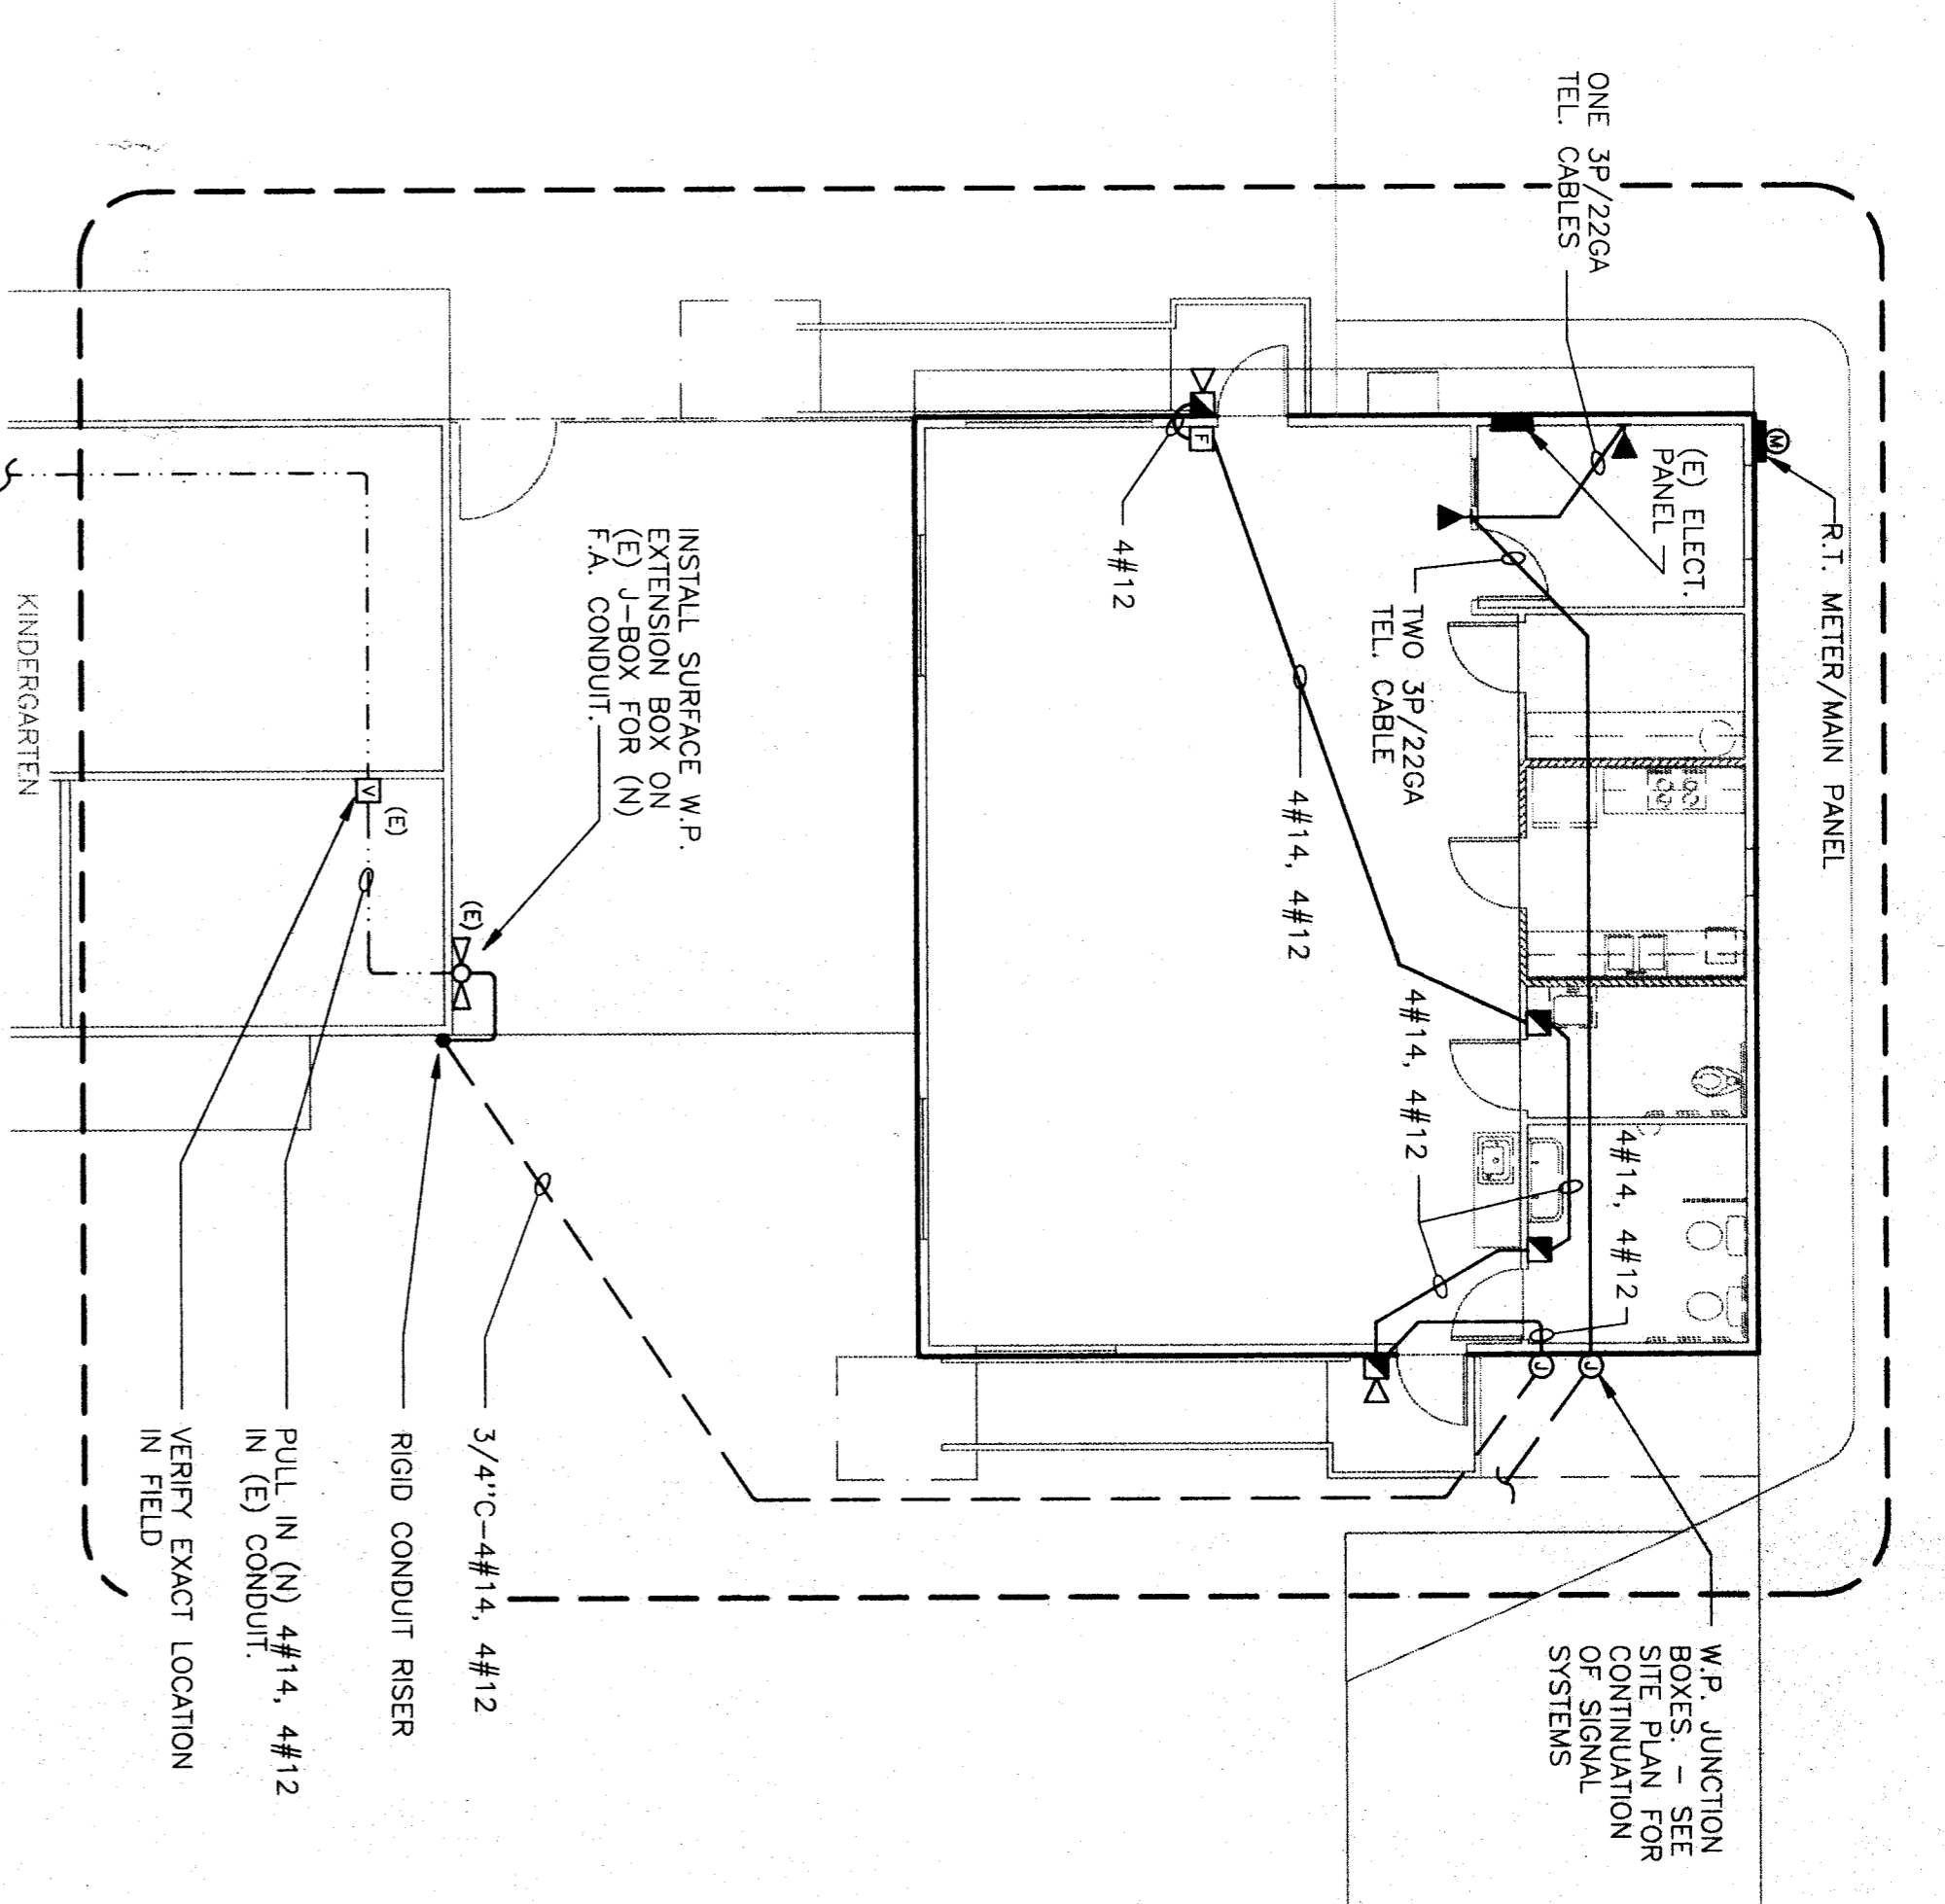
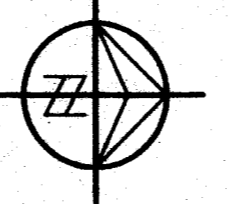


SINGLE LINE DIAGRAM

NO SCALE



"The power has been investigated and is adequate for the additional load"

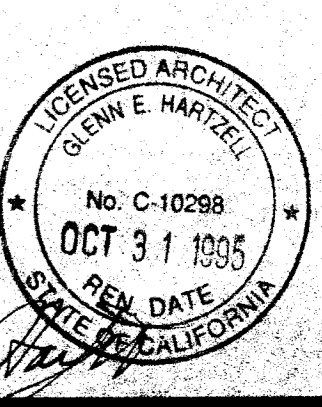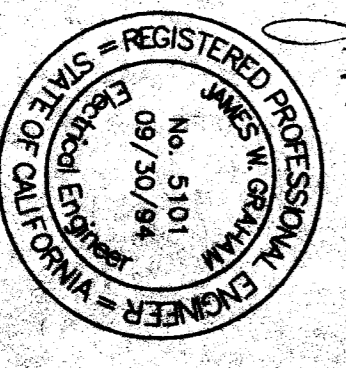

E1 SHEET NO. 1 OF 2	JOB NO. 198 D SHEET NO. 1	DATE 2-10-94 DRAWN R. L. M.	INTERSTATE ENGINEERING, INC. 2727 N. GROVE INDUSTRIAL DR., BLDG. 155, SITE B FRESNO, CA 93727 (209)453-9491 JAMES W. GRAHAM E.E. 5101	Glenn Hartzell-Architect, inc. 26 'H' STREET, 93304 (805) 324-6416 P.O. BOX 2344, 93303, BAKERSFIELD, CALIFORNIA ARCHITECT C-10298
	ELECTRICAL SITE PLAN ~ PARTIAL PLAN ~ SINGLE LINE DIAGRAM (SITE DEVELOPMENT) HEADSTART RELOCATABLE 'K.C.E.O.C. AT JEFFERSON SCHOOL' BAKERSFIELD CITY SCHOOL DISTRICT 878 LINCOLN STREET, BAKERSFIELD, KERN COUNTY, CALIFORNIA			