



PLUMBING FLOOR PLAN - KITCHEN & STORAGE
SCALE 1/4" = 1'-0"

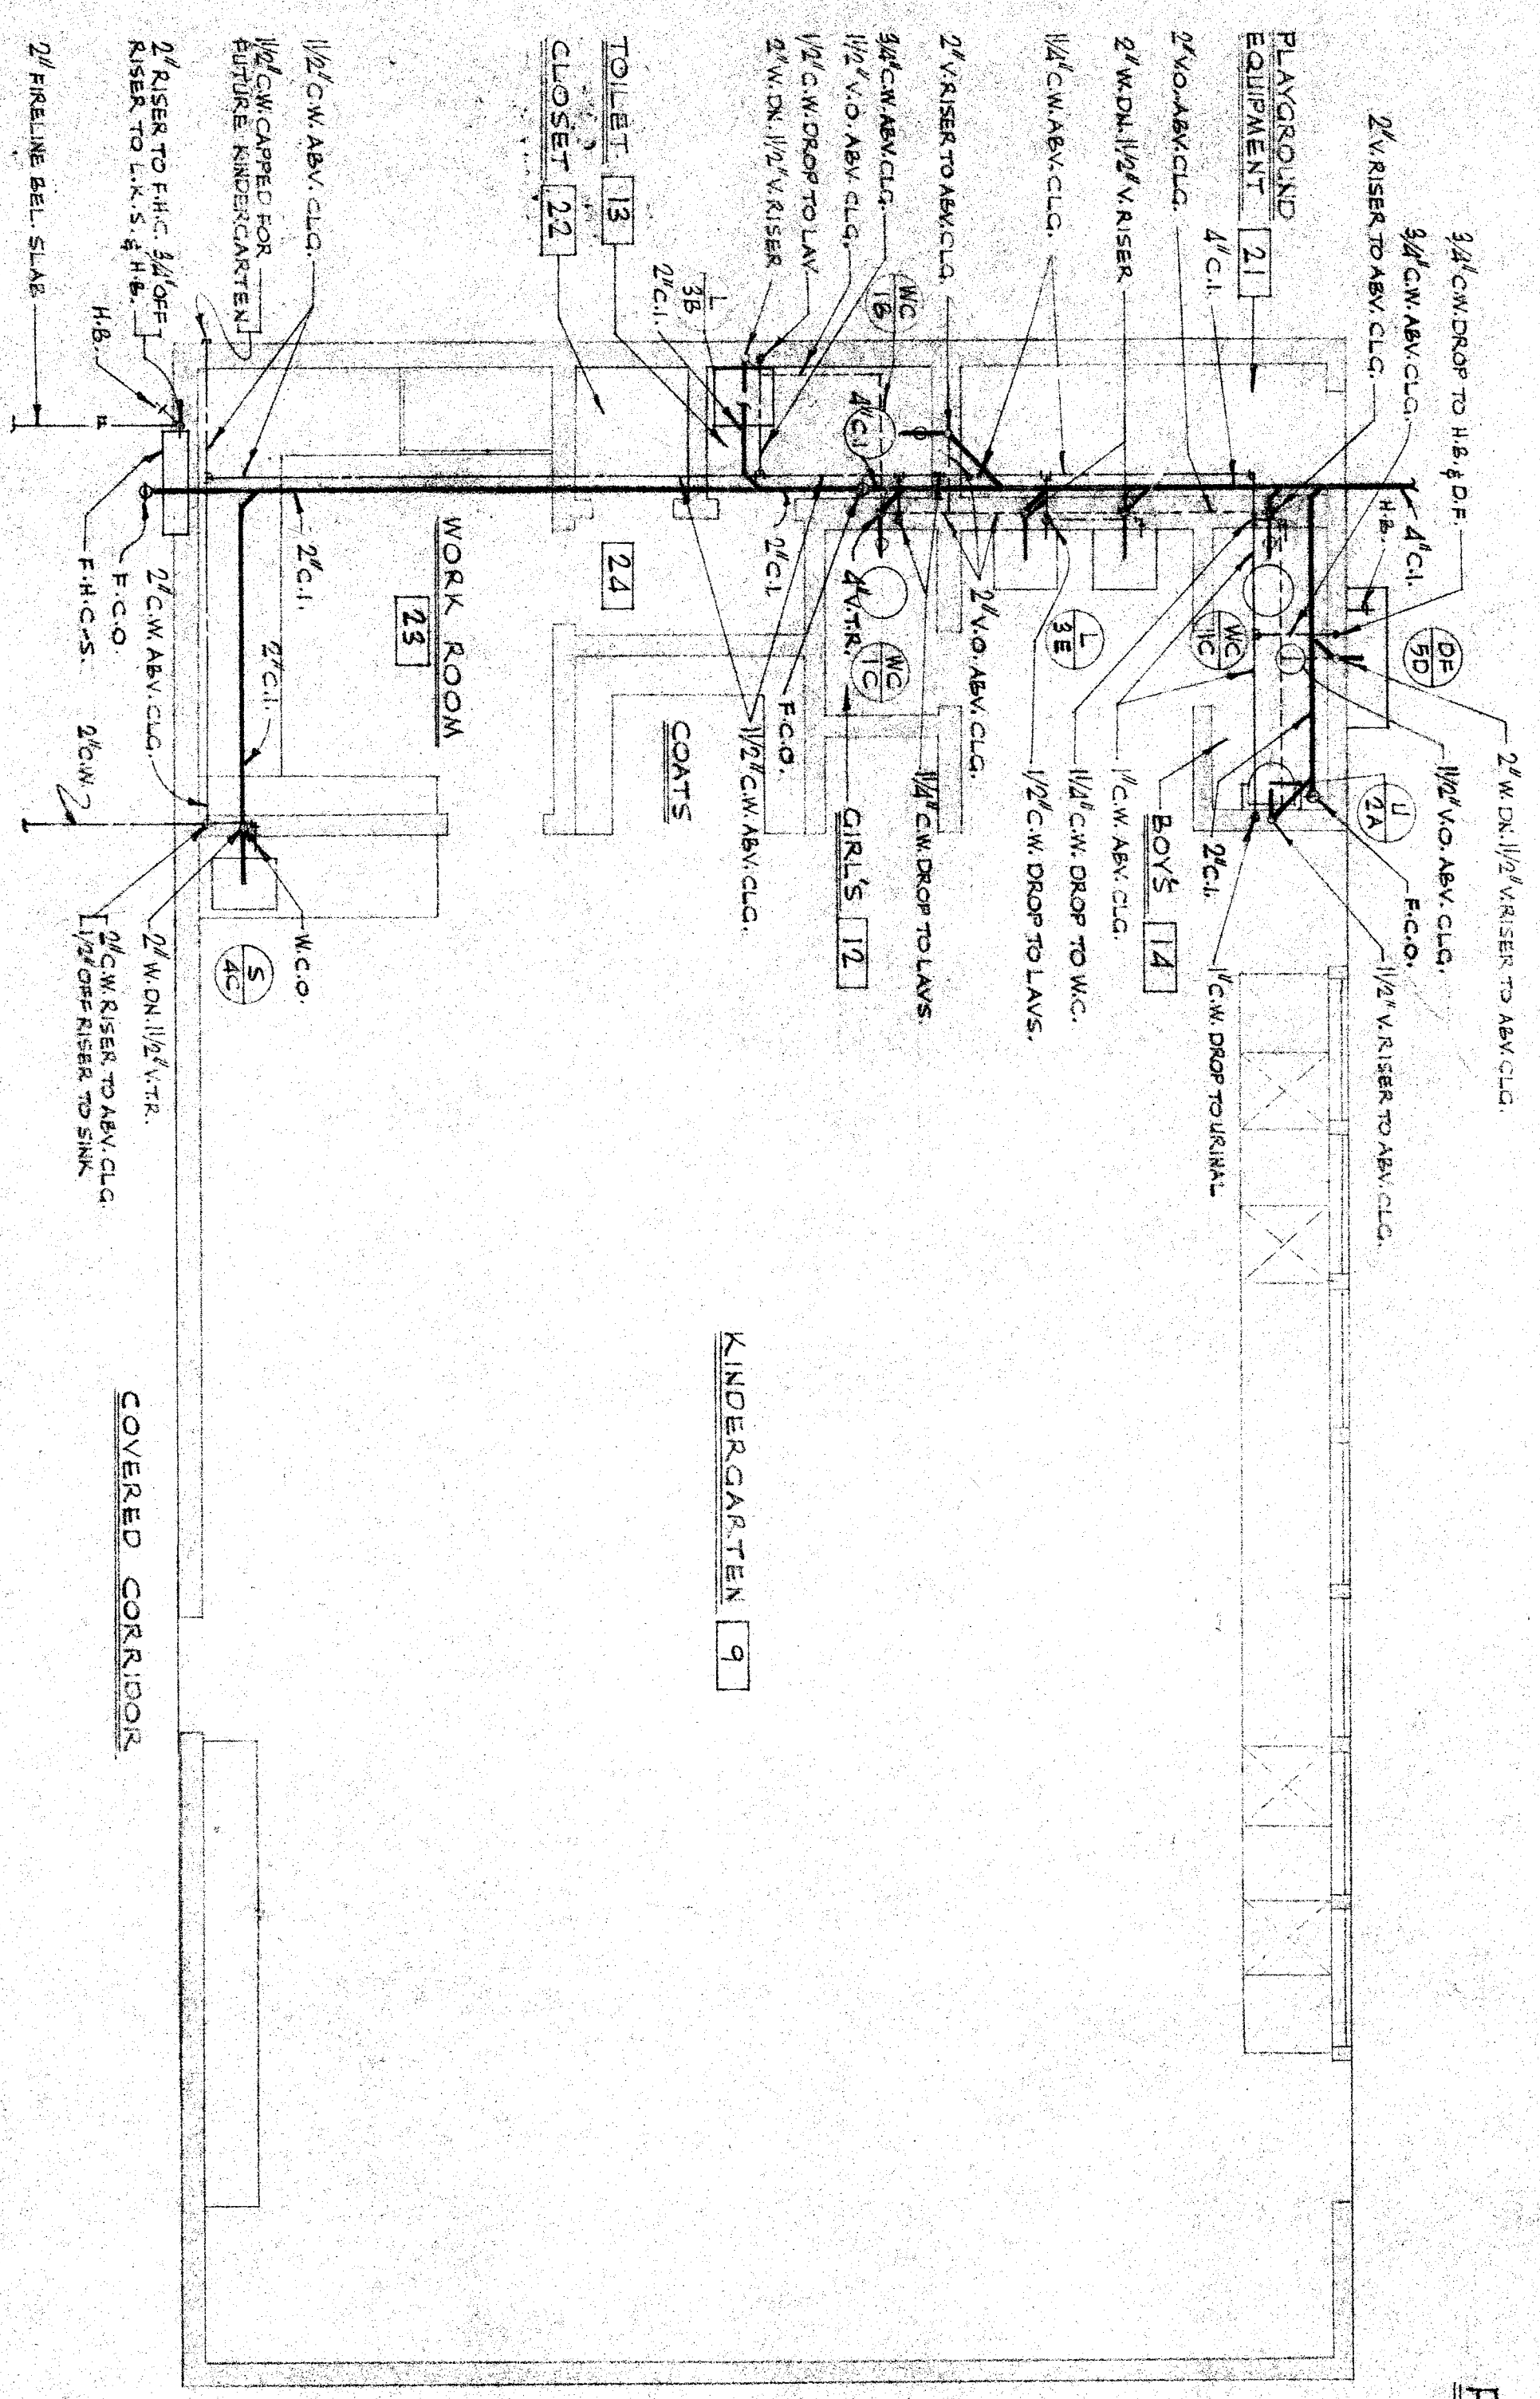

PLUMBING FLOOR PLAN KINDERGARTEN UNIT
SCALE 1/4" = 1'-0"

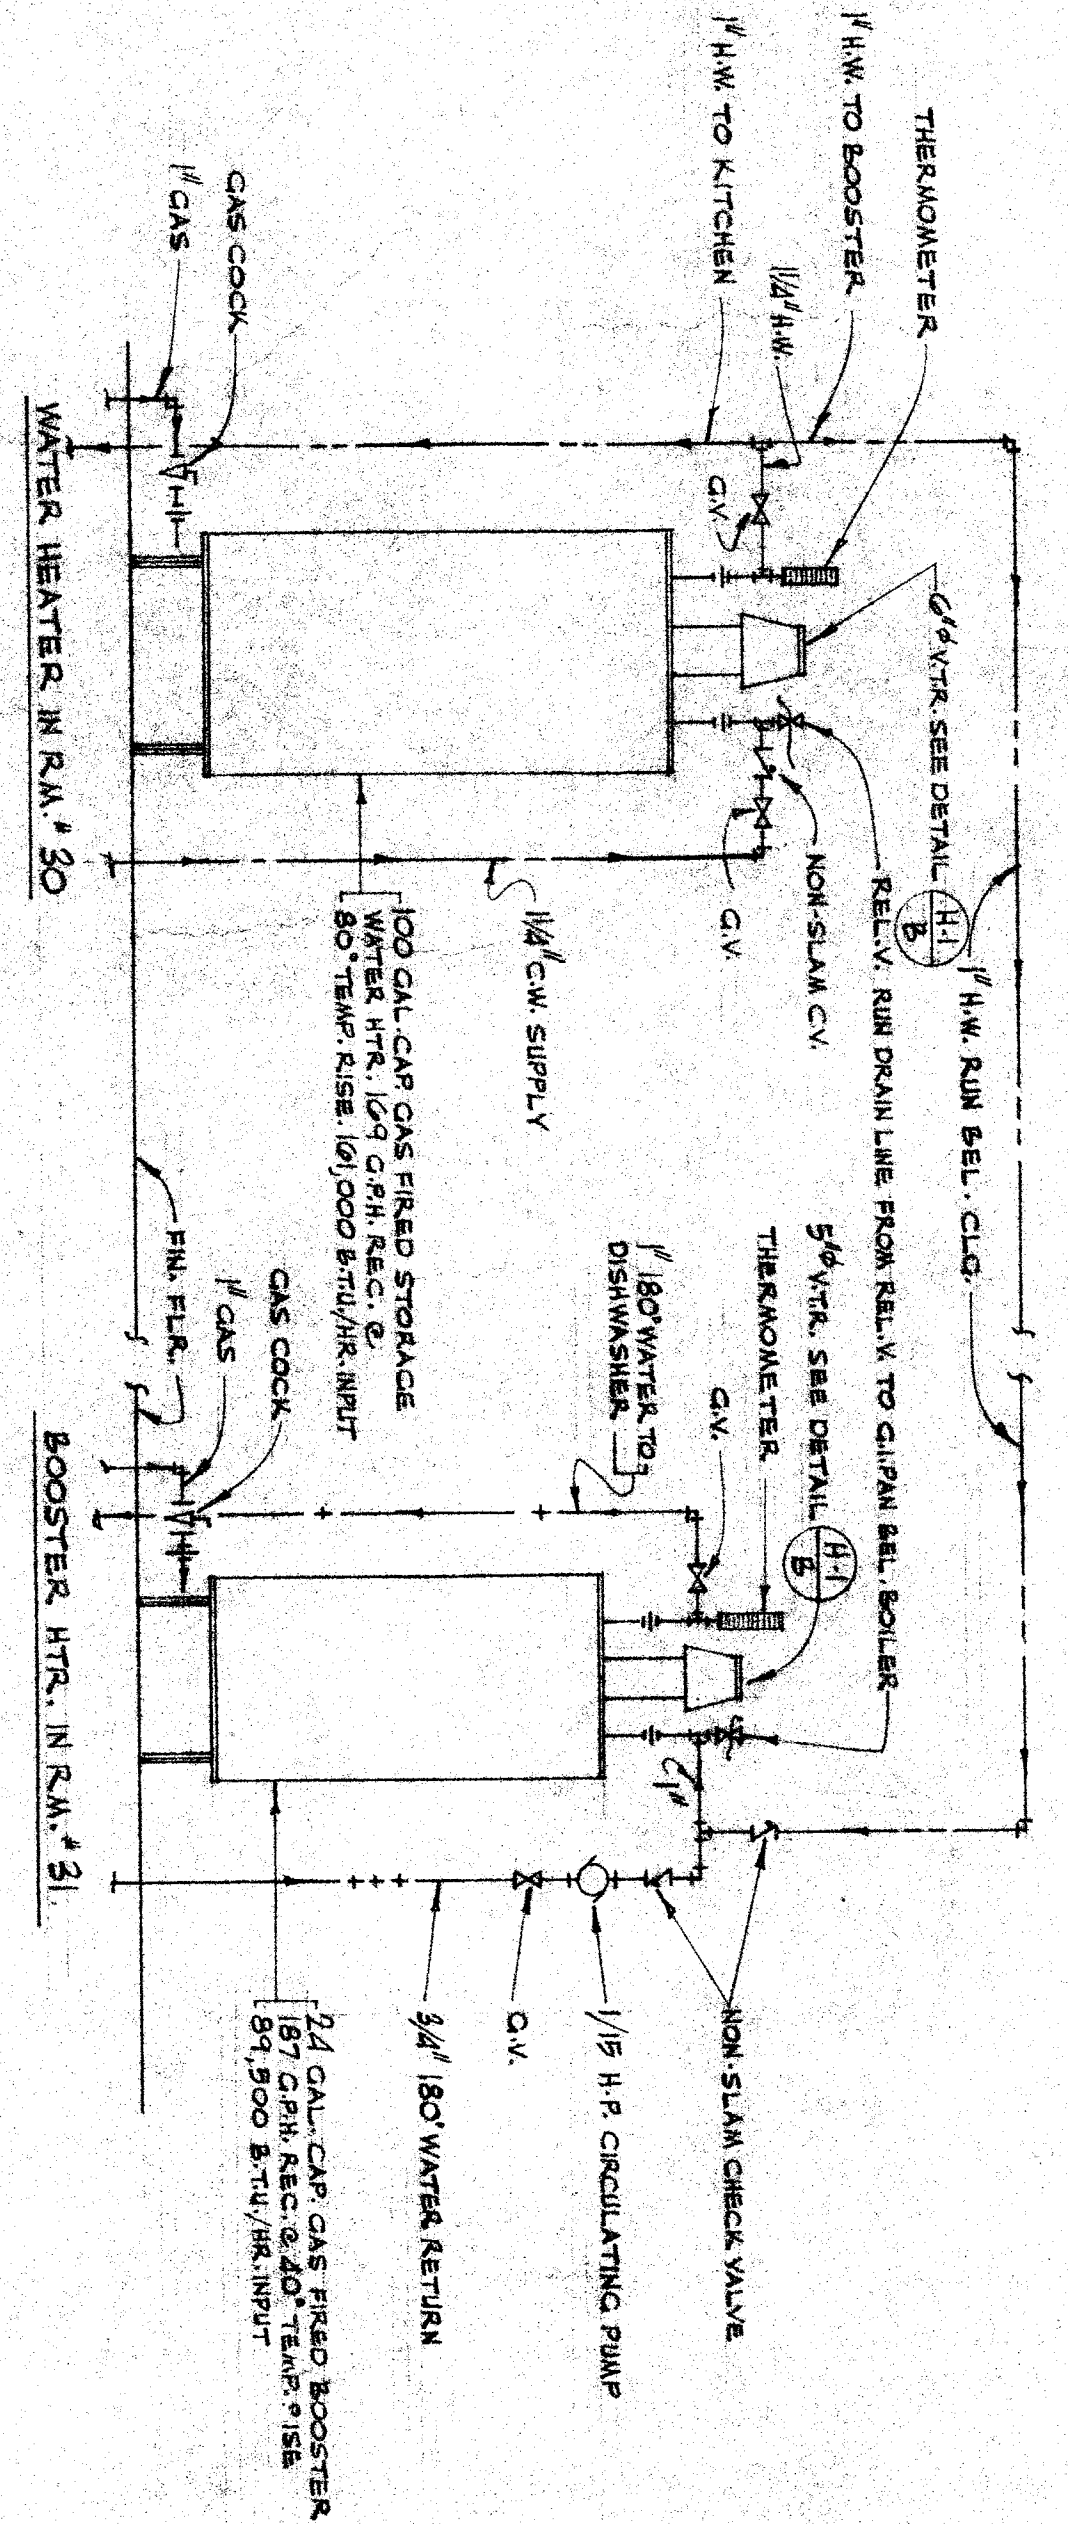

DIAGRAMMATIC HOOK-UP OF WATER HEATERS
NO SCALE
DETAIL P-3 A

NOTES
1. FOR PLUMBING, SYMBOLS LEGEND & FINISHES
SCHEDULE, SEE SHEET P-1.
2. FOR CONTINUATION OF ALL LINES OUTSIDE
THE BUILDING, SEE PLUMBING PLOT PLAN SHEET P-1.

CHESTER D. WALZ
CONSULTING MECHANICAL ENGINEER
500 SO. FIGUEROA ST., LOS ANGELES
CALIF. REG. NO. 70

C. B. ALFORD - ARCHITECT - W. J. THOMAS
602 HARBORLIDE BUILDING
BAKERSFIELD CALIFORNIA
PHONE 2-1302

FRANKLIN SCHOOL ADDITION
BAKERSFIELD CITY SCHOOL DISTRICT
BAKERSFIELD CALIFORNIA

BOARD OF TRUSTEES
F. W. ALFORD
W. J. THOMAS
W. J. THOMAS

COUNTY SUPERINTENDENT
OF SCHOOLS

DIVISION OF SCHOOL
HOUSE PLANNING

STATE OF CALIFORNIA, DEPARTMENT OF PUBLIC WORKS
DIVISION OF ARCHITECTURE
111380
APPROVED
NOV 6 - 1954

NOTE: CONTINUATION IS TO BE MADE AT THE DISCRETION OF THE ARCHITECT AND
MAY BE RETURNED ON COMPLETION OF THE CONTRACT.