



**DEMOLITION PLAN**

SCALE: 1/16" = 1'-0"

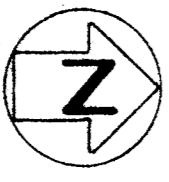

REMOVE (E) GAS-FIRED FURNACE, FILL SIM PLENUM WALL CONTROLS, ETC. TYP. EACH CLASSROOM UNIT A1. SEE DETAIL A/M-8.

- DEMOLITION NOTES:**
1. DEMOLITION OF ANY HVAC CONTROL DEVICES BY SPECIFICATION SECTION 15800.
  2. DEMOLITION OF GAS AND DOMESTIC WATER PIPING BY SPECIFICATION SECTION 15400. SEE PLUMBING DRAWINGS.
  3. SEE AIR CONDITIONING FLOOR PLANS FOR ANY ADDITIONAL NOTES ON DEMOLITION OF EXISTING MECHANICAL ITEMS.

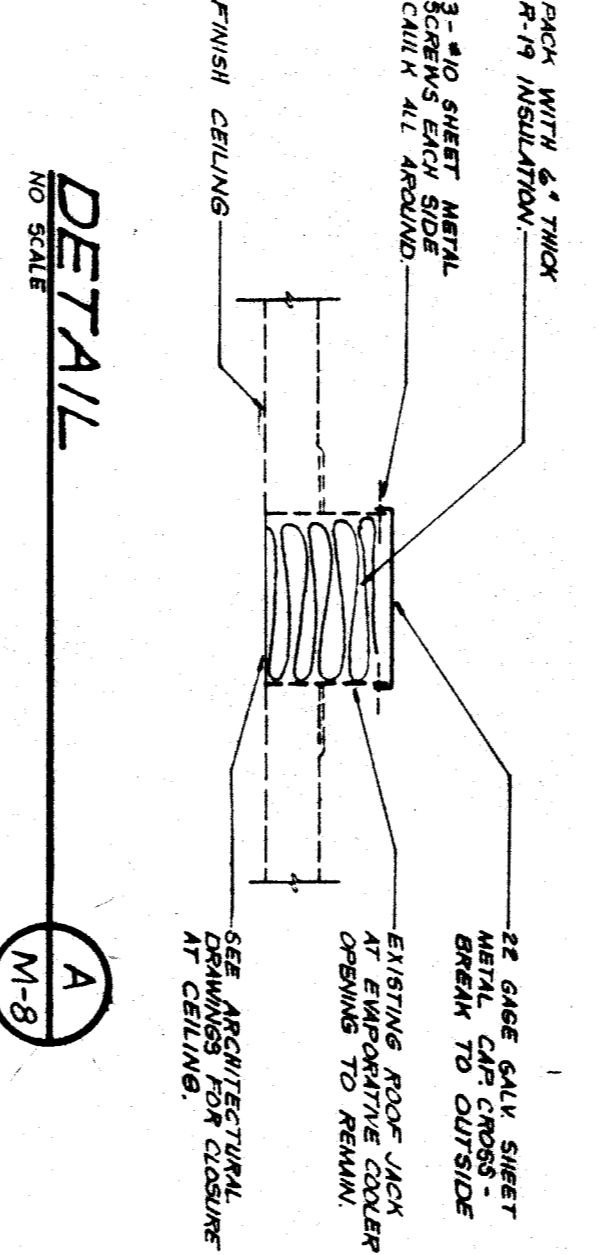

FILE # 24 & 1979 USE  
 DATE 2/27/90  
 52439  
 M-8

**Kendrick Design Group**  
*John Kendrick* A.I.A.  
 architects • planners  
 2115 19th street • bakersfield, ca 93301 • (805) 322-1863

job number 571-1  
 sheet number **M-8** OF 8

**JOHN FRANK MITCHELL, INC.**  
 CONSULTING MECHANICAL ENGINEERS  
 444 WEST JEWETER, SUITE 101  
 FRESNO, CALIFORNIA 93722  
 8788.2

APPROVED  
 Department of General Services  
 Office of the State Architect  
 FEB 27 1990  
 Structural Safety Section  
 Checked By

**WILLIAM PENN SCHOOL MODERNIZATION**  
 BAKERSFIELD CITY SCHOOL DISTRICT  
 BAKERSFIELD, CALIFORNIA

DATE 2-26-90  
 REVISIONS