



PLUMBING FLOOR PLAN (UNIT "A.2")
SCALE: 1/8" = 1'-0"

ALL PLUMBING FIXTURES THIS SHEET SHALL BE RELOCATED AS SHOWN ON B/P.3

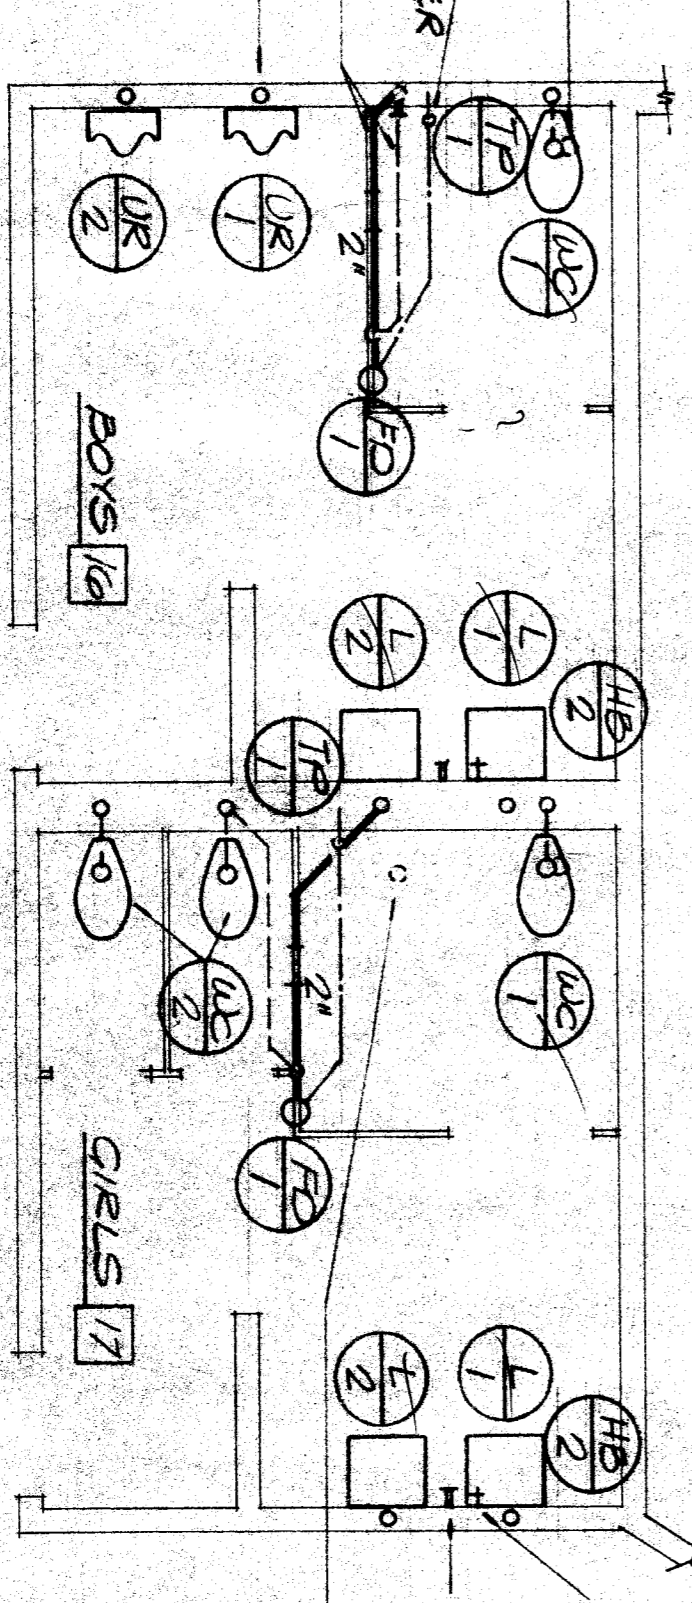

DETAIL
NO SCALE

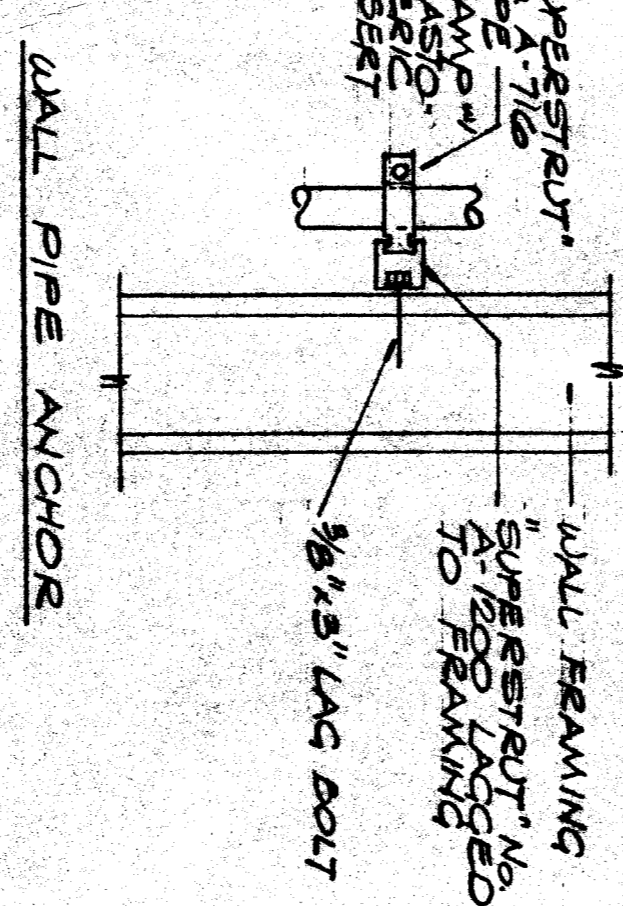

MARK	FIXTURE	CONNECTIONS			DESCRIPTION
		CU	HU	SOIL VENT	
WC	WATER CLOSET (HANDICAP)	1-1/2"	4"	2"	AMERICAN STANDARD WATER CLOSET #4860, 10 1/2" FLUSH WITH BOWL, BRASS #52755 SEAT-WHITE, SLOW ROVAL #110-3 FLUSH VALVE.
WC	WATER CLOSET	1-1/2"	4"	2"	REMOVE AND REINSTALL EXISTING WATER CLOSET (FOR NEW FLOORING). SLOW ROVAL #110-3 RUSH VALVE CUT TO FIT, BRASS #52755 SEAT-WHITE. RECONNECT TO EXISTING SERVICES AS REQUIRED.
UR	URINAL (HANDICAP)	1-1/4"	2"	1-1/2"	AMERICAN STANDARD #4860, 10 1/2" FLUSH WITH BOWL, BRASS #52755 SEAT-WHITE, SLOW ROVAL #110-3 FLUSH VALVE. PROVIDE COTN.
UR	URINAL	1-1/4"	2"	1-1/2"	SAME AS U-1 ABOVE EXCEPT LESS HANDICAP REQUIREMENTS.
L	LAVATORY (HANDICAP)	1/2"	2"	1-1/2"	AMERICAN STANDARD "LUCERNE" MODEL #356-421, 20" X 18" SINGLE HOLE #2411-015 GRID DRAIN, CHICAGO #355-E12 1/2" TP-TP SELF-CLOSING FAUCET INKED "C" ADJUST FAUCET TO STAY OPEN FOR 10 SECONDS. FURNISH END OF CONCEALED ARM SUPPORT SYSTEM, PROVIDE 2" CLEARANCE FROM LOWER EDGE OF APRON TO FLOOR.
L	LAVATORY	1/2"	2"	1-1/2"	SAME AS L-2 ABOVE EXCEPT LESS HANDICAP REQUIREMENTS.
S	SINK	1/2"	2"	1-1/2"	HMS MODEL #120, 30" X 20", ENM, C.I., #4085 RUBBER W/A-ARM HANDLE MTD. ON RIGHT FRONT. #4085 STRAINER FITTING W/NO. 6M-2A-#3 RIGID GOOSENECK QUADRA SINK. BRASS W/ALUMINUM RESISTANT SORBITION MTD. LEFT REAR. PROVIDE NEW ANGLE STOP AND SUPPLY TRAP # 7791L PIECE.
DF	DRINKING FOUNTAIN (HANDICAP)	1/2"	2"	1-1/2"	HMS MODEL 1075 WHITE POLYMERABLE WALL MTD. DRINKING FOUNTAIN WITH VERTICAL MOUNTING BRACKET, FRONT PUSH PLATE AND BOTTOM PLATE WITH INTERNAL REQUIREMENTS.
HB	HOSE BIBB	3/4"	-	-	EXTERIOR - CALCO ROUGH BRASS WITH LOOSE KEY AND WATTS MODEL NO. 8A ATMOSPHERIC TYPE BACKFLOW PREVENTER. PATTERN SHALL BE AS SCHEDULED ON THE DRAWINGS.
HB	HOSE BIBB	3/4"	-	-	INTERIOR - CHICAGO COPPER PLATED BRASS WITH LOOSE KEY AND WATTS MODEL NO. 8A ATMOSPHERIC TYPE BACKFLOW PREVENTER. PATTERN SHALL BE AS SCHEDULED ON THE DRAWINGS.
FD	FLOOR DRAIN	-	2"	2"	ZURN MODEL ZN-415, 5" TYPE "B" STRAINER-MOCKEL BRONZE, TRAP PRIMER CONNECTION.
TP	TRAP PRIMER	1/2"	-	-	"E & S" TRAP PRIMER W/ 1/2" CU AND S.O.V. TO SUPPLY INLET AND 1/2" GRAVITY LINE TO P-TRAP CONN. MOUNT BEL. LAV. IN WALL BEHIND ACCESS PANEL & FIN. F.R. #8" TO BOTTOM OF PANEL.

PLUMBING FLOOR PLAN
SCALE: 1/4" = 1'-0"

NOTE: SAW CUTTING REQ'D FOR ALL NEW LINES INDICATED BELOW SLAB.

TITLE: 2A & 1975 USE
 SHEET NUMBER: 521/1
 DATE: FEB 27 1990
 JOB NUMBER: 521/1
 DRAWING NUMBER: 521/1

P-3
 SHEET NUMBER: 521/1
 JOB NUMBER: 521/1

52 & 39 FEB 27 90
 JOHN FRANK MITCHELL, INC.
 CONSULTING MECHANICAL ENGINEERS
 444 WEST BROADWAY, SUITE 402
 TRENTON, CALIFORNIA 95756
 479-3611

APPROVED
 Department of General Services
 Office of the State Architect
 FEB 27 1990
 WILLIAM PENN SCHOOL MODERNIZATION
 BAKERSFIELD CITY SCHOOL DISTRICT
 BAKERSFIELD, CALIFORNIA
 Structural Safety Section
 Checked By: # 5243

DATE: 2-20-90
 REVISIONS: