


CIRC. OUTLETS NO.	WATTS			WIRE BKR. SIZE	P.A. REMARKS
	A	B	C		
1	900			12	1.5"
2	900				
3	900				
4	750				
5	700				
6	950				
7	850				
8	1000				
9	900				
10	900				
11	1200				
12	900				
13	1000				
14	1000				
15	1000				
16	1000				
17	900				
18	900				
19	900				
20	500				
21	500				
22	1000				
23	1000				
24	1000				
25	1000				
26	1200				
27	1200				
28	1200				
29	1200				
30	1200				
31	1200				
TOTAL	4260	9050	9750		

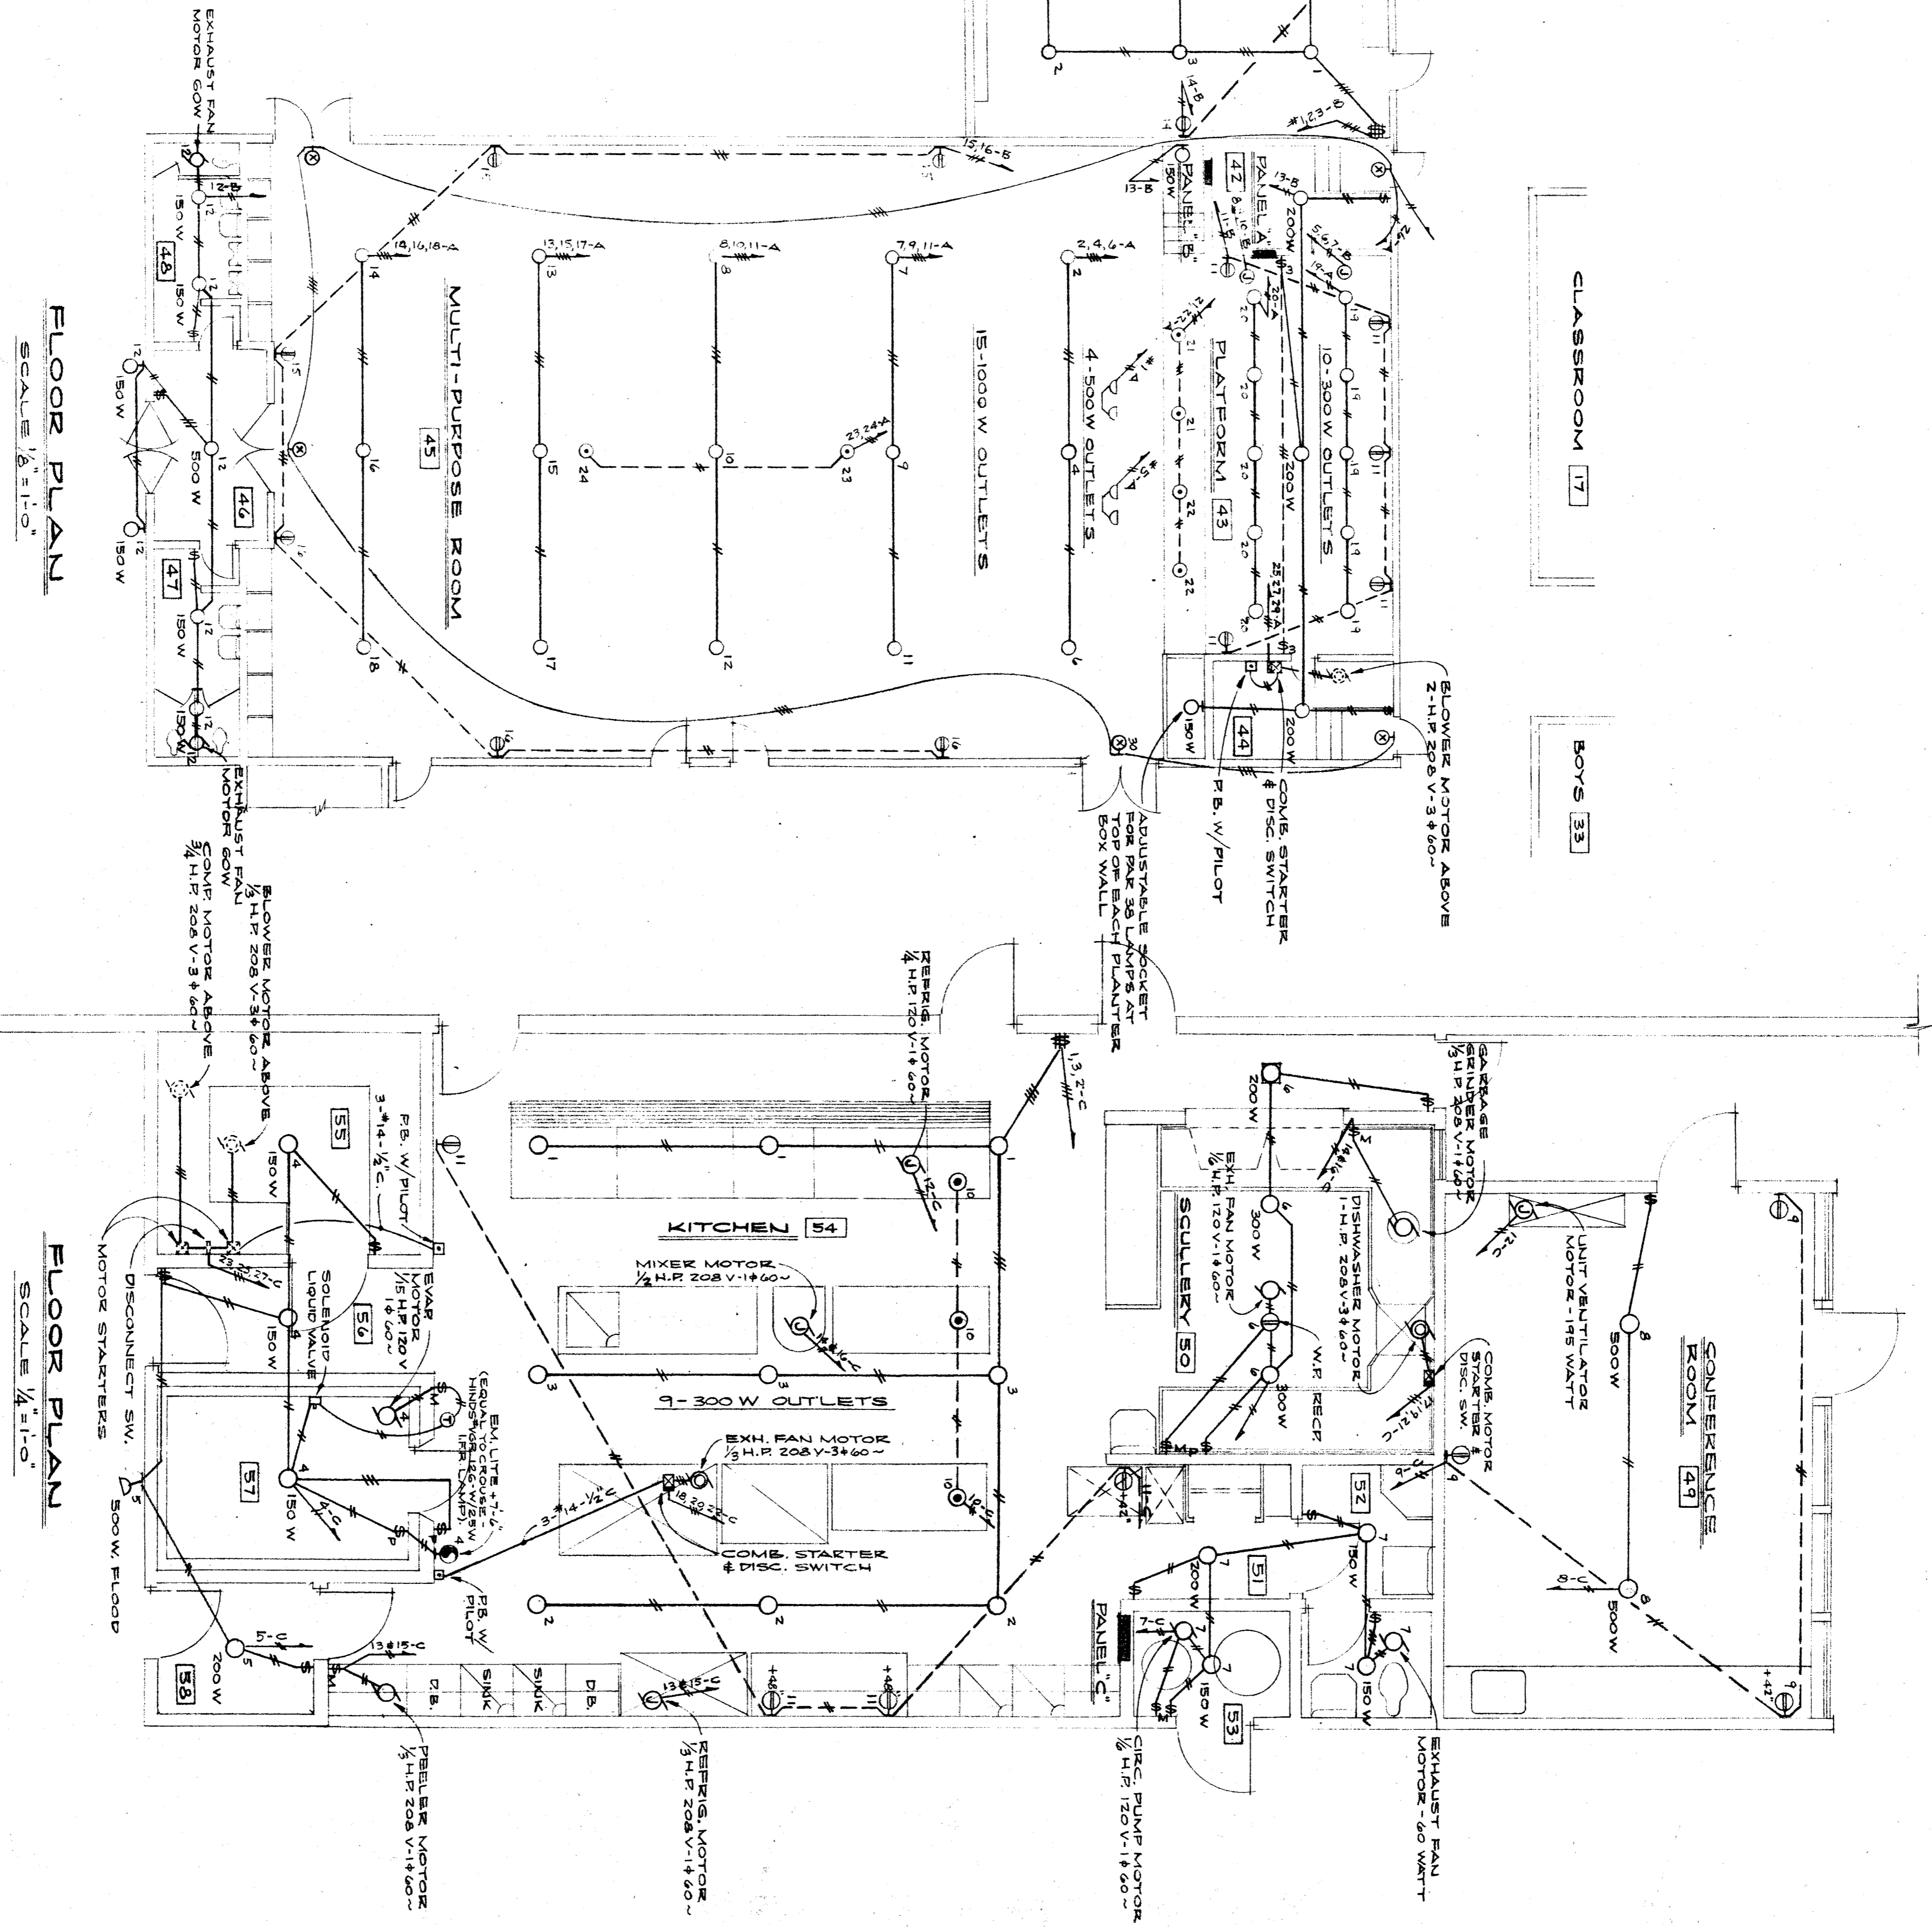

CIRC. OUTLETS NO.	WATTS			WIRE BKR. SIZE	P.A. REMARKS
	A	B	C		
1	1200			12	1.5"
2	1200				
3	1200				
4	1200				
5	1200				
6	1200				
7	1500				
8	1500				
9	1500				
10	1500				
11	1500				
12	1800				
13	1800				
14	1200				
15	900				
16	900				
17	810				
18	810				
19	13850				
20	13800				
21	13800				
22	1200				
23	1200				
24	1200				
TOTAL	22090	22504	22110		

CIRC. OUTLETS NO.	WATTS			WIRE BKR. SIZE	P.A. REMARKS
	A	B	C		
1	1000			12	1.5"
2	1000				
3	1000				
4	1000				
5	1000				
6	1000				
7	1000				
8	1000				
9	1000				
10	1000				
11	1000				
12	1000				
13	1000				
14	1000				
15	1000				
16	1000				
17	1000				
18	1000				
19	1000				
20	1500				
21	1500				
22	1500				
23	1500				
24	1500				
25	1200				
26	750				
27	1200				
28	1200				
29	1200				
30	1200				
31	1200				
32	1200				
33	1200				
34	1200				
35	1200				
36	1200				
TOTAL	33550	15800	15800		

28260/208 X 173 = 79 A.  
 BREAKER - 100 A-3P NON-AUTO.  
 FEEDER - 4-250 IN S.W.G.

DIVISION OF ARCHITECTURE

BOARD OF EDUCATION

ELECTRICAL PLANS

PROJECT NO. 22  
 DRAWN BY: G.E.  
 CHECKED BY:  
 DATE: 2-23-52

19  
 23  
 531

KINDERGARTEN, MULTI-PURPOSE RM & KITCHEN

WHITNEY BIGGAR ARCHITECT  
 MEMBER AMERICAN INSTITUTE OF ARCHITECTS  
 3601 STOCKDALE HIGHWAY  
 BAKERSFIELD, CALIFORNIA  
 29285 REGISTRATION C.1128

SHEET 3 OF 3