



CHESTER LANE

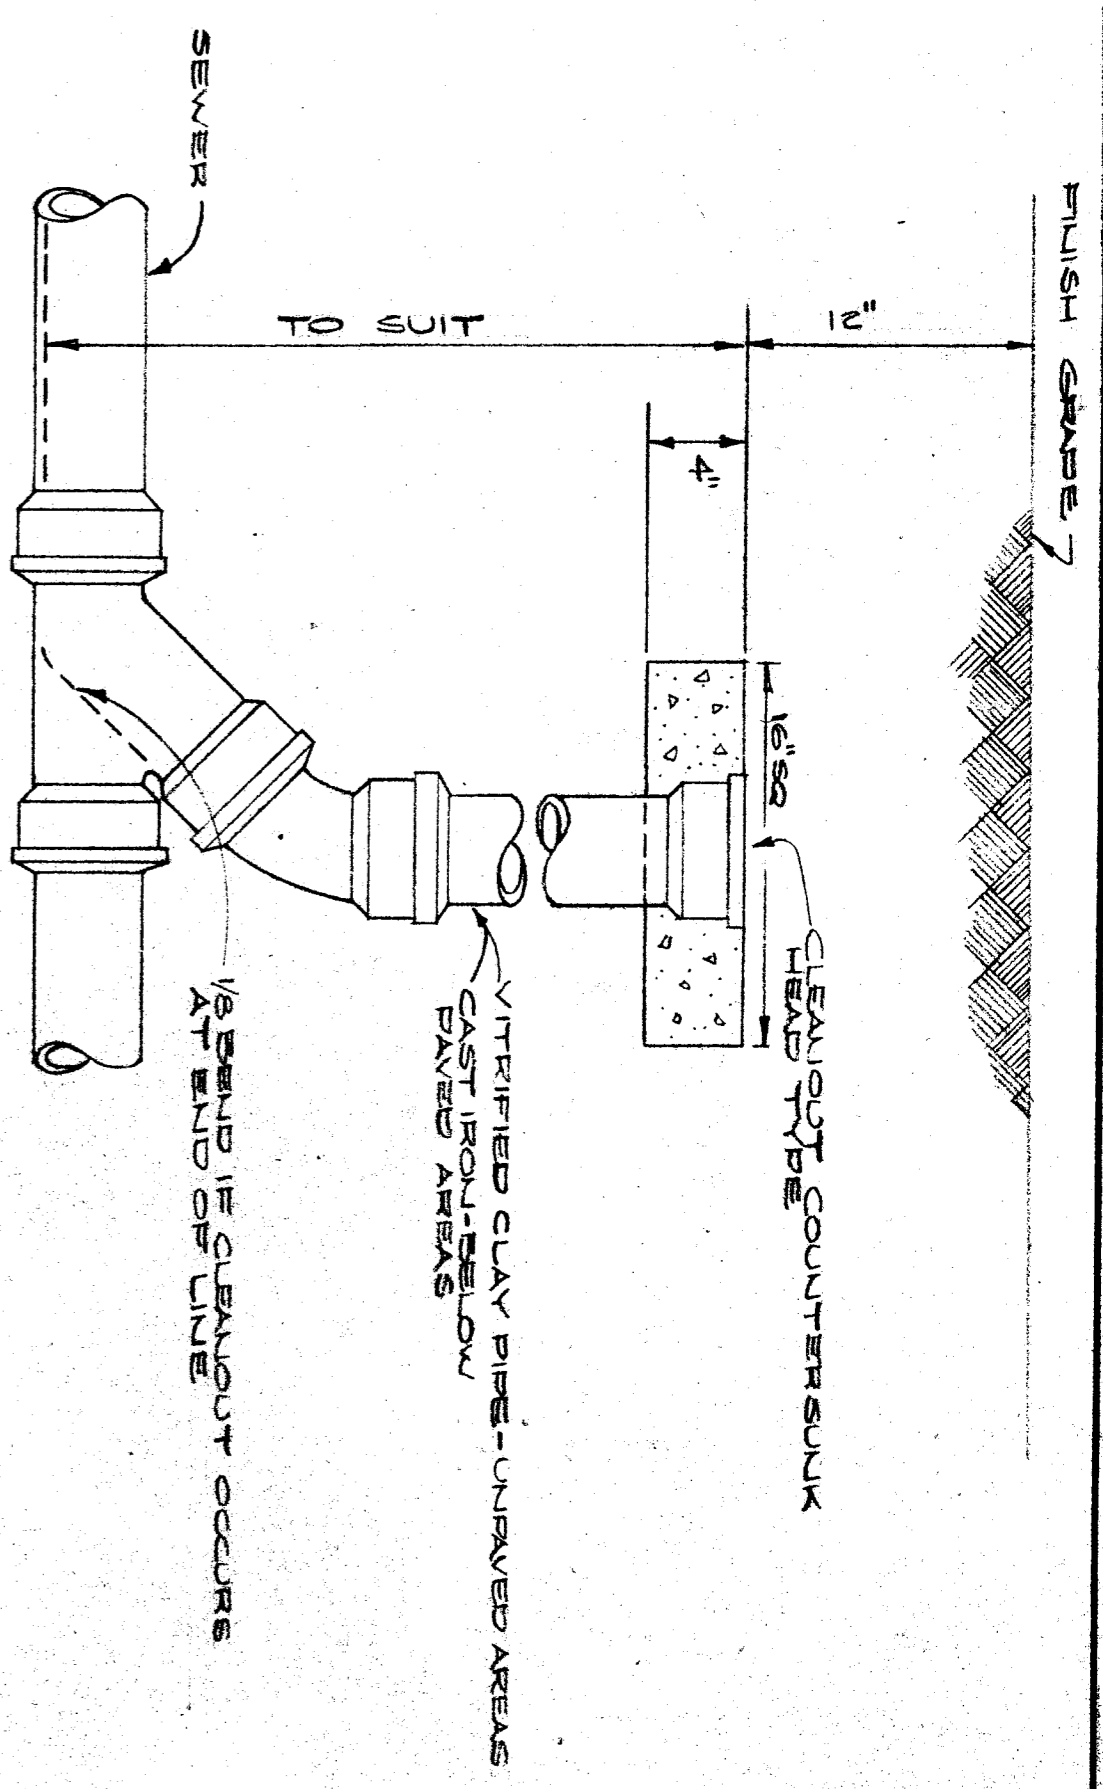

DETAIL OF CLEANOUT

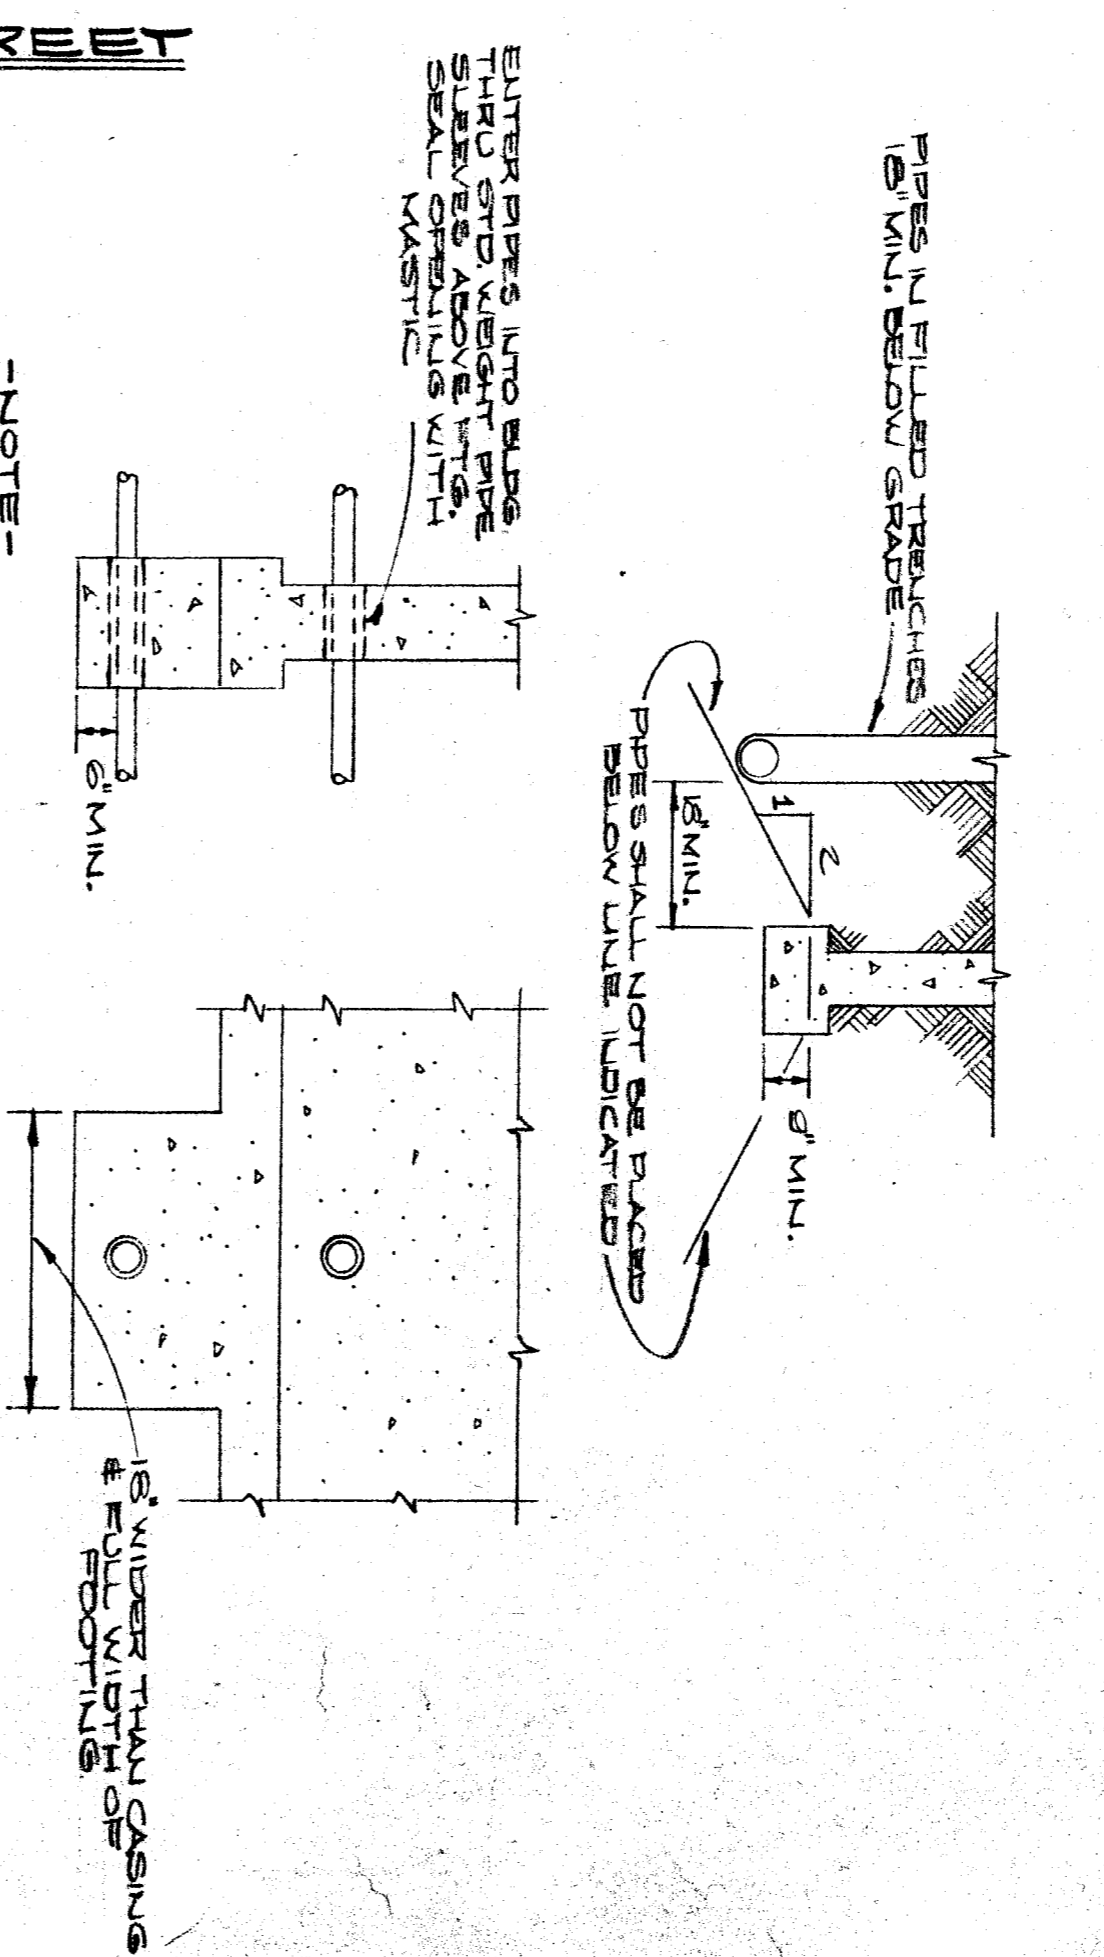

RELATION OF PIPES AND TRENCHES TO CONCRETE FOOTINGS

MECHANICAL PIPING SCHEDULE

MECHANICAL	PLAN
W	SOIL OR WASTE
V	VENT
CW	COLD WATER
GAS	NATURAL GAS
C.O.	CLEANOUT
GV	GATE VALVE
CHKV	CHECK VALVE
F	HEATING WATER FLOW
R	HEATING WATER RETURN
H.S.	1/2\"/>
H.W.	DOMESTIC HOT WATER 1/2\"/>
D.F.	DRINKING FOUNTAIN

NOTE - THESE PIPES CROSS UNDER & ARE NOT LESS THAN 8\"/>

581
193-11-54
239
Plan T. Dampier

W. A. STAINS
CONSULTING ENGINEER
ELECTRICAL
1405 PALMOPHIA AVENUE
BAKERSFIELD, CALIFORNIA

DIVISION OF ARCHITECTURE
STATE OF CALIFORNIA
MAR 19 1954
W. A. Stains

BOARD OF EDUCATION
PRES.
SEC.

MECHANICAL PLOT PLAN
DETAILS & SCHEDULE
WILLIAM PENN SCHOOL
BAKERSFIELD CALIFORNIA

Whitney Biggar ARCHITECT
MEMBER AMERICAN INSTITUTE OF ARCHITECTS
3601 STOCKDALE HIGHWAY
BAKERSFIELD, CALIFORNIA
29285 REGISTRATION C-11128

PROJECT NO. 2-54
DRAWN BY: JLR
CHECKED BY:
DATE: 2-23-54
SHEET 1
OF 1